
 


*FINAL DIMENSIONS ARE SUBJECT TO CHANGE DEPENDING ON CONTRACTORS ADJUSTMENTS ON SITE

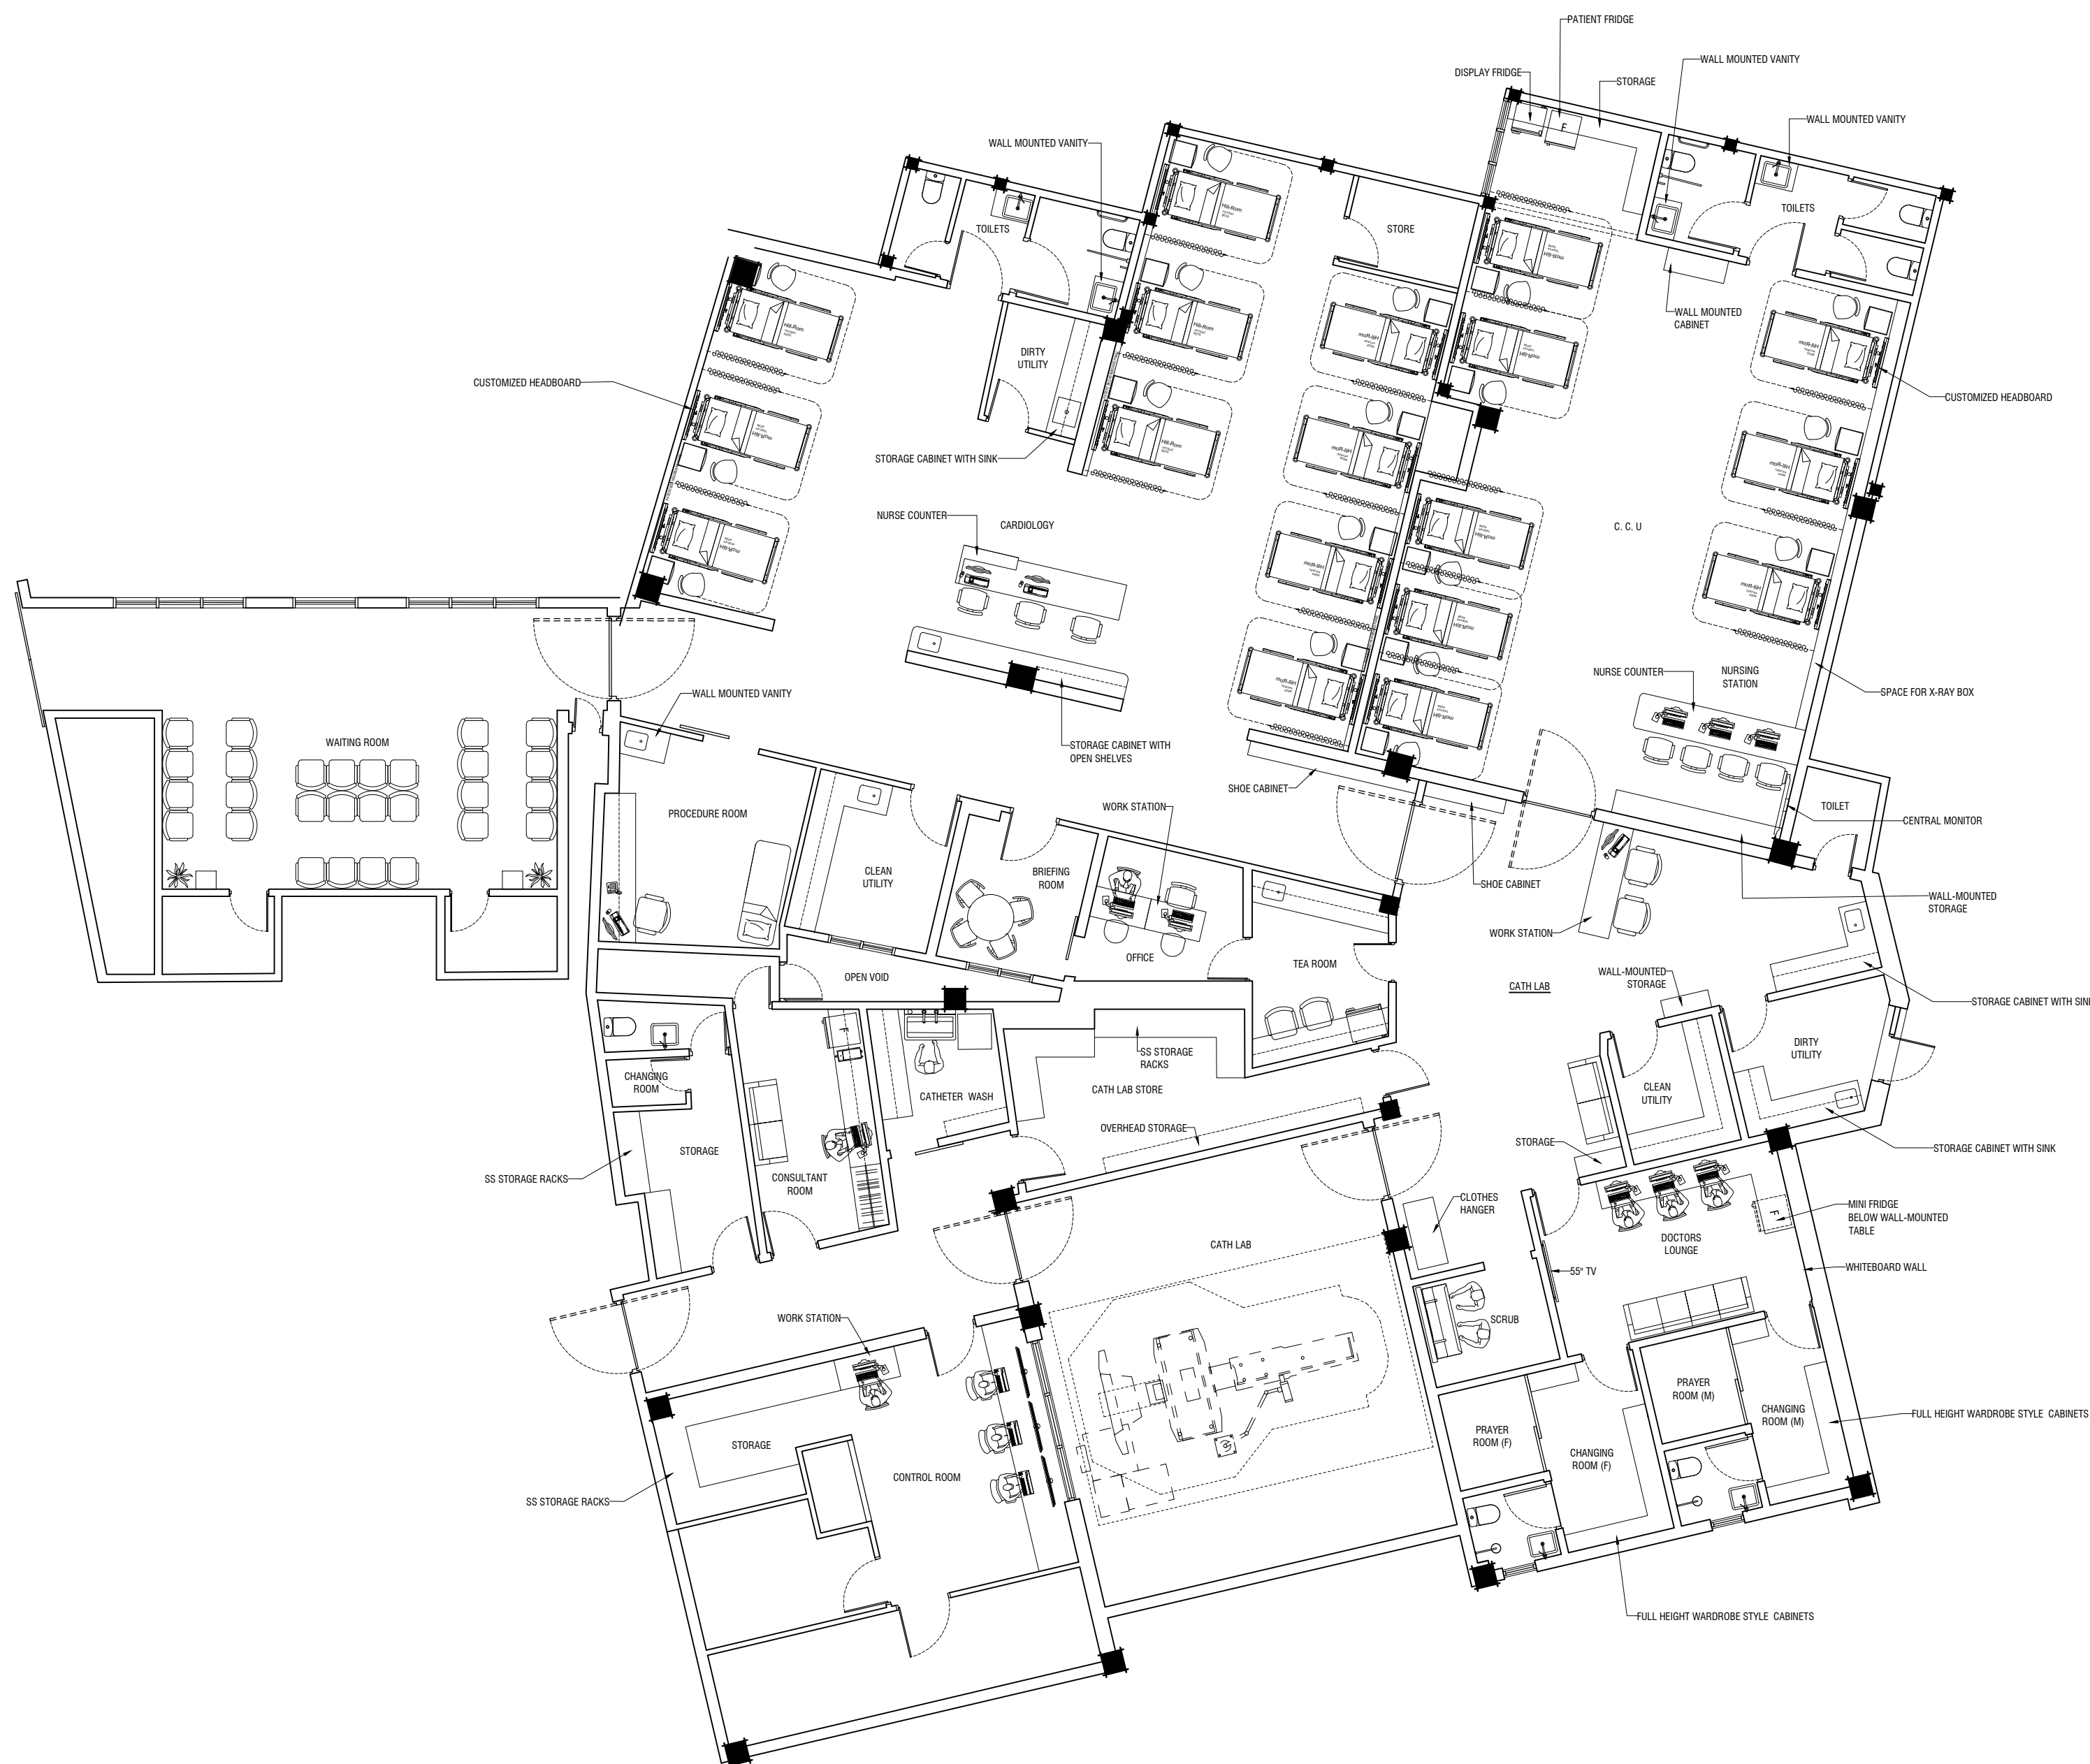

GENERAL FLOOR PLAN

SCALE = 1:100



MACO
DESIGNS

Contact: 7989966, 7691671

Email: info@maco.mv

CLIENT:

IGMH

PROJECT:

IGMH CATH LAB

K. MALE

SCALE: AS GIVEN

DRWNG TITLE : AS GIVN

DATE: D015M07Y26

REVISION NO.: 00

FILE NAME:



\\DLINK-031BBD\Volume_1\MACO
PROJECTS\2026

WARNING:

- This drawing shall not be used for construction unless certified.
- Contractor to verify all dimensions of existing works on site before commencing any work or preparing shop drawings.
- Do not scale drawings, use written dimensions only.
- This drawing is to be read in conjunction with the specifications and conditions of contract.
- This drawing and design is copyright and no portion may be reproduced without the permission of the MACO architects

A0

*FINAL DIMENSIONS ARE SUBJECT TO CHANGE DEPENDING ON CONTRACTORS ADJUSTMENTS ON SITE

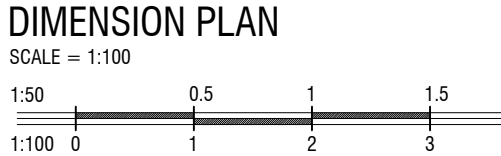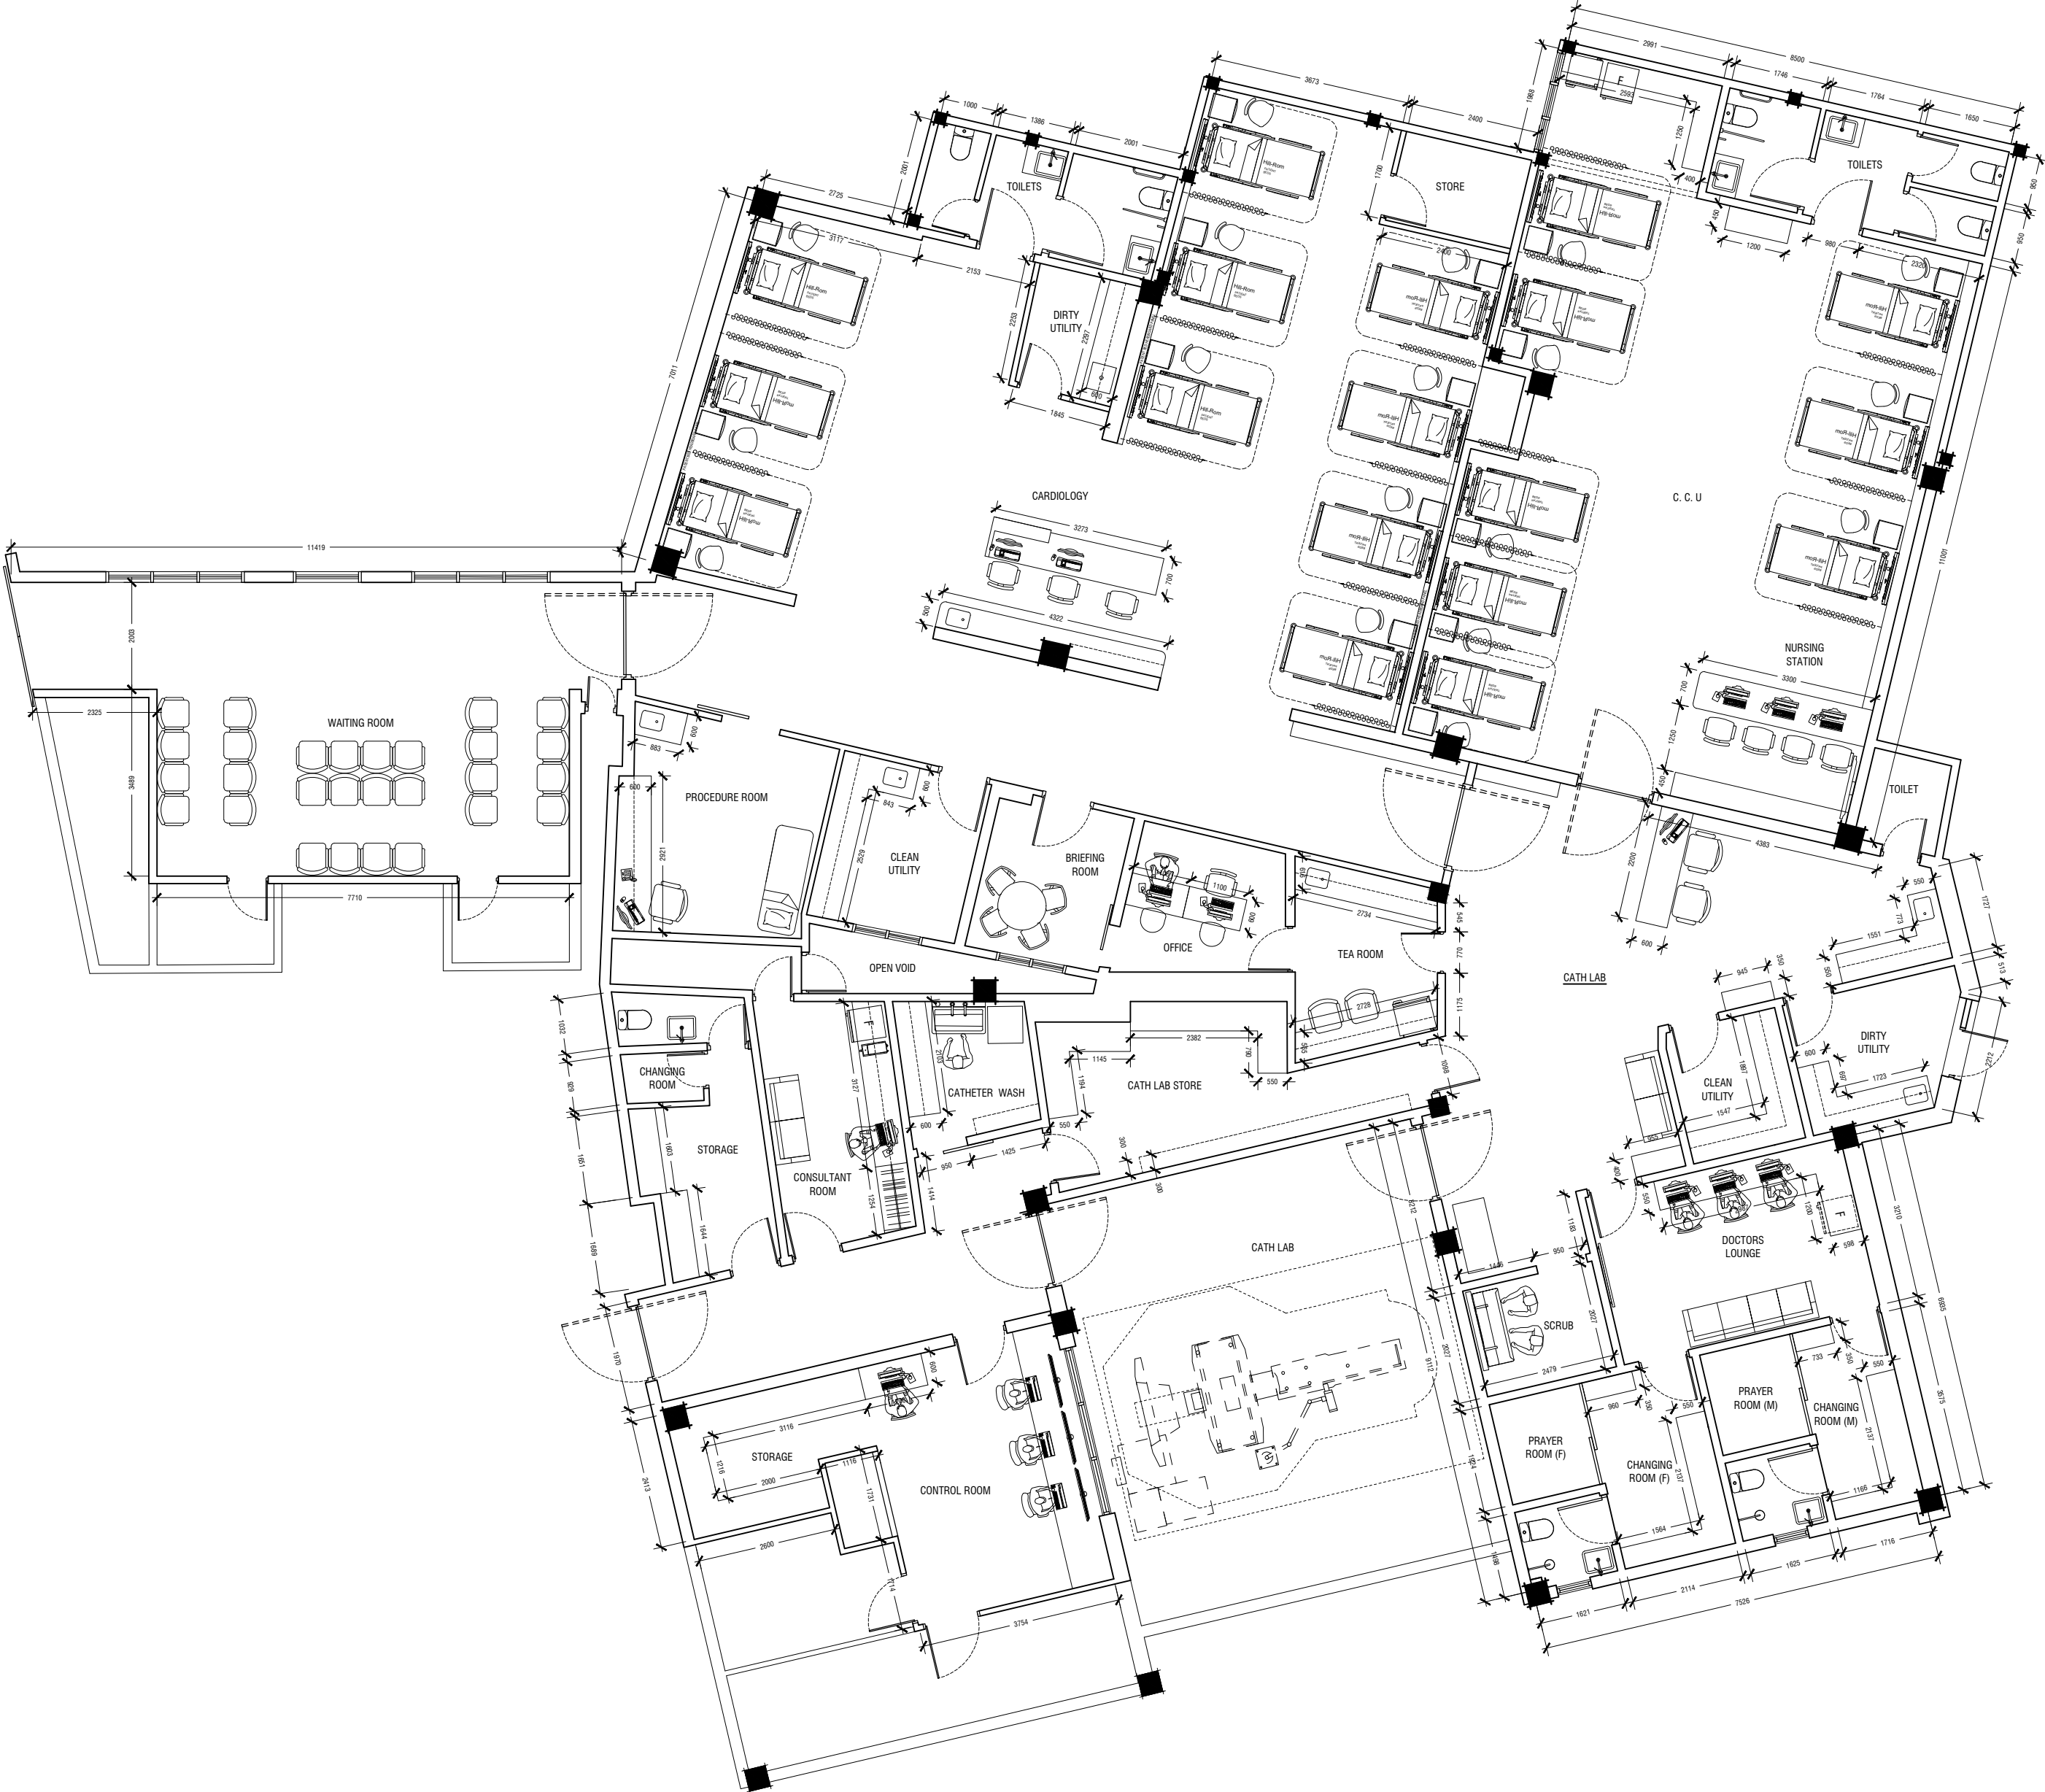

MACO
DESIGNS
Contact: 7989966, 7691671
Email: info@maco.mv

CLIENT:
IGMH

PROJECT:
IGMH CATH LAB
K. MALE

SCALE: AS GIVEN

DRWNG TITLE : AS GIVN

DATE: D015M07Y26

REVISION NO.: 00

FILE NAME:
\\DLINK-031BBD\Volume_1\MACO
PROJECTS\2026

WARNING:
- This drawing shall not be used for construction unless certified.
- Contractor to verify all dimensions of existing works on site before commencing any work or preparing shop drawings.
- Do not scale drawings, use written dimensions only.
- This drawing is to be read in conjunction with the specifications and conditions of contract.
- This drawing and design is copyright and no portion may be reproduced without the permission of the MACO architects

A1

*FINAL DIMENSIONS ARE SUBJECT TO CHANGE DEPENDING ON CONTRACTORS ADJUSTMENTS ON SITE



MACO
DESIGNS

Contact: 7989966, 7691671
Email: info@maco.mv

CLIENT:

IGMH

PROJECT:

IGMH CATH LAB
K. MALE

SCALE: AS GIVEN

DRWNG TITLE : AS GIVN

DATE: D015M07Y26

REVISION NO.: 00

FILE NAME:

 
\\DLINK-031BBD\Volume_1\MACO
PROJECTS\2026

WARNING:

- This drawing shall not be used for construction unless certified.
- Contractor to verify all dimensions of existing works on site before commencing any work or preparing shop drawings.
- Do not scale drawings, use written dimensions only.
- This drawing is to be read in conjunction with the specifications and conditions of contract.
- This drawing and design is copyright and no portion may be reproduced without the permission of the MACO architects

DEMOLITION PLAN

SCALE = 1:100



A2

*FINAL DIMENSIONS ARE SUBJECT TO CHANGE DEPENDING ON CONTRACTORS ADJUSTMENTS ON SITE



MACO
DESIGNS

Contact: 7989966, 7691671
Email: info@maco.mv

CLIENT:

IGMH

PROJECT:

IGMH CATH LAB
K. MALE

SCALE: AS GIVEN

DRWNG TITLE : AS GIVN

DATE: D015M07Y26

REVISION NO.: 00

FILE NAME:

\\DLINK-031BBD\Volume_1\MACO
PROJECTS\2026

WARNING:

- This drawing shall not be used for construction unless certified.
- Contractor to verify all dimensions of existing works on site before commencing any work or preparing shop drawings.
- Do not scale drawings, use written dimensions only.
- This drawing is to be read in conjunction with the specifications and conditions of contract.
- This drawing and design is copyright and no portion may be reproduced without the permission of the MACO architects


NEW WALL PLAN

SCALE = 1:100



A3

*FINAL DIMENSIONS ARE SUBJECT TO CHANGE DEPENDING ON CONTRACTORS ADJUSTMENTS ON SITE

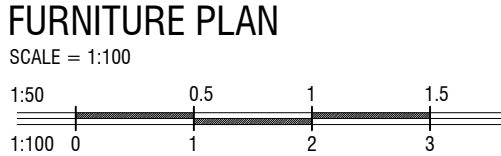

Contact: 7989966, 7691671
 Email: info@maco.mv

CLIENT:

IGMH

PROJECT:

IGMH CATH LAB

K. MALE

SCALE: AS GIVEN

DRWNG TITLE : AS GIVN

DATE: D015M07Y26

REVISION NO.: 00

FILE NAME:

\\DLINK-031BBD\Volume_1\MACO PROJECTS\2026

WARNING:

- This drawing shall not be used for construction unless certified.
- Contractor to verify all dimensions of existing works on site before commencing any work or preparing shop drawings.
- Do not scale drawings, use written dimensions only.
- This drawing is to be read in conjunction with the specifications and conditions of contract.
- This drawing and design is copyright and no portion may be reproduced without the permission of the MACO architects

*FINAL DIMENSIONS ARE SUBJECT TO CHANGE DEPENDING ON CONTRACTORS ADJUSTMENTS ON SITE


LEGEND		
CODE	HATCH	FINISH
T1		WHITE PLAIN WALL PANEL (SEMI GLOSS)
T2		SAGE GREEN WALL PANEL (SEMI GLOSS)
T3		MEDIUM WOOD TONE PLAIN WALL PANEL (MATTE)
T4		THIN WHITE ACRYLIC SHEET (GLOSSY)
T5	-	300MM X 600MM WALL TILES

LEGEND		
SYMBOL	HATCH	FINISH
F1		PVC VINYL FLOORING (WHITE)
F2		PVC VINYL FLOORING (GREEN)
F3		600MM X 600MM FLOOR TILES



PROPOSED FINISH PLAN

 SCALE = 1:100



MACO
DESIGNS

Contact: 7989966, 7691671

Email: info@maco.mv

CLIENT:

IGMH

PROJECT:

IGMH CATH LAB
K. MALE

SCALE: AS GIVEN

DRWNG TITLE : AS GIVN

DATE: D015M07Y26

REVISION NO.: 00

FILE NAME:

\\DLINK-031BBD\Volume_1\MACO
PROJECTS\2026


WARNING:

- This drawing shall not be used for construction unless certified.
- Contractor to verify all dimensions of existing works on site before commencing any work or preparing shop drawings.
- Do not scale drawings, use written dimensions only.
- This drawing is to be read in conjunction with the specifications and conditions of contract.
- This drawing and design is copyright and no portion may be reproduced without the permission of the MACO architects

A5

*FINAL DIMENSIONS ARE SUBJECT TO CHANGE DEPENDING ON CONTRACTORS ADJUSTMENTS ON SITE

LEGEND		
SYMBOL	HATCH	DESCRIPTION
(C1)		CEILING 1 (GRID CEILING) +2850MM FROM FFL
(C2)		CEILING 2 (FIXED CEILING) +2850MM FROM FFL

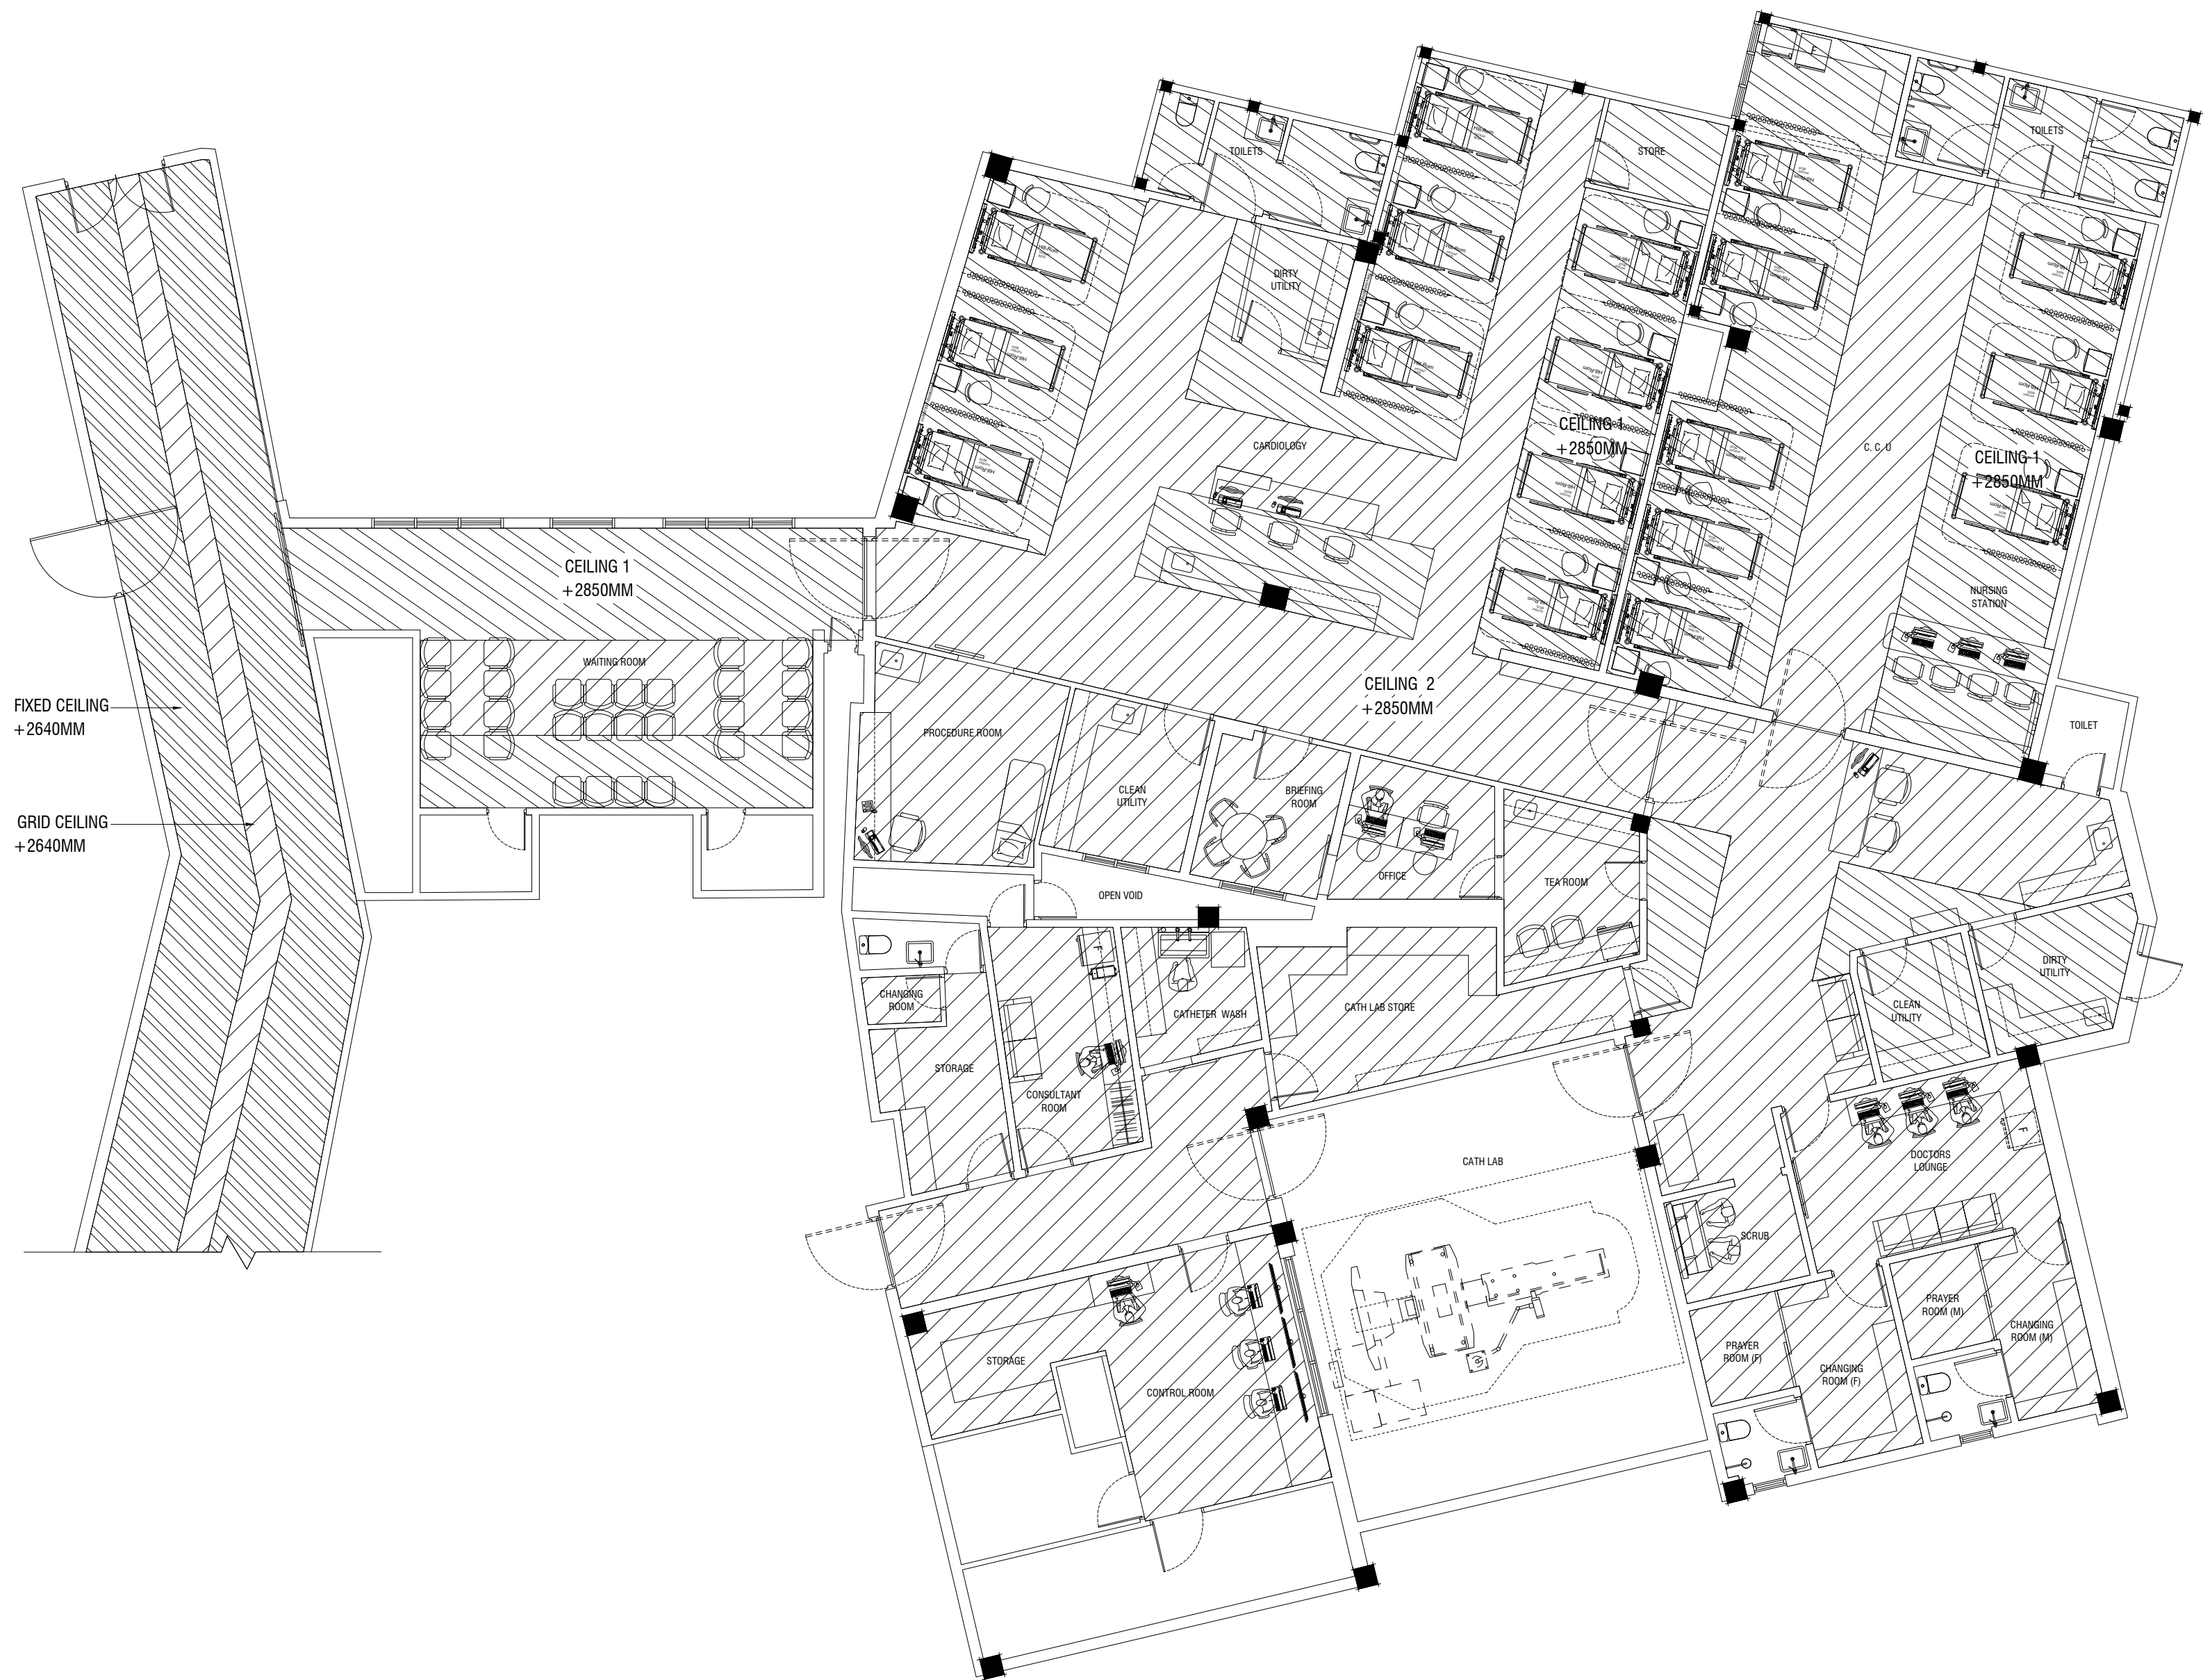

MACO
DESIGNS

Contact: 7989966, 7691671

Email: info@maco.mv

CLIENT:
IGMH

PROJECT:
IGMH CATH LAB
K. MALE

SCALE: AS GIVEN

DRWNG TITLE : AS GIVN

DATE: D015M07Y26

REVISION NO.: 00

 
FILE NAME:
\\DLINK-031BBD\Volume_1\MACO
PROJECTS\2026

WARNING:

- This drawing shall not be used for construction unless certified.
- Contractor to verify all dimensions of existing works on site before commencing any work or preparing shop drawings.
- Do not scale drawings, use written dimensions only.
- This drawing is to be read in conjunction with the specifications and conditions of contract.
- This drawing and design is copyright and no portion may be reproduced without the permission of the MACO architects

CEILING PLAN

SCALE = 1:100



A6

*FINAL DIMENSIONS ARE SUBJECT TO CHANGE DEPENDING ON CONTRACTORS ADJUSTMENTS ON SITE



Contact: 7989966, 7691671
Email: info@maco.mv

CLIENT:

IGMH

PROJECT:

IGMH CATH LAB
K. MALE

SCALE: AS GIVEN

DRWNG TITLE : AS GIVN

DATE: D015M07Y26

REVISION NO.: 00

FILE NAME:

\\DLINK-031BBD\Volume_1\MACO PROJECTS\2026


WARNING:

- This drawing shall not be used for construction unless certified.
- Contractor to verify all dimensions of existing works on site before commencing any work or preparing shop drawings.
- Do not scale drawings, use written dimensions only.
- This drawing is to be read in conjunction with the specifications and conditions of contract.
- This drawing and design is copyright and no portion may be reproduced without the permission of the MACO architects

LIGHTING AND ELECTRICAL PLAN



*FINAL DIMENSIONS ARE SUBJECT TO CHANGE DEPENDING ON CONTRACTORS ADJUSTMENTS ON SITE

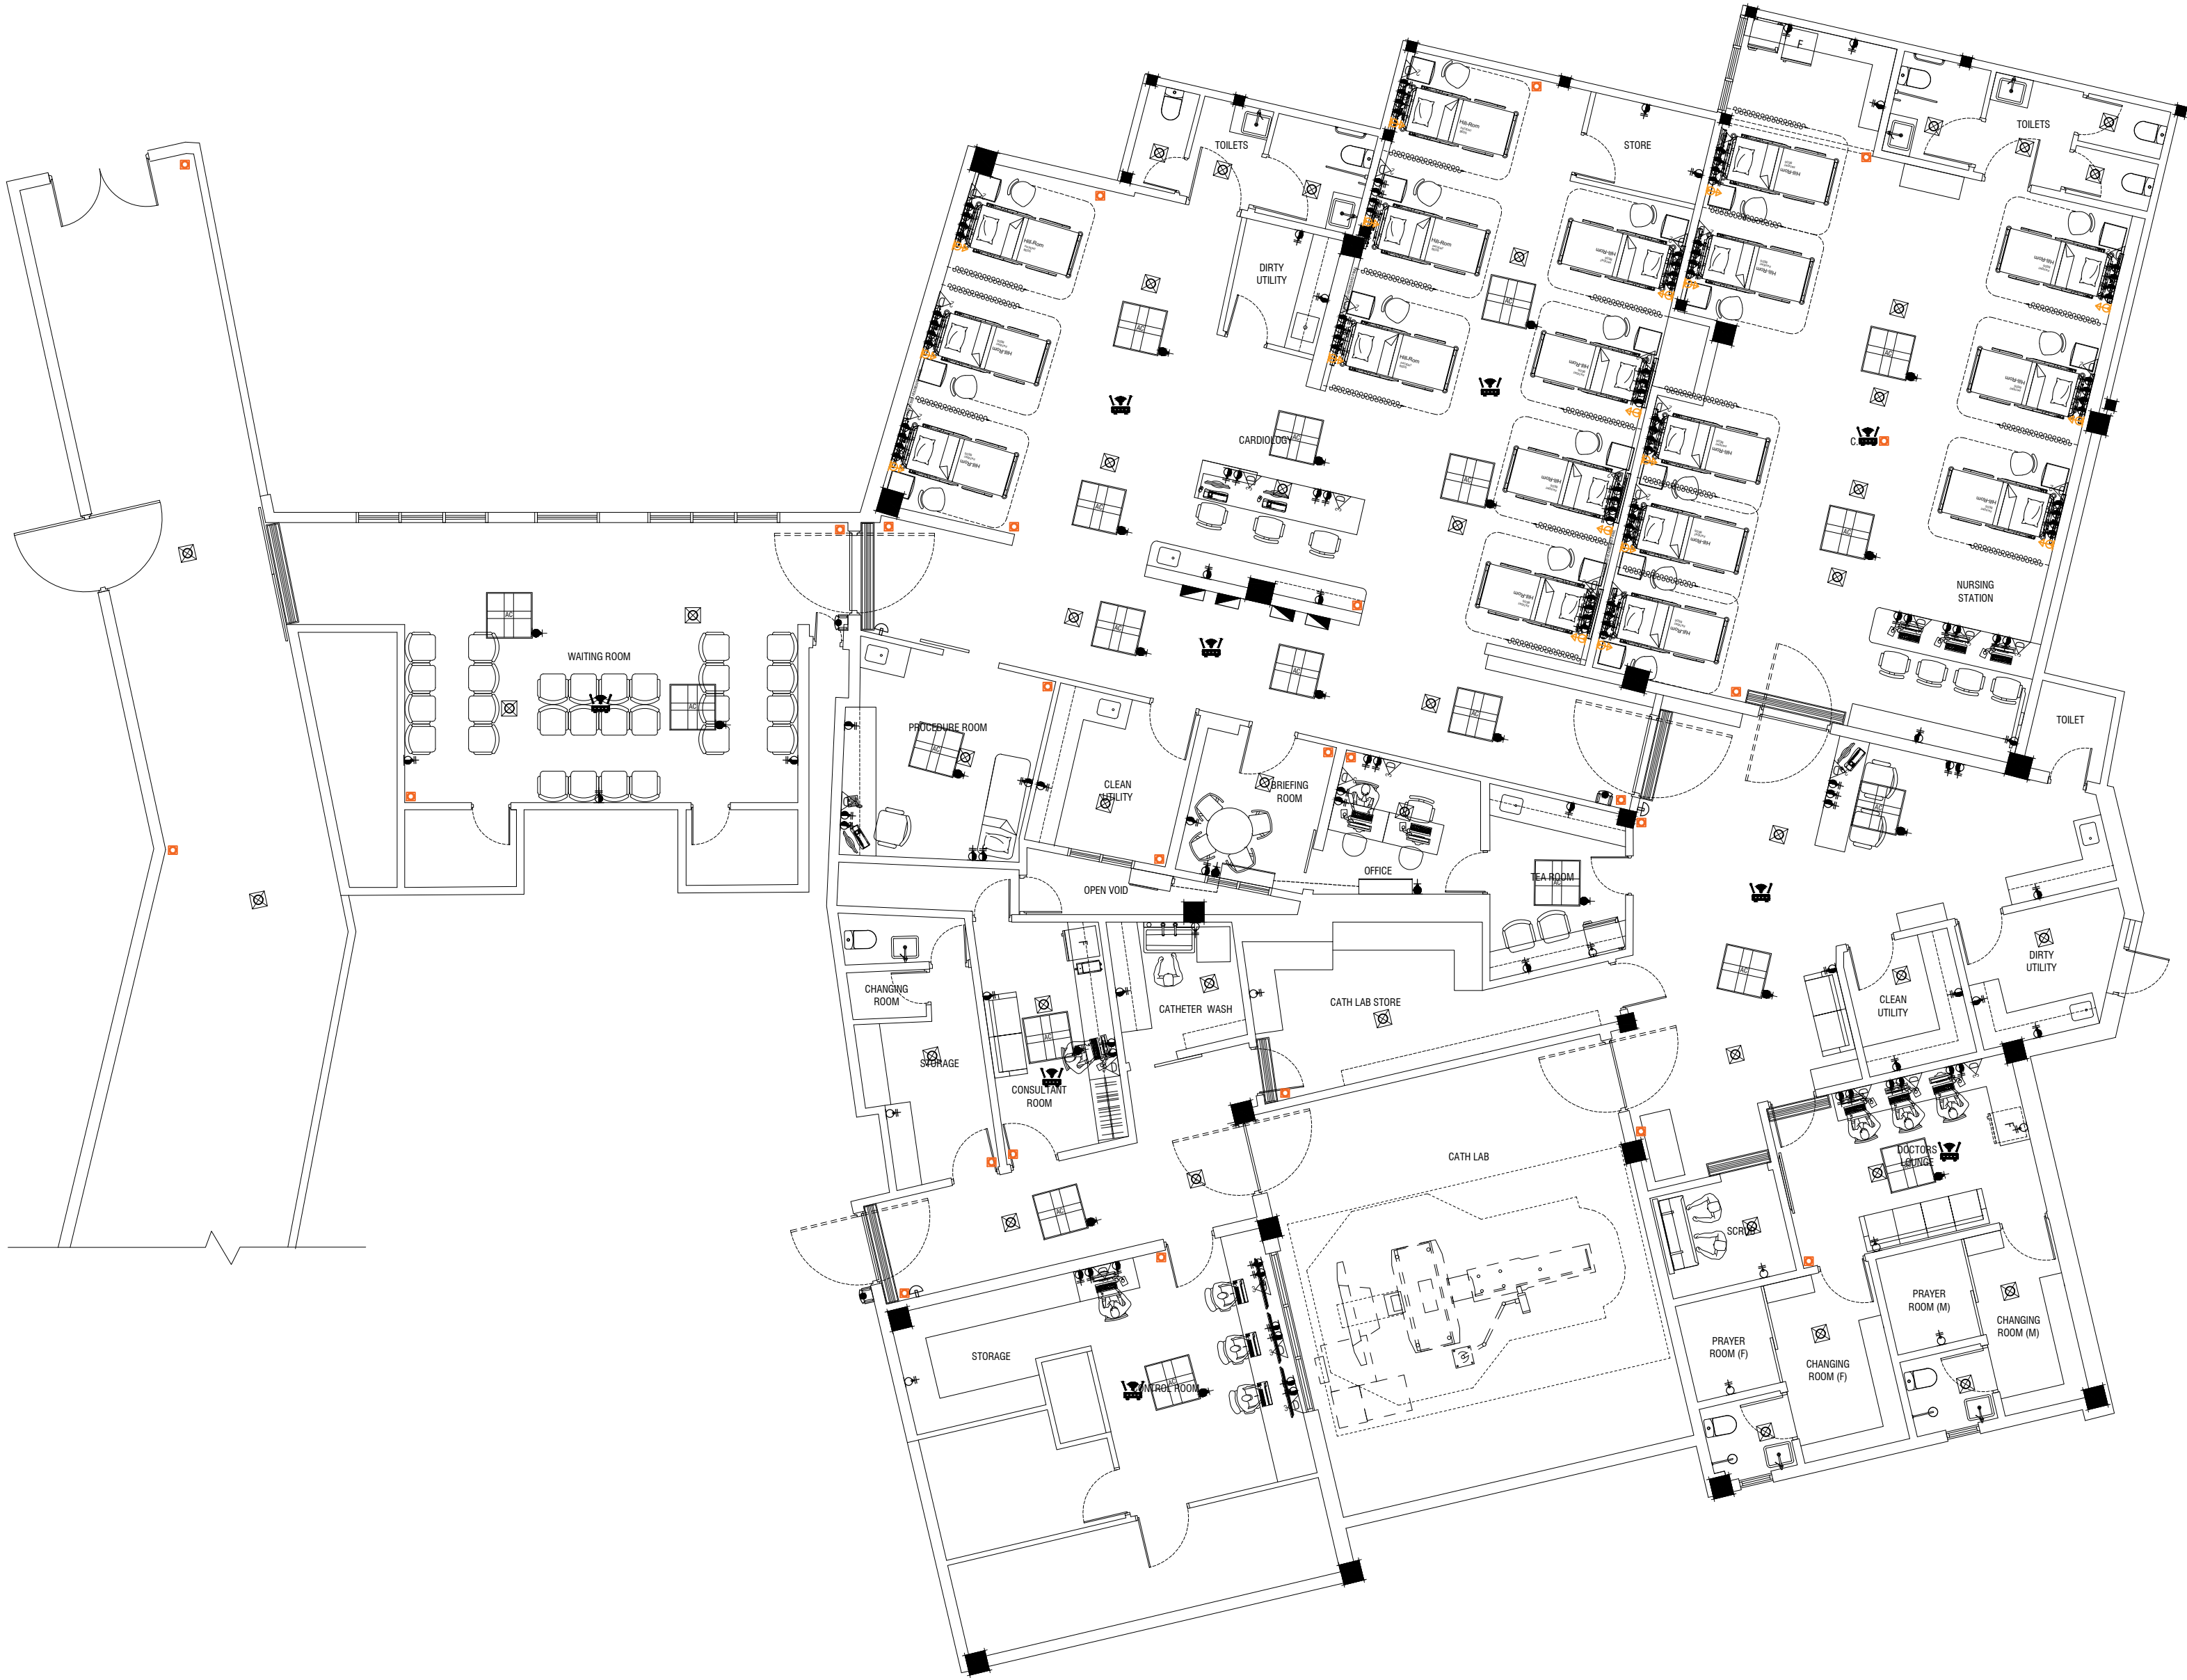

MACO
DESIGNS

Contact: 7989966, 7691671
Email: info@maco.mv

CLIENT:

IGMH

PROJECT:

IGMH CATH LAB
K. MALE

SCALE: AS GIVEN

DRWNG TITLE : AS GIVN

DATE: D015M07Y26

REVISION NO.: 00

FILE NAME:

\\DLINK-031BBD\Volume_1\MACO
PROJECTS\2026

WARNING:

- This drawing shall not be used for construction unless certified.
- Contractor to verify all dimensions of existing works on site before commencing any work or preparing shop drawings.
- Do not scale drawings, use written dimensions only.
- This drawing is to be read in conjunction with the specifications and conditions of contract.
- This drawing and design is copyright and no portion may be reproduced without the permission of the MACO architects

DATA, NETWORK & POWER PLAN



ELECTRICAL LEGEND:

SYMBOL	DESCRIPTION
	ONE GANG SWITCH @ 1200 MM FROM FFL
	TWO GANG SWITCH @ 1200 MM FROM FFL
	THREE GANG SWITCH @ 1200 MM FROM FFL
	FOUR GANG SWITCH @ 1200 MM FROM FFL
	FAN DIMMER SWITCH @ 1200 MM FROM FFL
	LIGHT DIMMER SWITCH @ 1200 MM FROM FFL
	13 AMP SOCKET @ 300 MM FROM FFL
	13 AMP DOUBLE SOCKET @ 300 MM FROM FFL
	13 AMP SOCKET @ 1200 MM FROM FFL
	13 AMP DOUBLE SOCKET @ CEILING LEVEL
	13 AMP DOUBLE SOCKET @ 1000 MM FROM FFL
	15 AMP SOCKET @ 1800 MM FROM FFL
	NURSE CALL POINT
	13 AMP DOUBLE SOCKET @ CEILING LEVEL
	15 AMP SOCKET @ CEILING LEVEL
	1 X 2 DATA OUTLET @ 1000MM FROM FFL
	1 X 3 DATA OUTLET @ 1000MM FROM FFL
	ACCESS CONTROLLER SYSTEM @ 1200 MM FROM FFL
	EXIT SWITCH
	CCTV CAMERA (DOME) @ CEILING LEVEL
	DISTRIBUTION BOARD
W	WEATHER PROOF
AC	AIR-CONDITIONER
WH	WATER HEATER (TOILETS)
E	EMERGENCY LIGHT
	TOILET MIRROR F-TUBE LIGHT @ 1800 MM FROM FFL (WEATHER PROOF)
	WIFI POINT @ CEILING LEVEL
	150 MM Ø RECESSED CEILING DOWN LIGHT
	600MM X 600MM CEILING RESIST LED LIGHT
	CEILING MOUNT EXHAUST FAN CONTROLLED FROM LIGHT SWITCH
	CASSETTE AIR CONDITION INDOOR UNIT
	CEILING MOUNT FRESH AIR INLET GRILL CONTROLLED FROM LIGHT SWITCH
	WALL MOUNT SPLIT TYPE AIR CONDITION INDOOR UNIT
	AIR CONDITION OUTDOOR UNIT

NOTE: DETAILED ELECTRICAL SYSTEM TO BE DESIGNED BY THE CONTRACTOR

MACO
DESIGNS

Contact: 7989966, 7691671

Email: info@maco.mv

CLIENT:

IGMH

PROJECT:

IGMH CATH LAB

K. MALE

SCALE: AS GIVEN

DRWNG TITLE : AS GIVN

DATE: D015M07Y26

REVISION NO.: 00

FILE NAME:

\\DLINK-031BBD\Volume_1\MACO
PROJECTS\2026

WARNING:

- This drawing shall not be used for construction unless certified.
- Contractor to verify all dimensions of existing works on site before commencing any work or preparing shop drawings.
- Do not scale drawings, use written dimensions only.
- This drawing is to be read in conjunction with the specifications and conditions of contract.
- This drawing and design is copyright and no portion may be reproduced without the permission of the MACO architects


LEGEND

SCALE = 1:100



A9

- NOTE
- CL = CEILING LINE
 - DCL = DROP CEILING LINE
 - FFL = FLOOR FINISH LINE

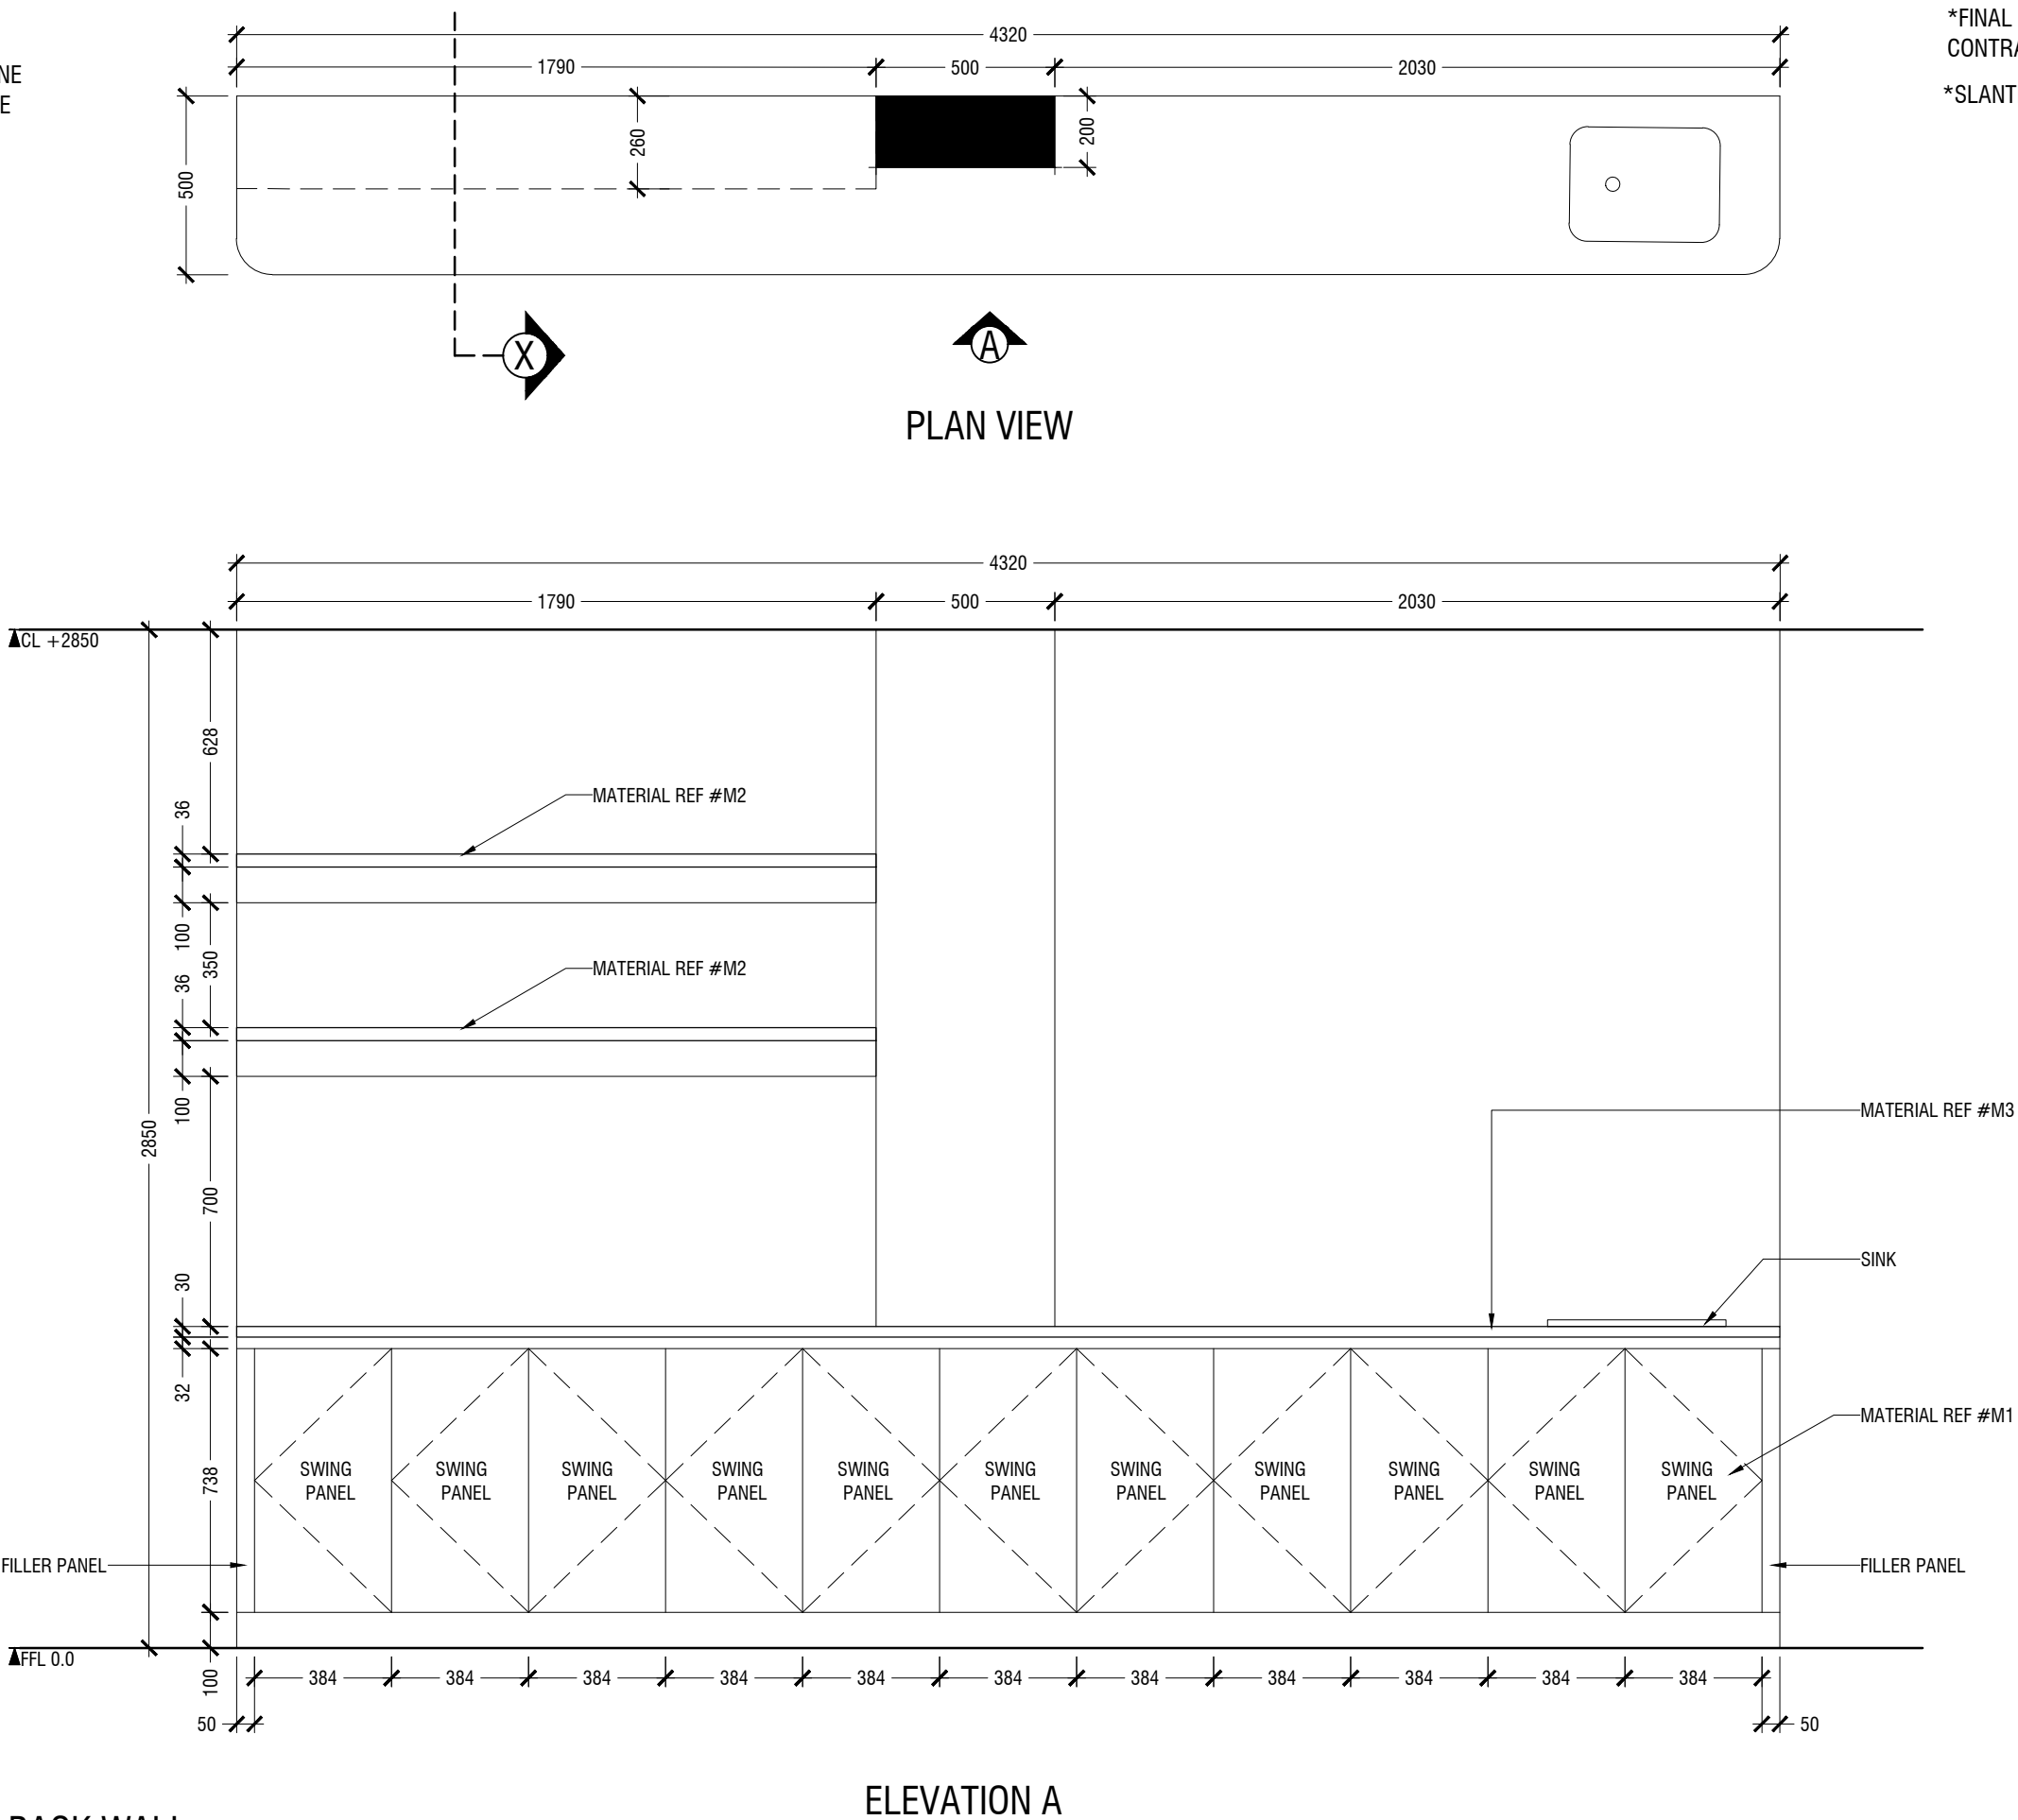

*FINAL DIMENSIONS ARE SUBJECT TO CHANGE DEPENDING ON CONTRACTORS ADJUSTMENTS ON SITE

*SLANTED WALL ALIGNMENT TO BE CONFIRMED ON SITE

MACO

DESIGNS

Contact: 7989966, 7691671

Email: info@maco.mv

CLIENT:

IGMH

PROJECT:

IGMH CATH LAB

K. MALE

SCALE: AS GIVEN

DRWNG TITLE : AS GIVN

DATE: D015M07Y26

REVISION NO.: 00

FILE NAME:

\\DLINK-031BBD\Volume_1\MACO
PROJECTS\2026

WARNING:

- This drawing shall not be used for construction unless certified.
- Contractor to verify all dimensions of existing works on site before commencing any work or preparing shop drawings.
- Do not scale drawings, use written dimensions only.
- This drawing is to be read in conjunction with the specifications and conditions of contract.
- This drawing and design is copyright and no portion may be reproduced without the permission of the MACO architects

1.00



RECEPTION BACK WALL
LOCATION "CARDIOLOGY WARD"
SCALE 1:20

ID01

- NOTE
- CL = CEILING LINE
 - DCL = DROP CEILING LINE
 - FFL = FLOOR FINISH LINE

*FINAL DIMENSIONS ARE SUBJECT TO CHANGE DEPENDING ON CONTRACTORS ADJUSTMENTS ON SITE

*SLANTED WALL ALIGNMENT TO BE CONFIRMED ON SITE

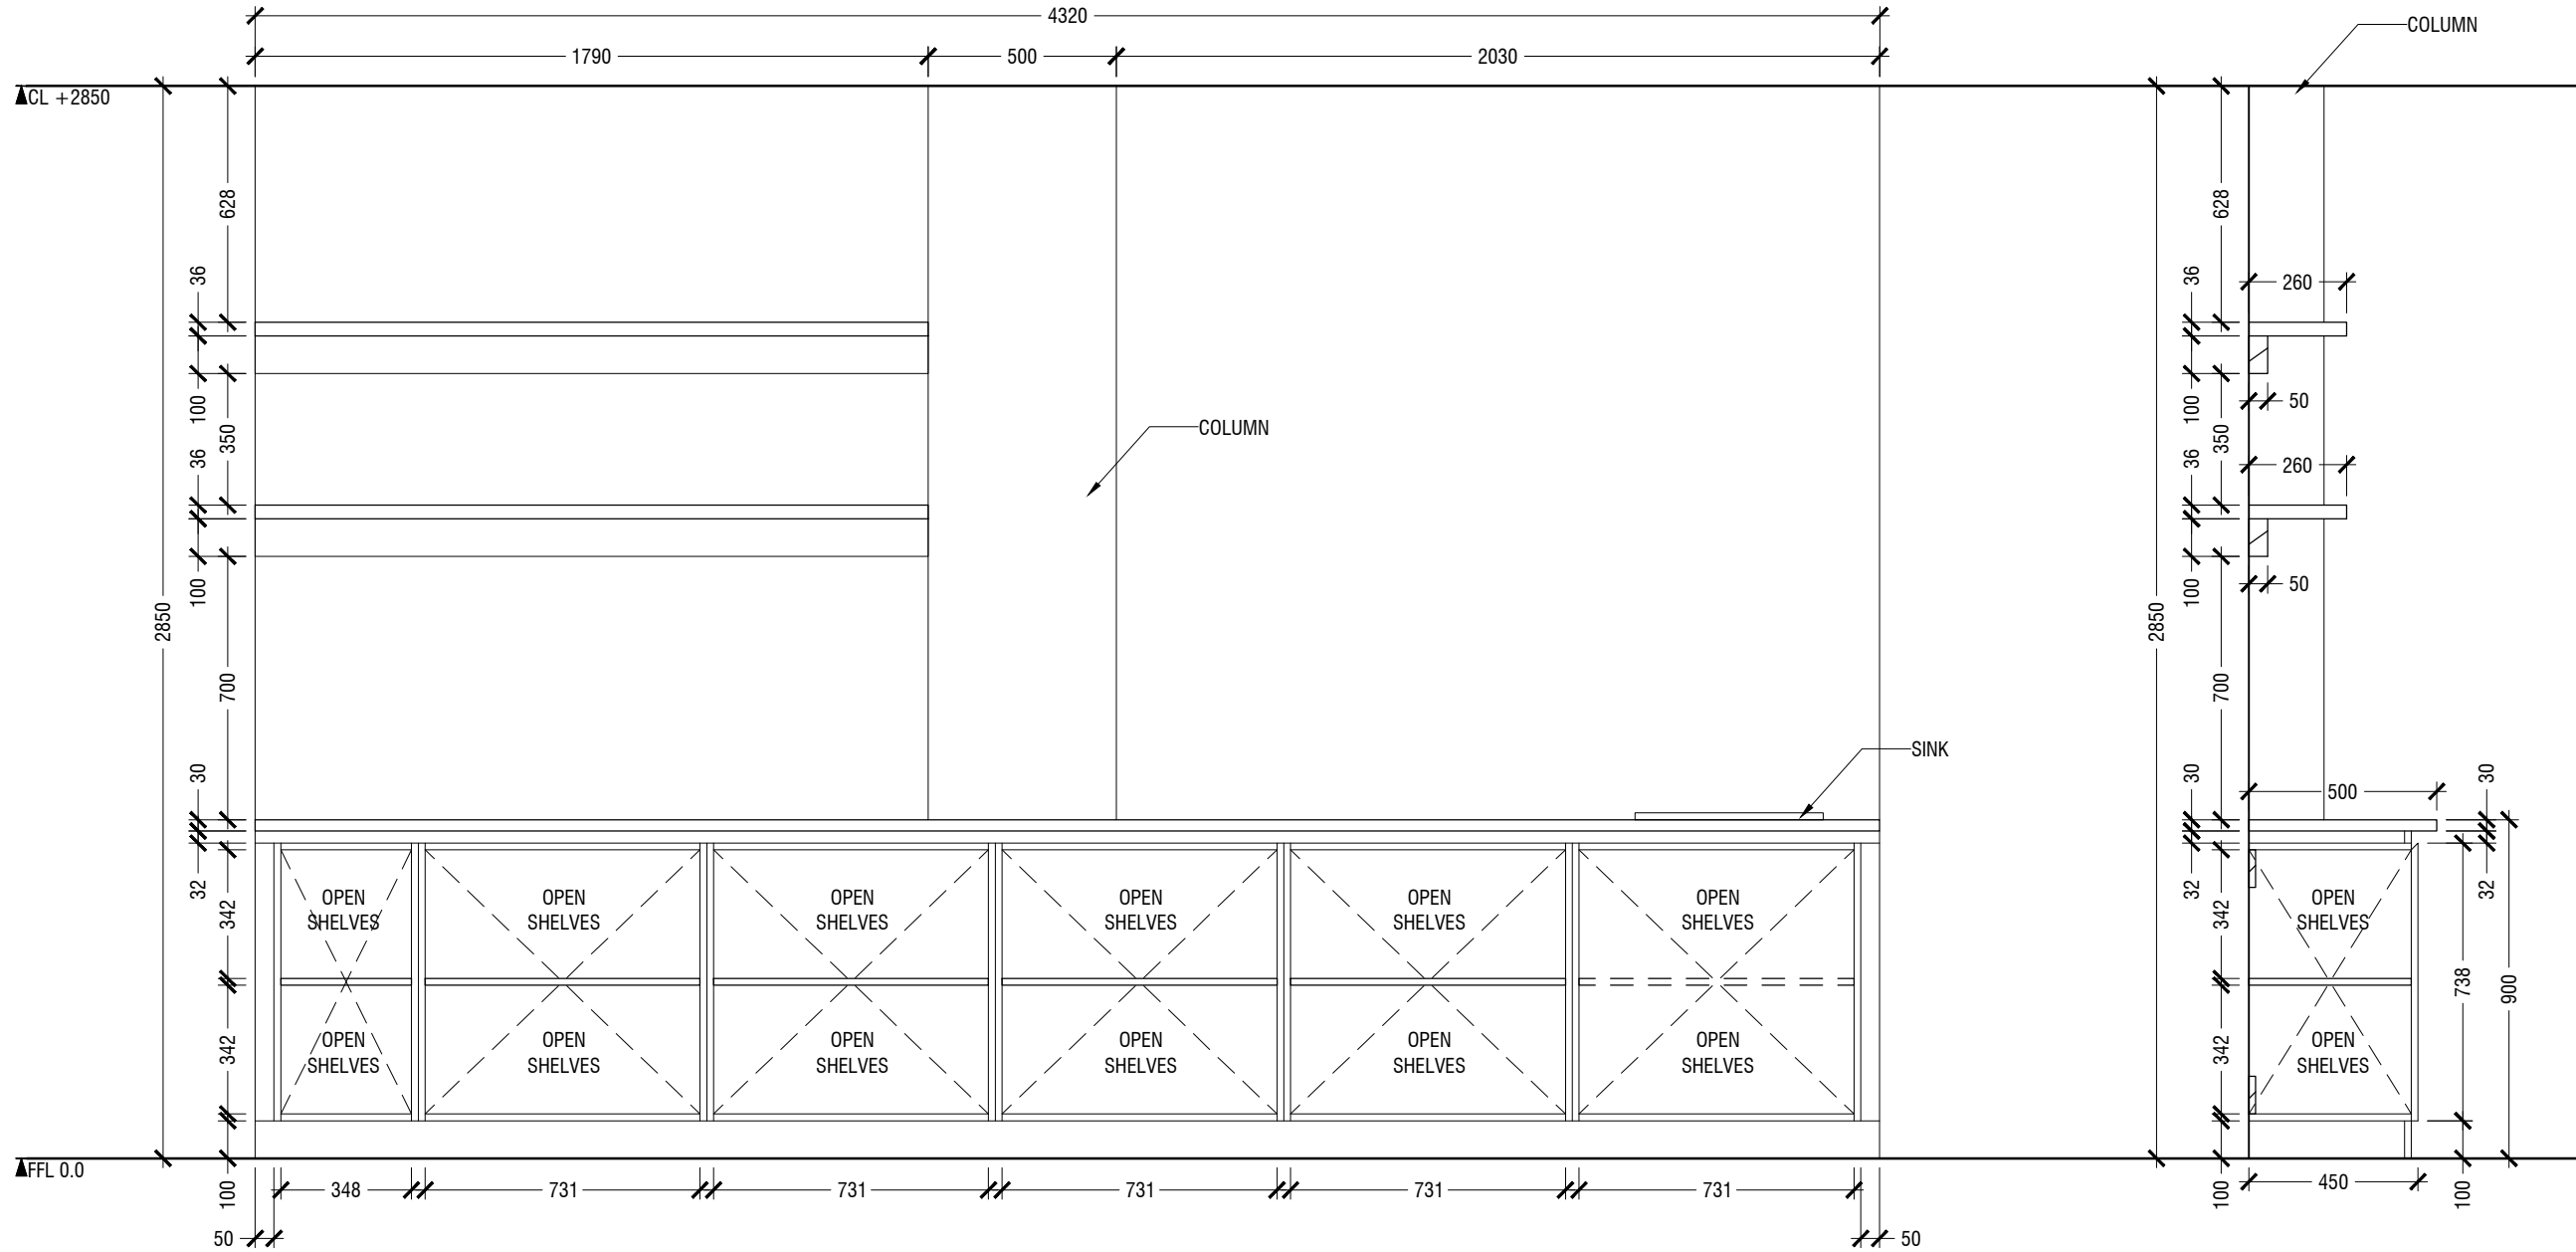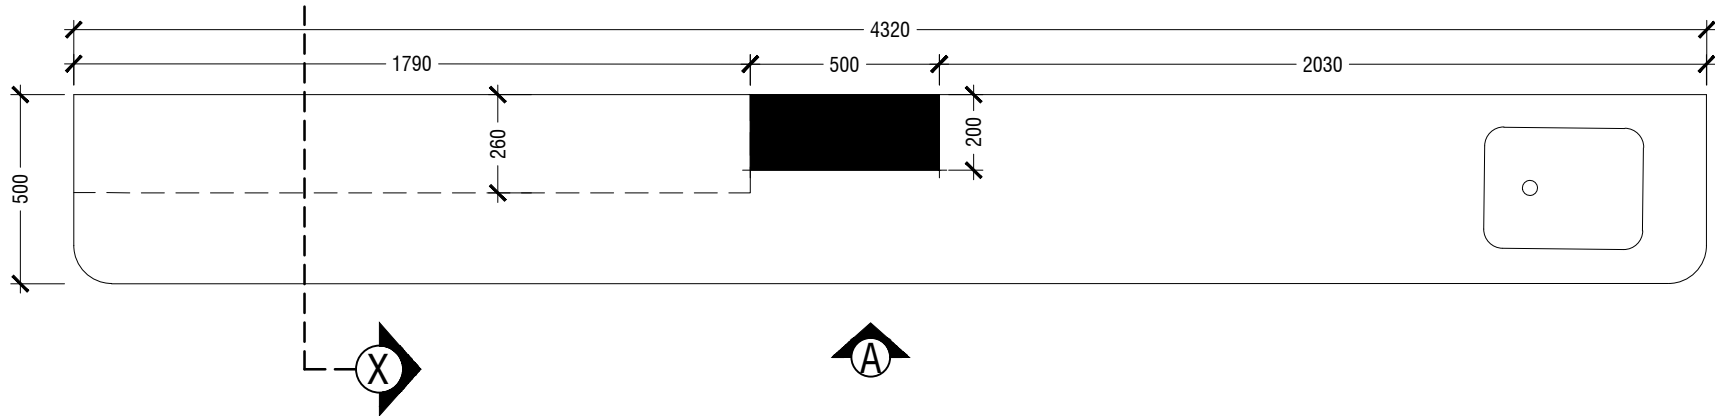

MACO
DESIGNS

Contact: 7989966, 7691671
Email: info@maco.mv

CLIENT:
IGMH

PROJECT:
IGMH CATH LAB
K. MALE

SCALE: AS GIVEN

DRWNG TITLE : AS GIVN

DATE: D015M07Y26

REVISION NO.: 00

FILE NAME:
\\DLINK-031BBD\Volume_1\MACO
PROJECTS\2026

WARNING:

- This drawing shall not be used for construction unless certified.
- Contractor to verify all dimensions of existing works on site before commencing any work or preparing shop drawings.
- Do not scale drawings, use written dimensions only.
- This drawing is to be read in conjunction with the specifications and conditions of contract.
- This drawing and design is copyright and no portion may be reproduced without the permission of the MACO architects


1.00 RECEPTION BACK WALL
LOCATION "CARDIOLOGY WARD"
SCALE 1:20

ID02


- NOTE
- CL = CEILING LINE
 - DCL = DROP CEILING LINE
 - FFL = FLOOR FINISH LINE

*FINAL DIMENSIONS ARE SUBJECT TO CHANGE DEPENDING ON CONTRACTORS ADJUSTMENTS ON SITE

*SLANTED WALL ALIGNMENT TO BE CONFIRMED ON SITE

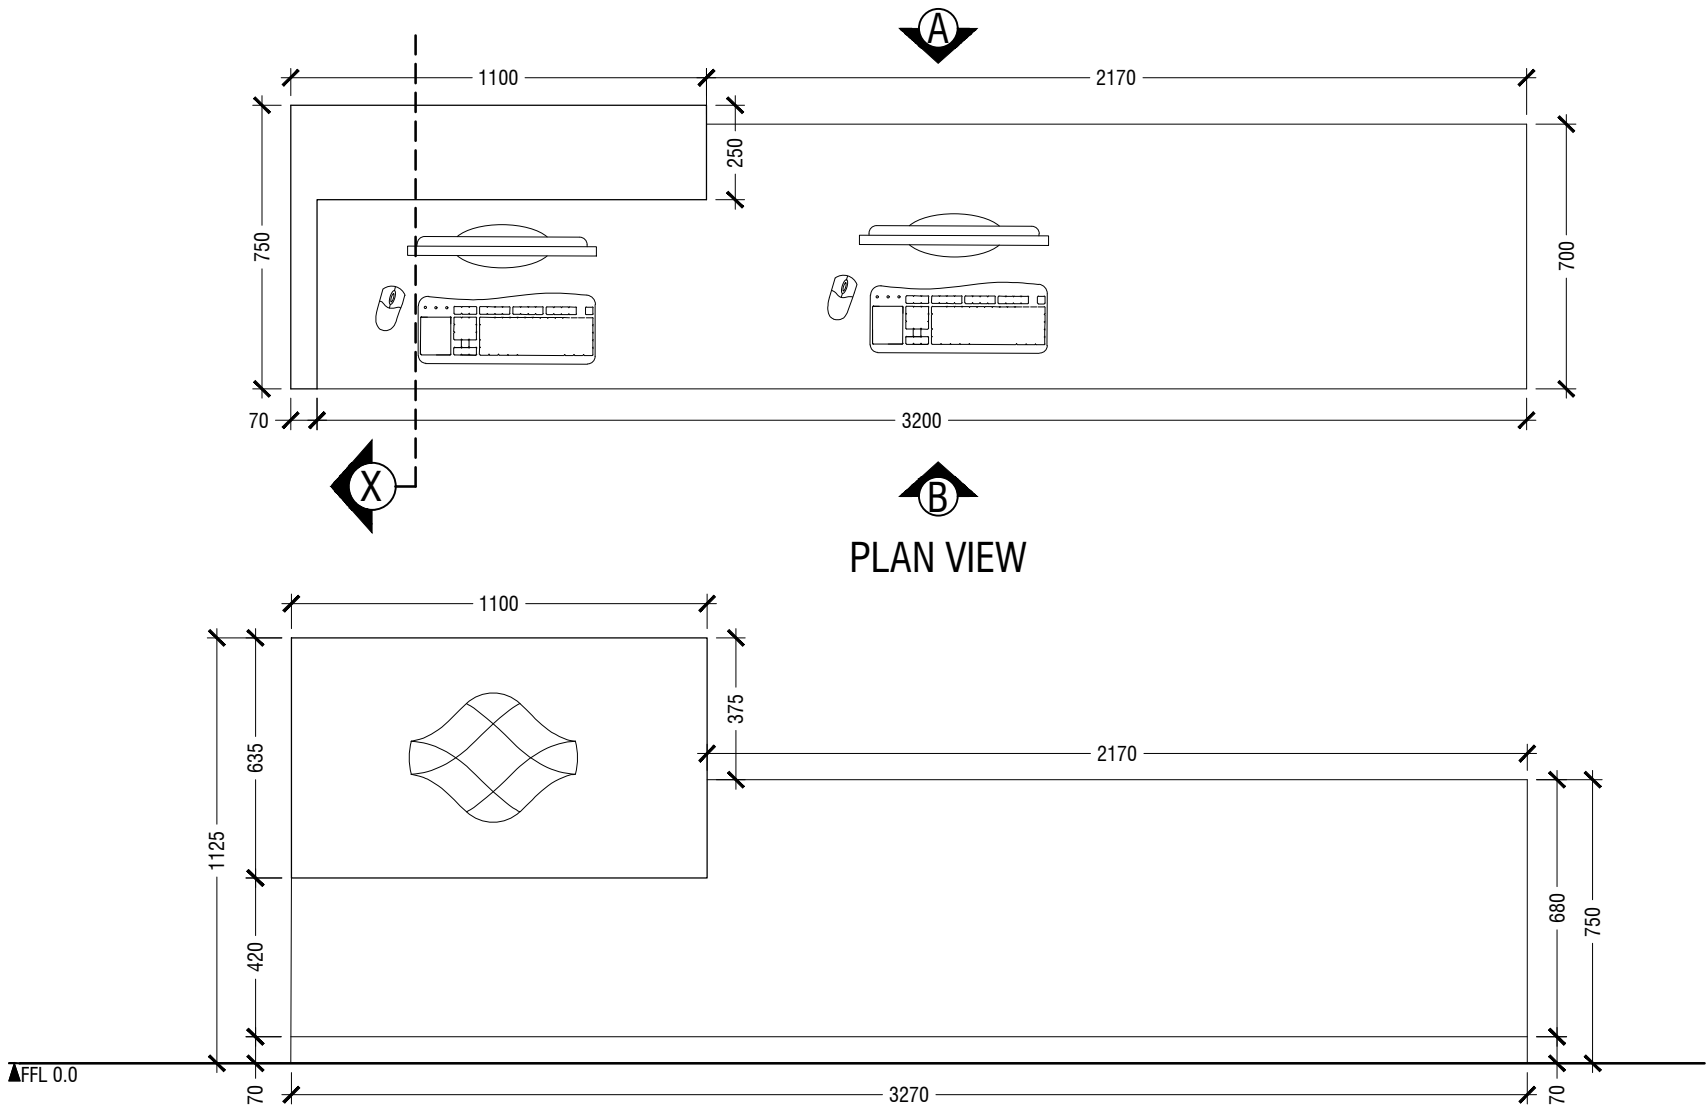

ELEVATION A

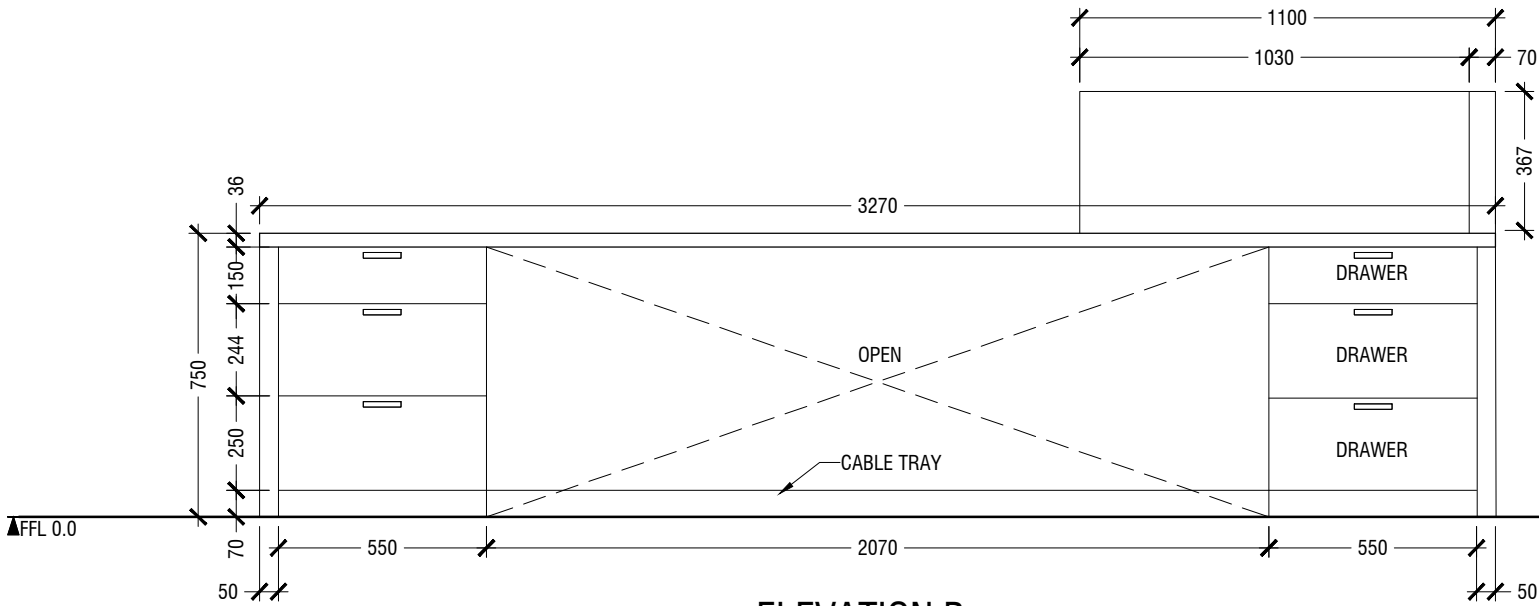

ELEVATION B

SECTION X

1.01 NURSE COUNTER
LOCATION "CARDIOLOGY WARD"
SCALE 1:20

MACO
DESIGNS
Contact: 7989966, 7691671
Email: info@maco.mv

CLIENT:
IGMH

PROJECT:
IGMH CATH LAB
K. MALE

SCALE: AS GIVEN

DRWNG TITLE : AS GIVN

DATE: D015M07Y26

REVISION NO.: 00

FILE NAME:
\\DLINK-031BBD\Volume_1\MACO
PROJECTS\2026

WARNING:

- This drawing shall not be used for construction unless certified.
- Contractor to verify all dimensions of existing works on site before commencing any work or preparing shop drawings.
- Do not scale drawings, use written dimensions only.
- This drawing is to be read in conjunction with the specifications and conditions of contract.
- This drawing and design is copyright and no portion may be reproduced without the permission of the MACO architects



ID03

NOTE

- CL = CEILING LINE
- DCL = DROP CEILING LINE
- FFL = FLOOR FINISH LINE

*FINAL DIMENSIONS ARE SUBJECT TO CHANGE DEPENDING ON CONTRACTORS ADJUSTMENTS ON SITE

*SLANTED WALL ALIGNMENT TO BE CONFIRMED ON SITE

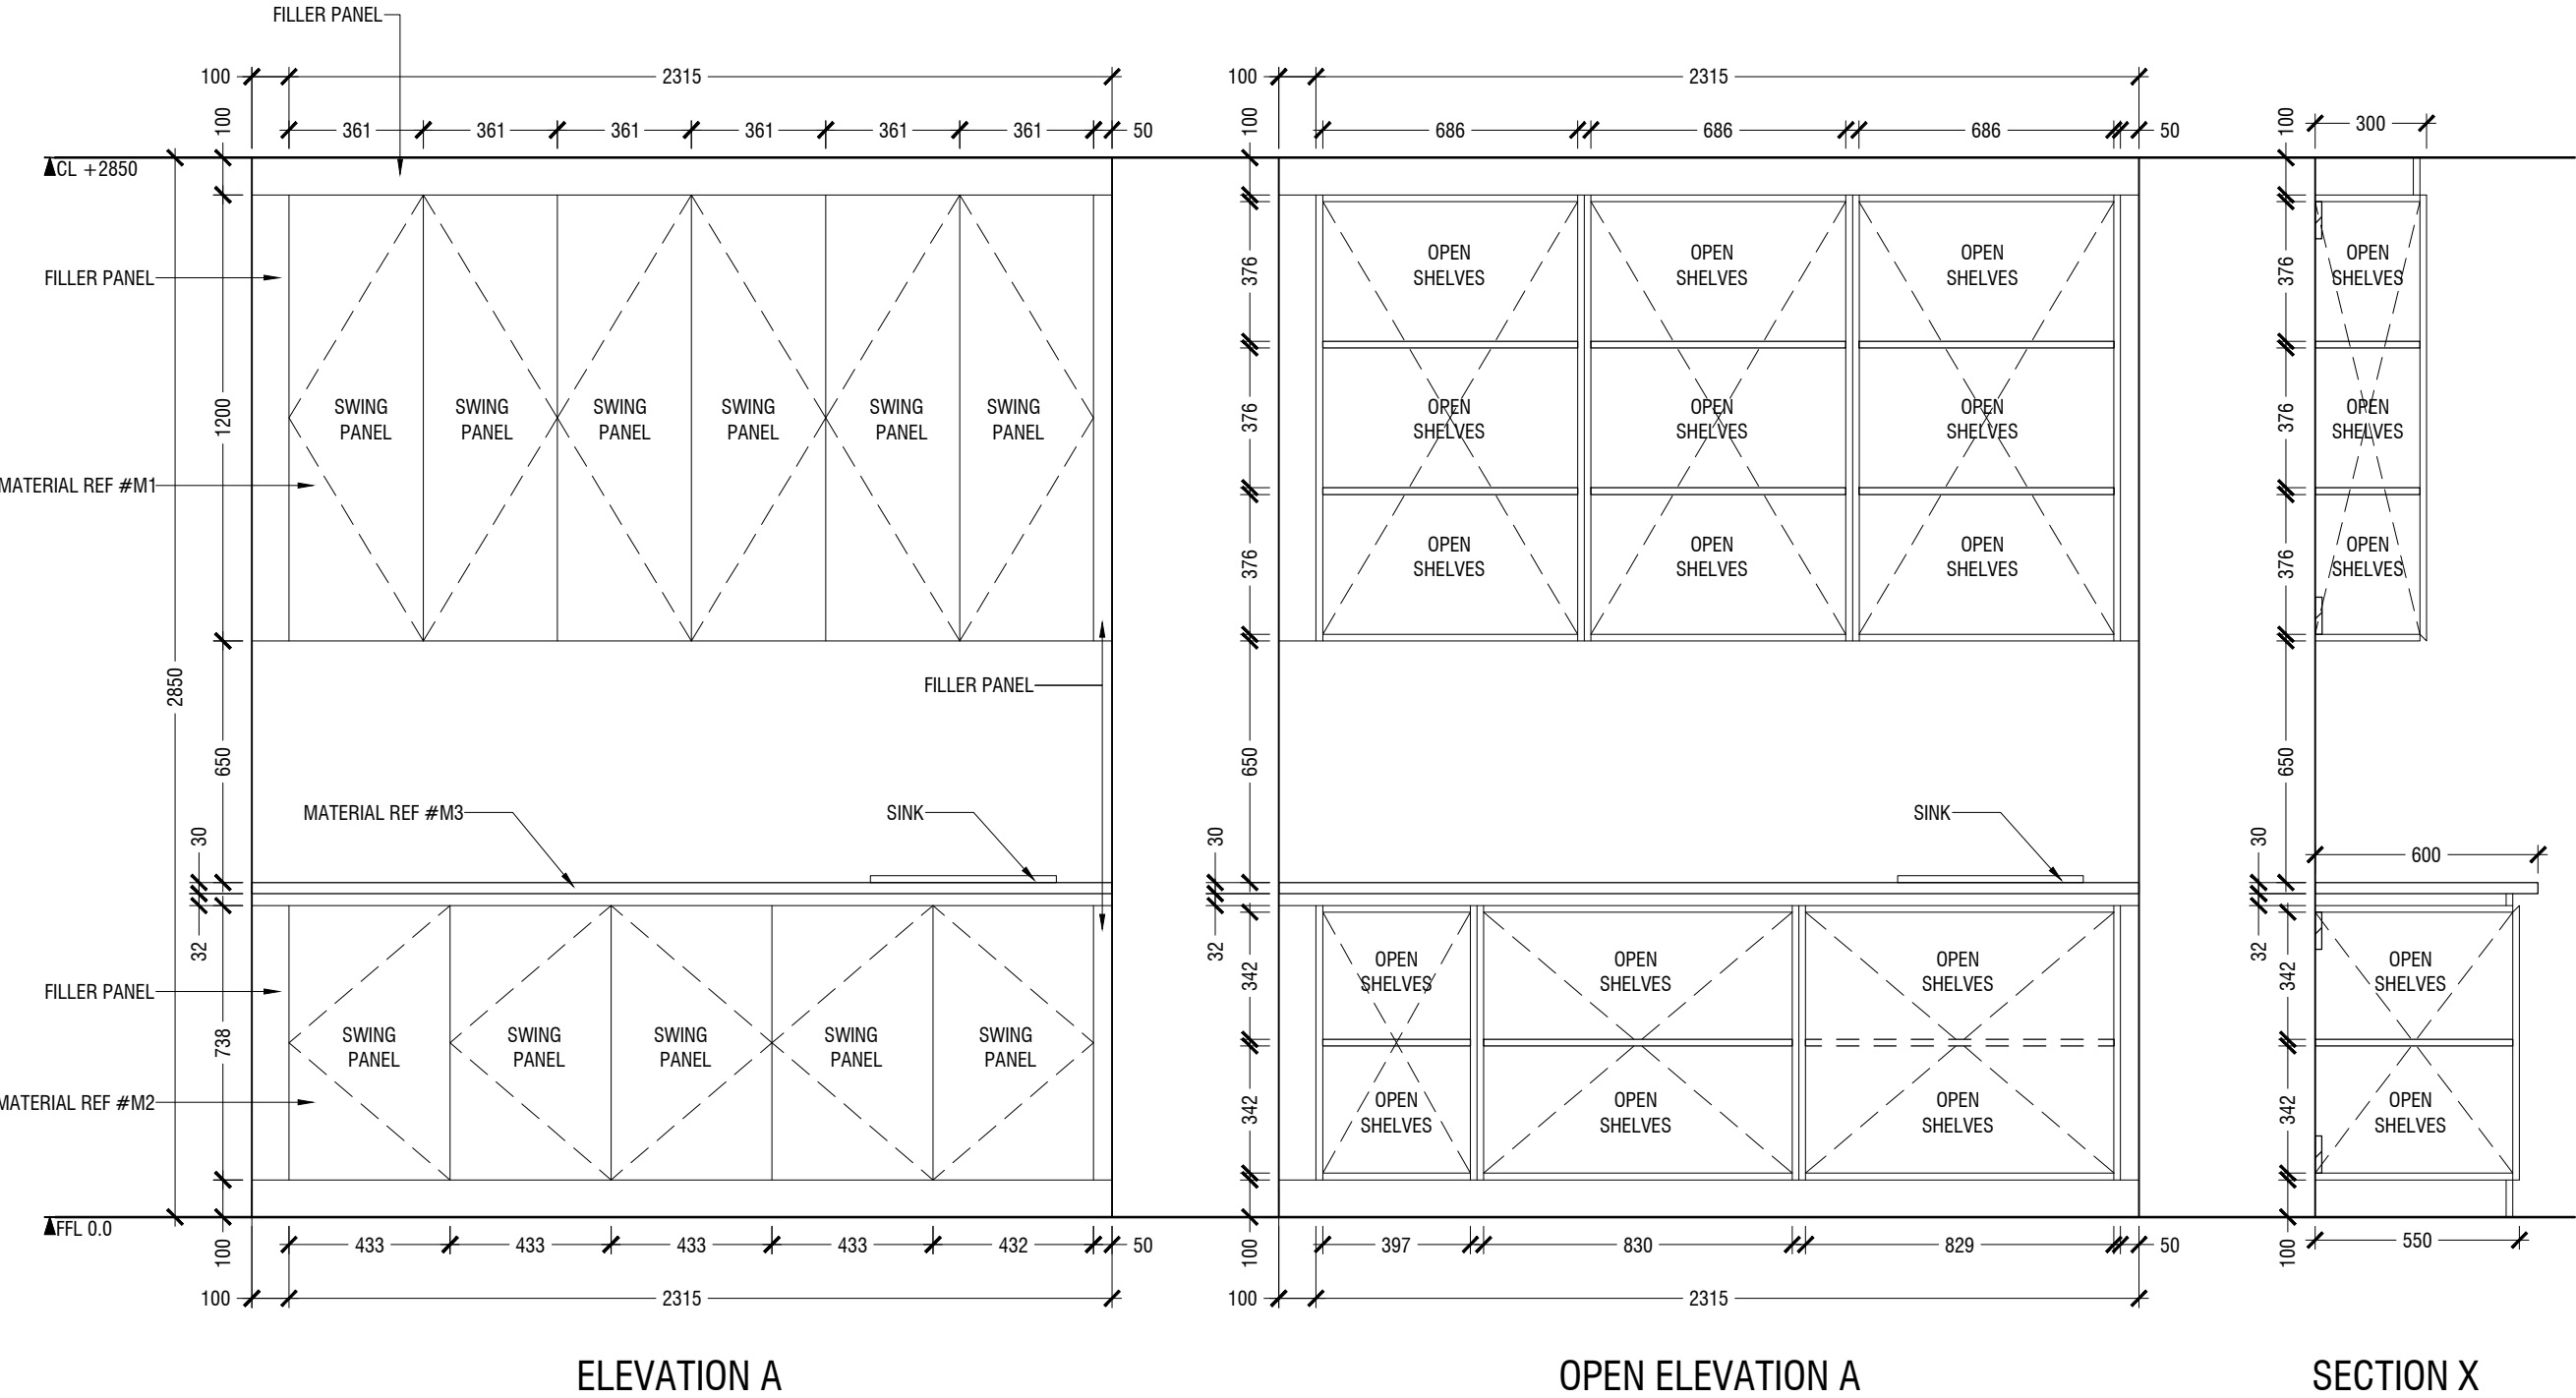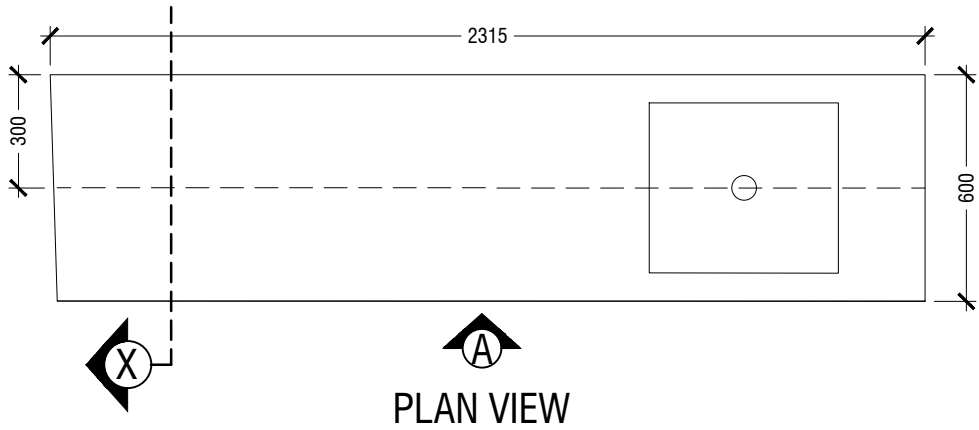

MACO
DESIGNS

Contact: 7989966, 7691671

Email: info@maco.mv

CLIENT:

IGMH

PROJECT:

IGMH CATH LAB

K. MALE

SCALE: AS GIVEN

DRWNG TITLE : AS GIVN

DATE: D015M07Y26

REVISION NO.: 00

FILE NAME:

\\DLINK-031BBD\Volume_1\MACO PROJECTS\2026

WARNING:

- This drawing shall not be used for construction unless certified.
- Contractor to verify all dimensions of existing works on site before commencing any work or preparing shop drawings.
- Do not scale drawings, use written dimensions only.
- This drawing is to be read in conjunction with the specifications and conditions of contract.
- This drawing and design is copyright and no portion may be reproduced without the permission of the MACO architects

ID04

- CL = CEILING LINE
- DCL = DROP CEILING LINE
- FFL = FLOOR FINISH LINE

*SLANTED WALL ALIGNMENT TO BE CONFIRMED ON SITE



- This drawing shall not be used for construction unless certified.
- Contractor to verify all dimensions of existing works on site before commencing any work or preparing shop drawings.
- Do not scale drawings, use written dimensions only.
- This drawing is to be read in conjunction with the specifications and conditions of contract.
- This drawing and design is copyright and no portion may be reproduced without the permission of the MACO architects


PATIENT BED HEAD BOARD
LOCATION "CARDIOLOGY WARD & C.C.U"
SCALE 1:20

ID05


- NOTE
- CL = CEILING LINE
 - DCL = DROP CEILING LINE
 - FFL = FLOOR FINISH LINE

*FINAL DIMENSIONS ARE SUBJECT TO CHANGE DEPENDING ON CONTRACTORS ADJUSTMENTS ON SITE

*SLANTED WALL ALIGNMENT TO BE CONFIRMED ON SITE

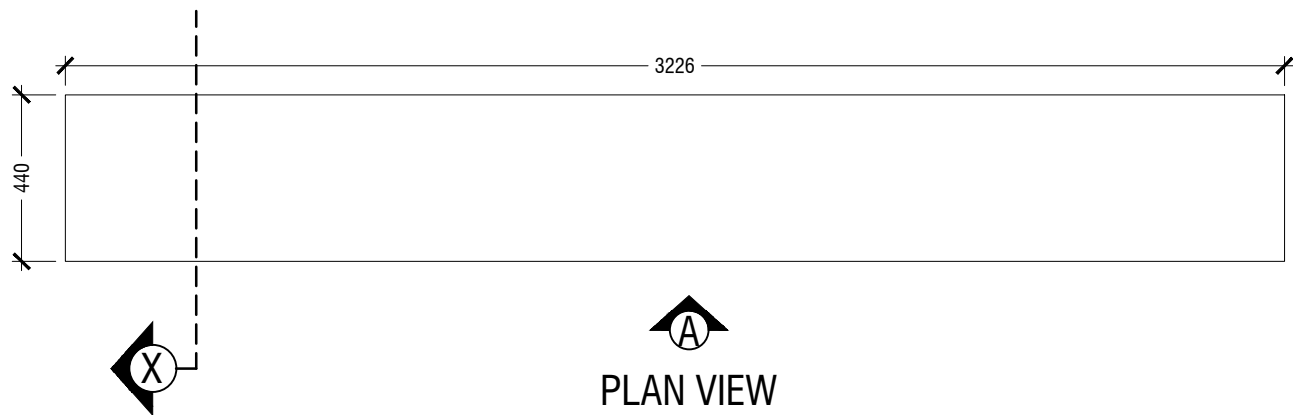

PLAN VIEW

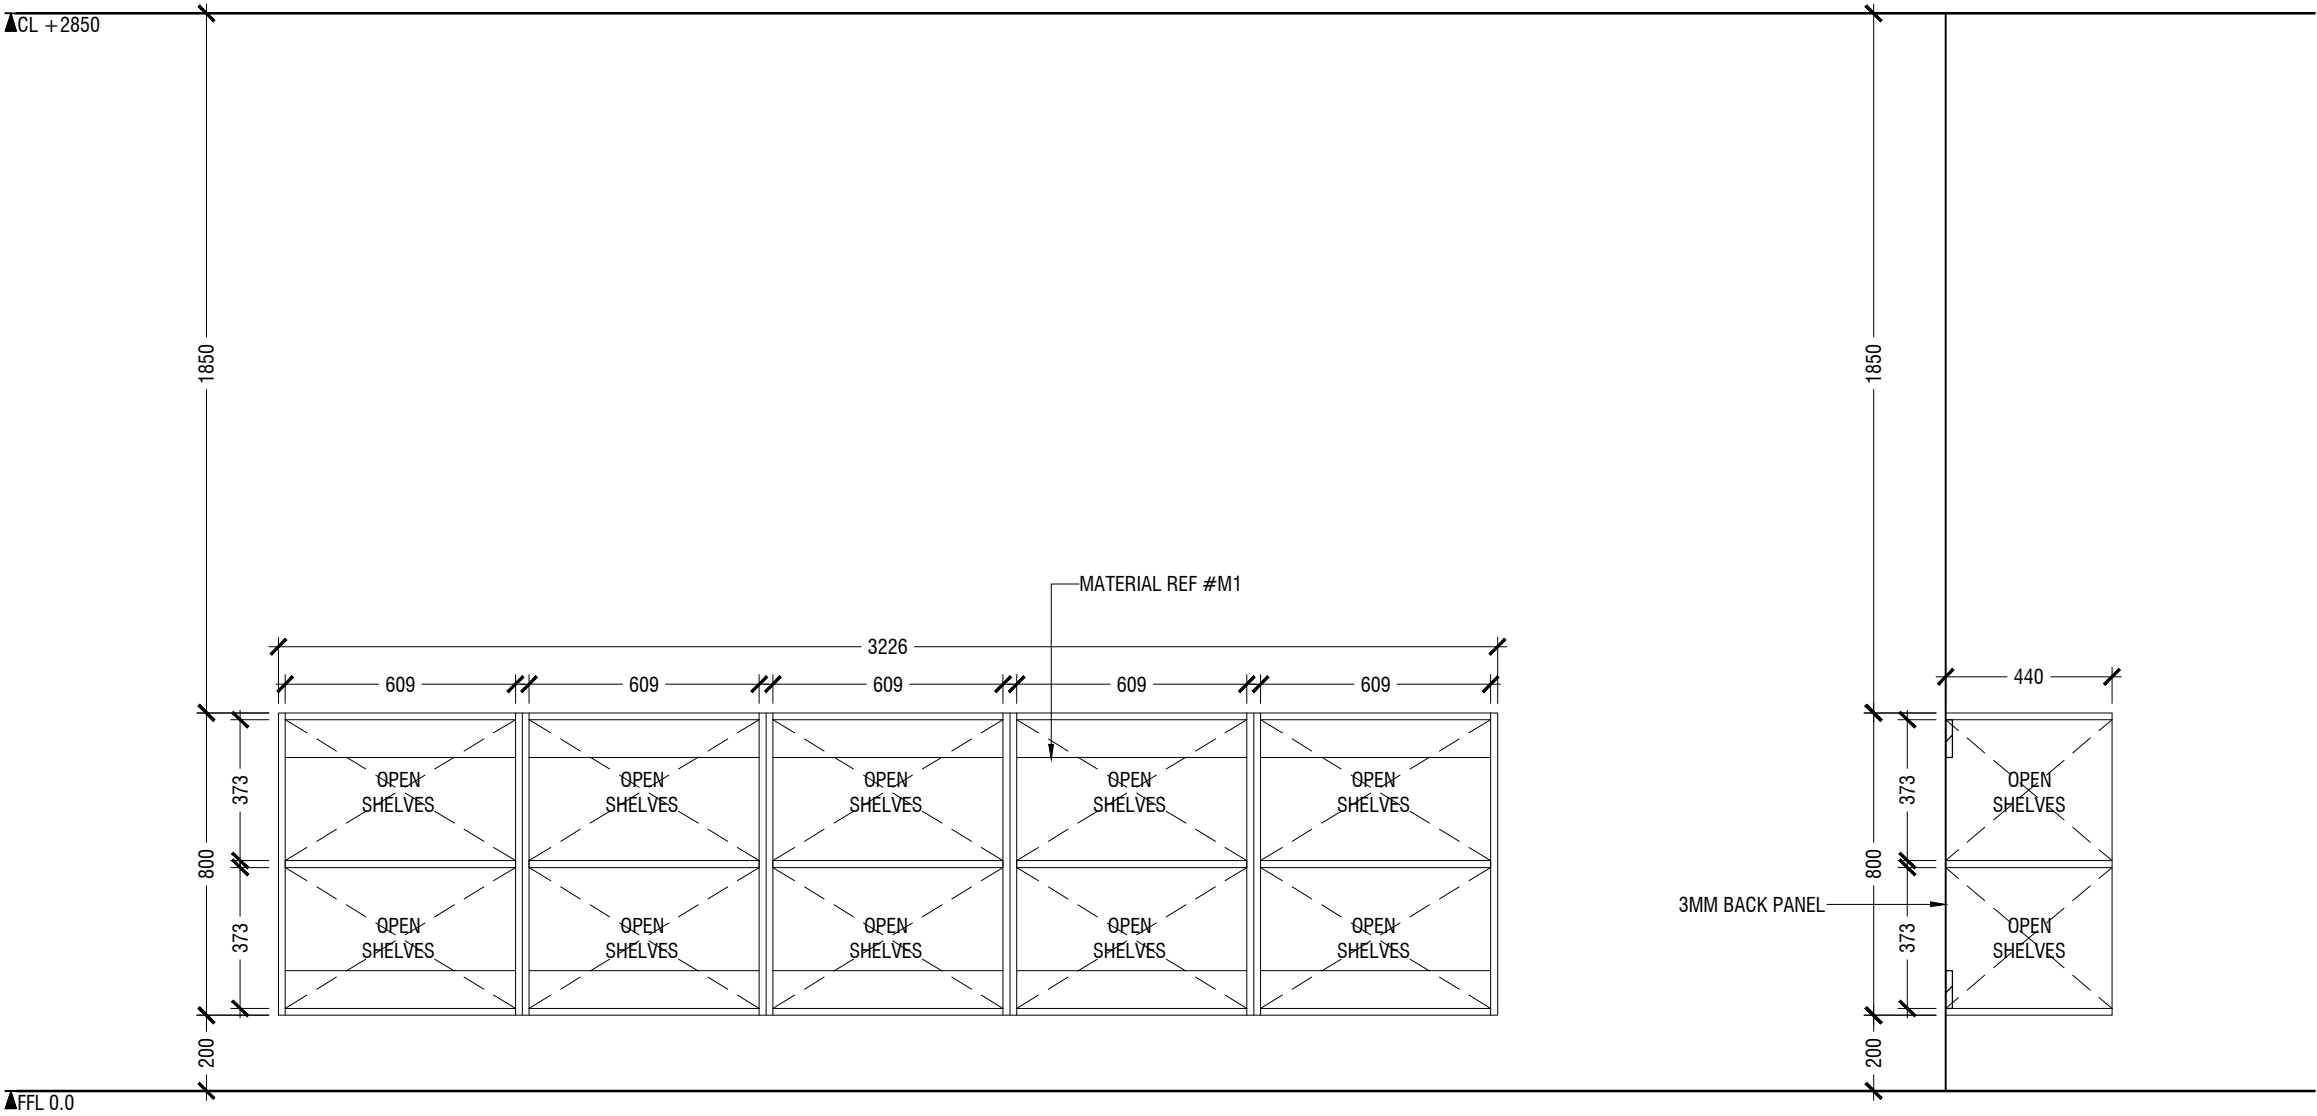

ELEVATION A

SECTION X

MACO
DESIGNS

Contact: 7989966, 7691671
Email: info@maco.mv

CLIENT:

IGMH

PROJECT:

IGMH CATH LAB
K. MALE

SCALE: AS GIVEN

DRWNG TITLE : AS GIVN

DATE: D015M07Y26

REVISION NO.: 00

FILE NAME:

\\DLINK-031BBD\Volume_1\MACO
PROJECTS\2026


WARNING:

- This drawing shall not be used for construction unless certified.
- Contractor to verify all dimensions of existing works on site before commencing any work or preparing shop drawings.
- Do not scale drawings, use written dimensions only.
- This drawing is to be read in conjunction with the specifications and conditions of contract.
- This drawing and design is copyright and no portion may be reproduced without the permission of the MACO architects

1.04 RECEPTION BACK WALL
LOCATION "C.C.U"
SCALE 1:20


ID06

- NOTE
- CL = CEILING LINE
 - DCL = DROP CEILING LINE
 - FFL = FLOOR FINISH LINE

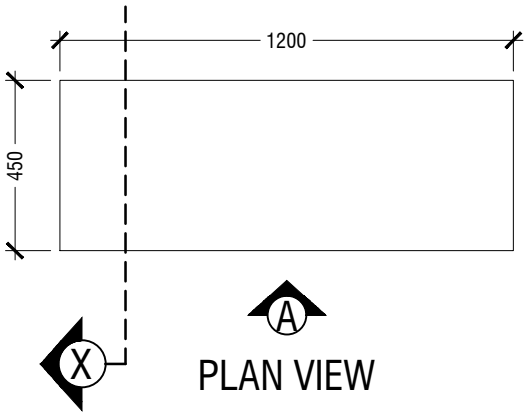

*FINAL DIMENSIONS ARE SUBJECT TO CHANGE DEPENDING ON CONTRACTORS ADJUSTMENTS ON SITE

*SLANTED WALL ALIGNMENT TO BE CONFIRMED ON SITE

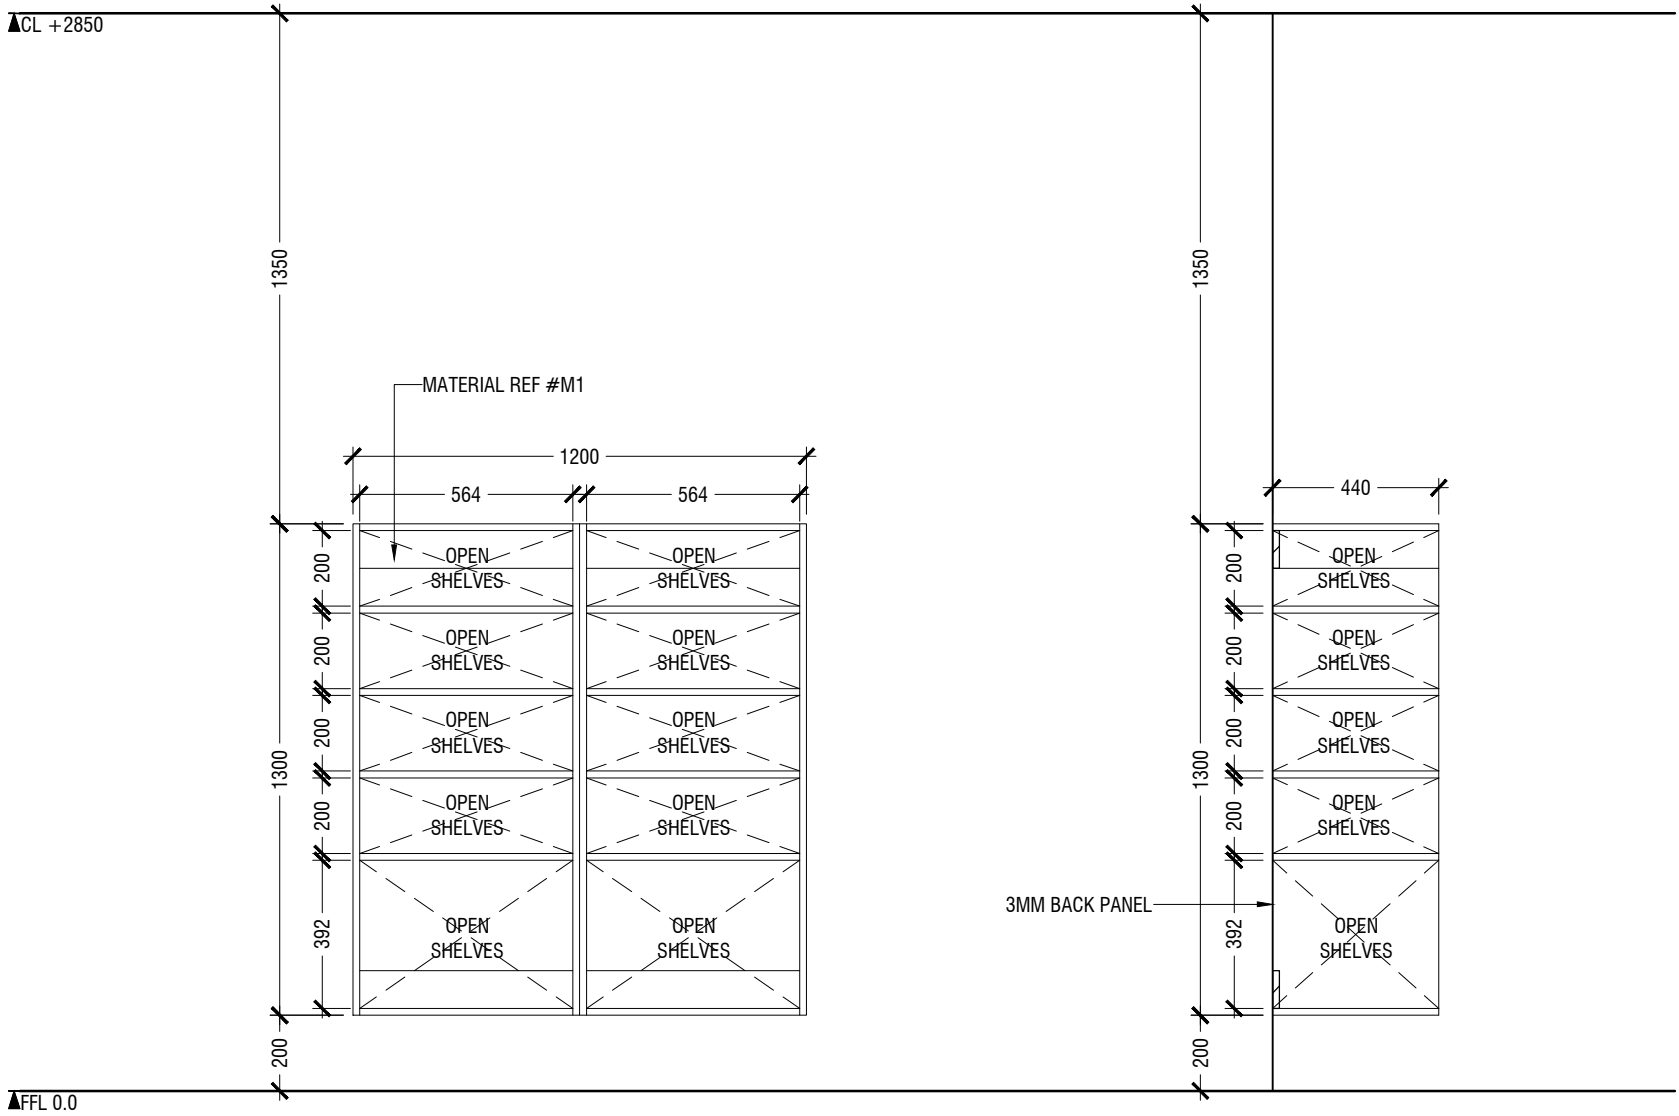

ELEVATION A

SECTION X

MACO
DESIGNS

Contact: 7989966, 7691671

Email: info@maco.mv

CLIENT:

IGMH

PROJECT:

IGMH CATH LAB

K. MALE

SCALE: AS GIVEN

DRWNG TITLE : AS GIVN

DATE: D015M07Y26

REVISION NO.: 00

FILE NAME:

\\DLINK-031BBD\Volume_1\MACO
PROJECTS\2026

WARNING:

- This drawing shall not be used for construction unless certified.
- Contractor to verify all dimensions of existing works on site before commencing any work or preparing shop drawings.
- Do not scale drawings, use written dimensions only.
- This drawing is to be read in conjunction with the specifications and conditions of contract.
- This drawing and design is copyright and no portion may be reproduced without the permission of the MACO architects


1.05 WALL MOUNTED CABINET
LOCATION "C.C.U"
SCALE 1:20

ID07

- NOTE
- CL = CEILING LINE
 - DCL = DROP CEILING LINE
 - FFL = FLOOR FINISH LINE

*FINAL DIMENSIONS ARE SUBJECT TO CHANGE DEPENDING ON CONTRACTORS ADJUSTMENTS ON SITE

*SLANTED WALL ALIGNMENT TO BE CONFIRMED ON SITE

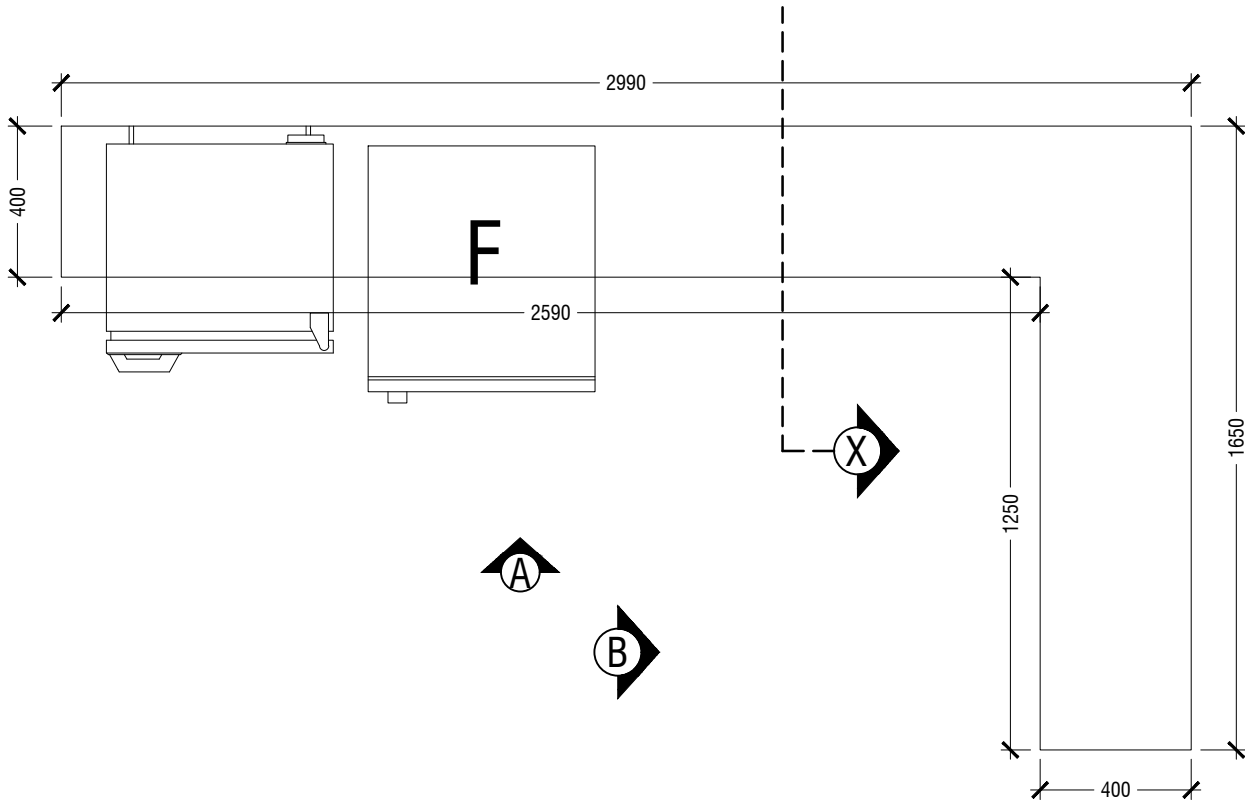

PLAN VIEW

1.06 STORAGE CABINET
LOCATION "C.C.U"
SCALE 1:20

MACO

DESIGNS

Contact: 7989966, 7691671
Email: info@maco.mv

CLIENT:
IGMH

PROJECT:
IGMH CATH LAB
K. MALE

SCALE: AS GIVEN

DRWNG TITLE : AS GIVN

DATE: D015M07Y26

REVISION NO.: 00

FILE NAME:
\\DLINK-031BBD\Volume_1\MACO
PROJECTS\2026

WARNING:


- This drawing shall not be used for construction unless certified.
- Contractor to verify all dimensions of existing works on site before commencing any work or preparing shop drawings.
- Do not scale drawings, use written dimensions only.
- This drawing is to be read in conjunction with the specifications and conditions of contract.
- This drawing and design is copyright and no portion may be reproduced without the permission of the MACO architects

ID08

- NOTE
- CL = CEILING LINE
 - DCL = DROP CEILING LINE
 - FFL = FLOOR FINISH LINE

*FINAL DIMENSIONS ARE SUBJECT TO CHANGE DEPENDING ON CONTRACTORS ADJUSTMENTS ON SITE

*SLANTED WALL ALIGNMENT TO BE CONFIRMED ON SITE

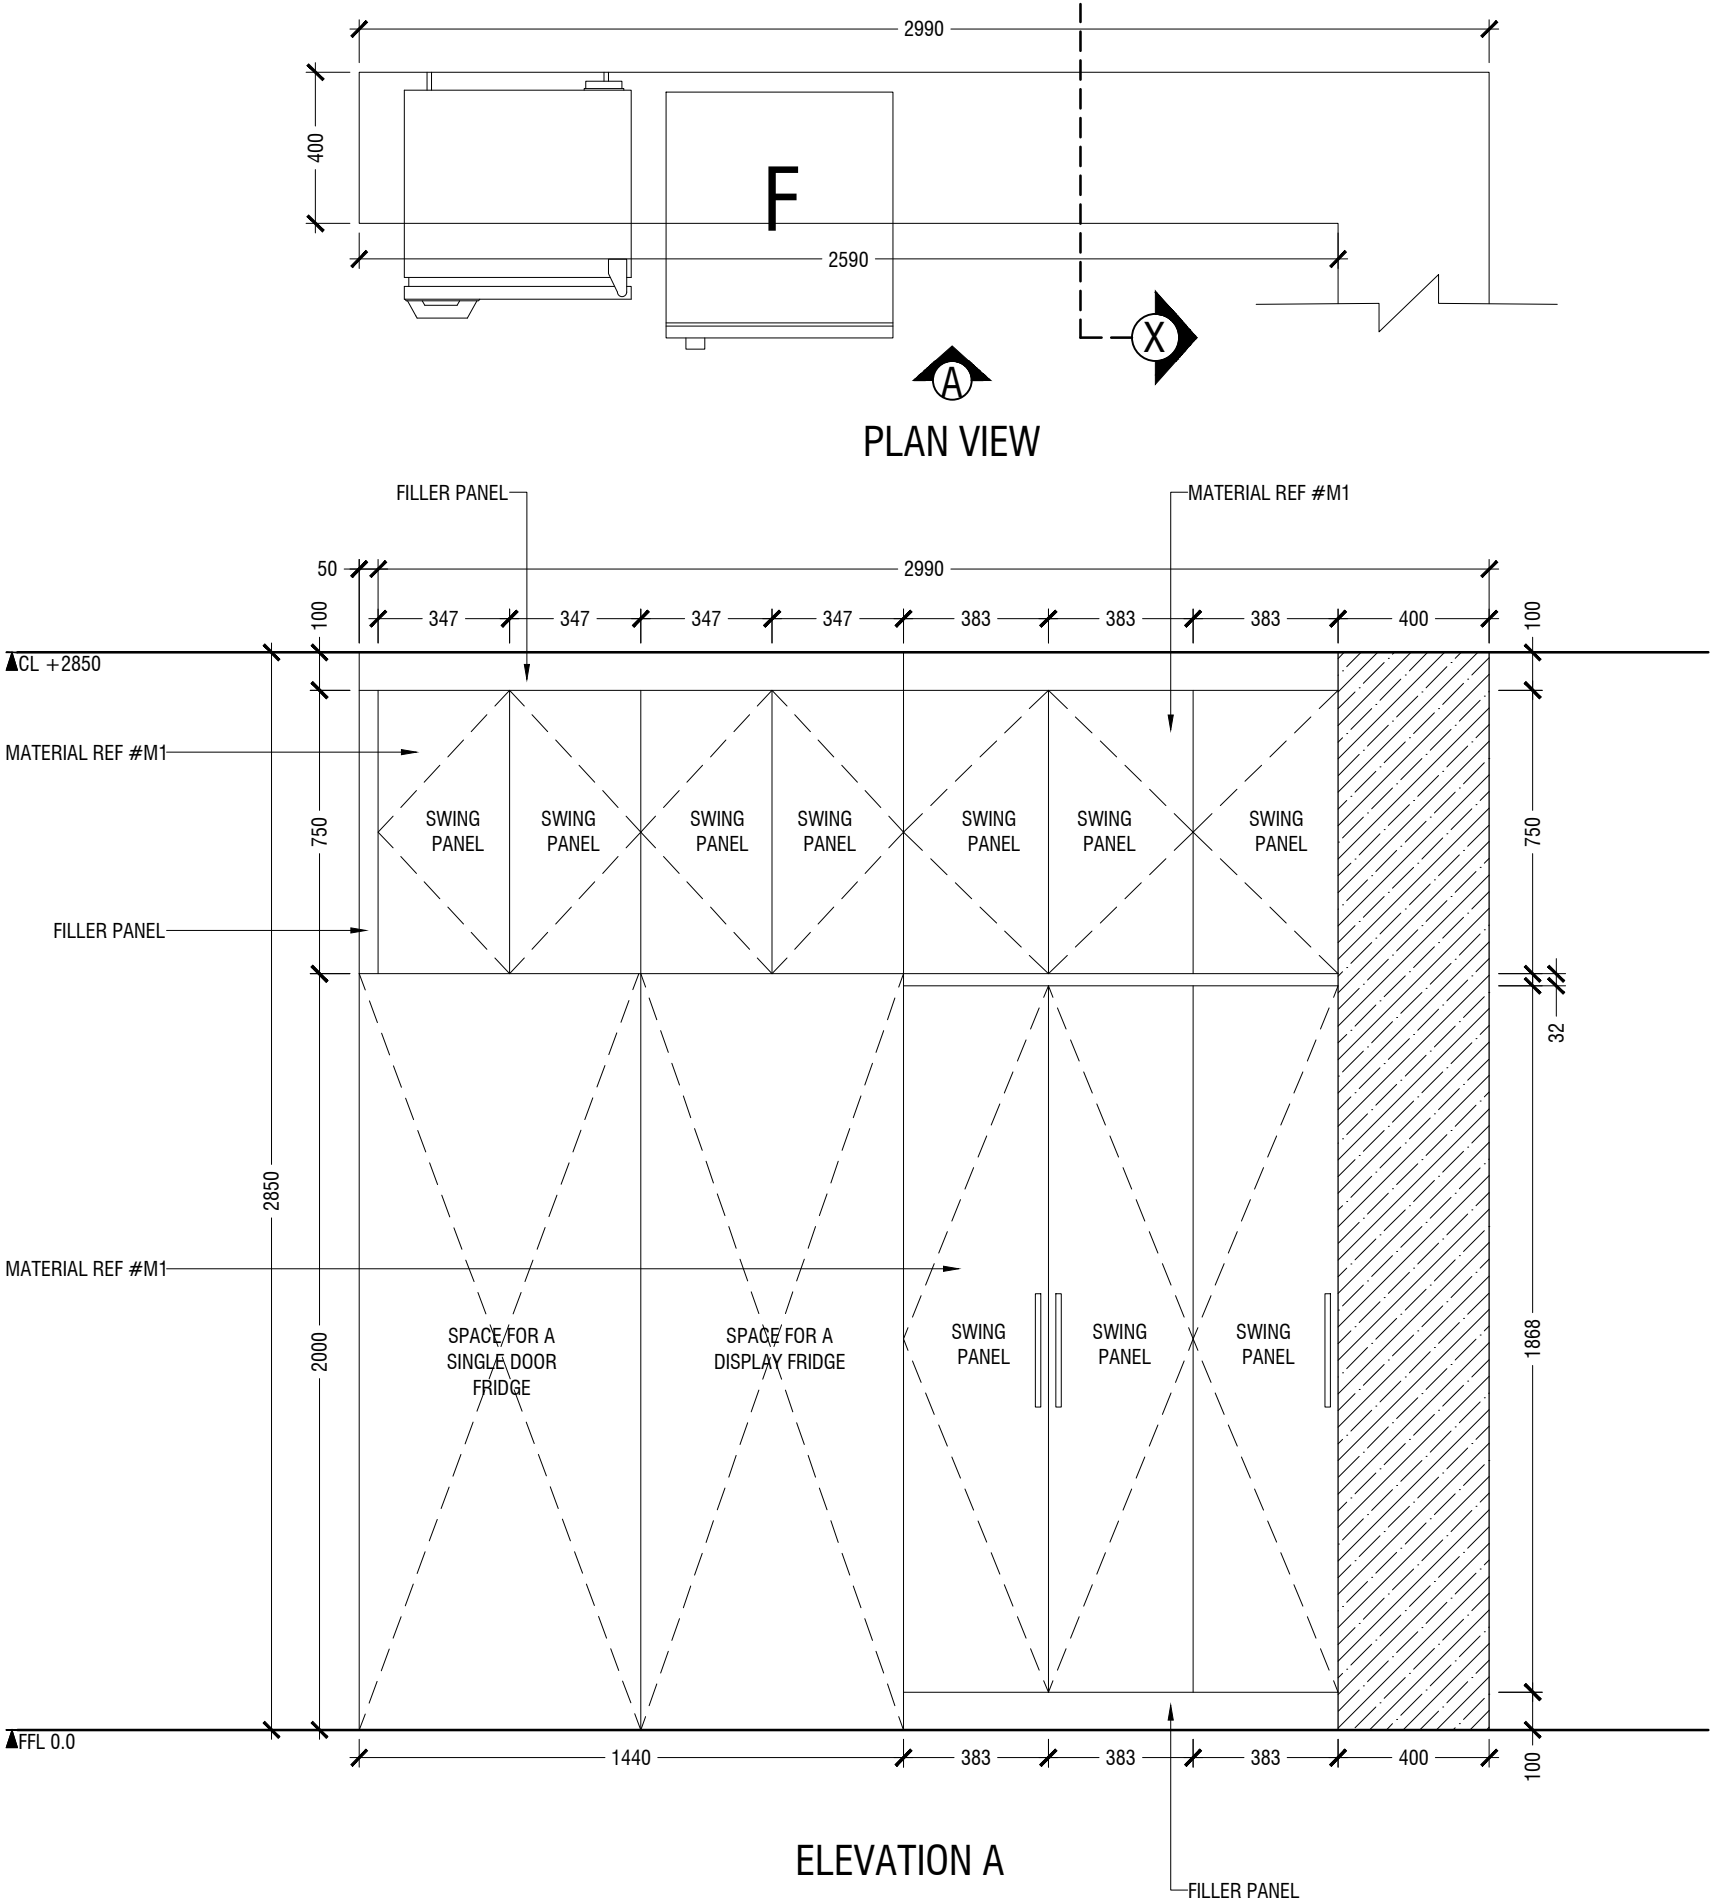

MACO
DESIGNS
Contact: 7989966, 7691671
Email: info@maco.mv

CLIENT:
IGMH

PROJECT:
IGMH CATH LAB
K. MALE

SCALE: AS GIVEN

DRWNG TITLE : AS GIVN

DATE: D015M07Y26

REVISION NO.: 00

FILE NAME:
\\DLINK-031BBD\Volume_1\MACO
PROJECTS\2026

WARNING:
- This drawing shall not be used for construction unless certified.
- Contractor to verify all dimensions of existing works on site before commencing any work or preparing shop drawings.
- Do not scale drawings, use written dimensions only.
- This drawing is to be read in conjunction with the specifications and conditions of contract.
- This drawing and design is copyright and no portion may be reproduced without the permission of the MACO architects



ID09

1.06 STORAGE CABINET
LOCATION "C.C.U"
SCALE 1:20

- NOTE
- CL = CEILING LINE
 - DCL = DROP CEILING LINE
 - FFL = FLOOR FINISH LINE

*FINAL DIMENSIONS ARE SUBJECT TO CHANGE DEPENDING ON CONTRACTORS ADJUSTMENTS ON SITE

*SLANTED WALL ALIGNMENT TO BE CONFIRMED ON SITE

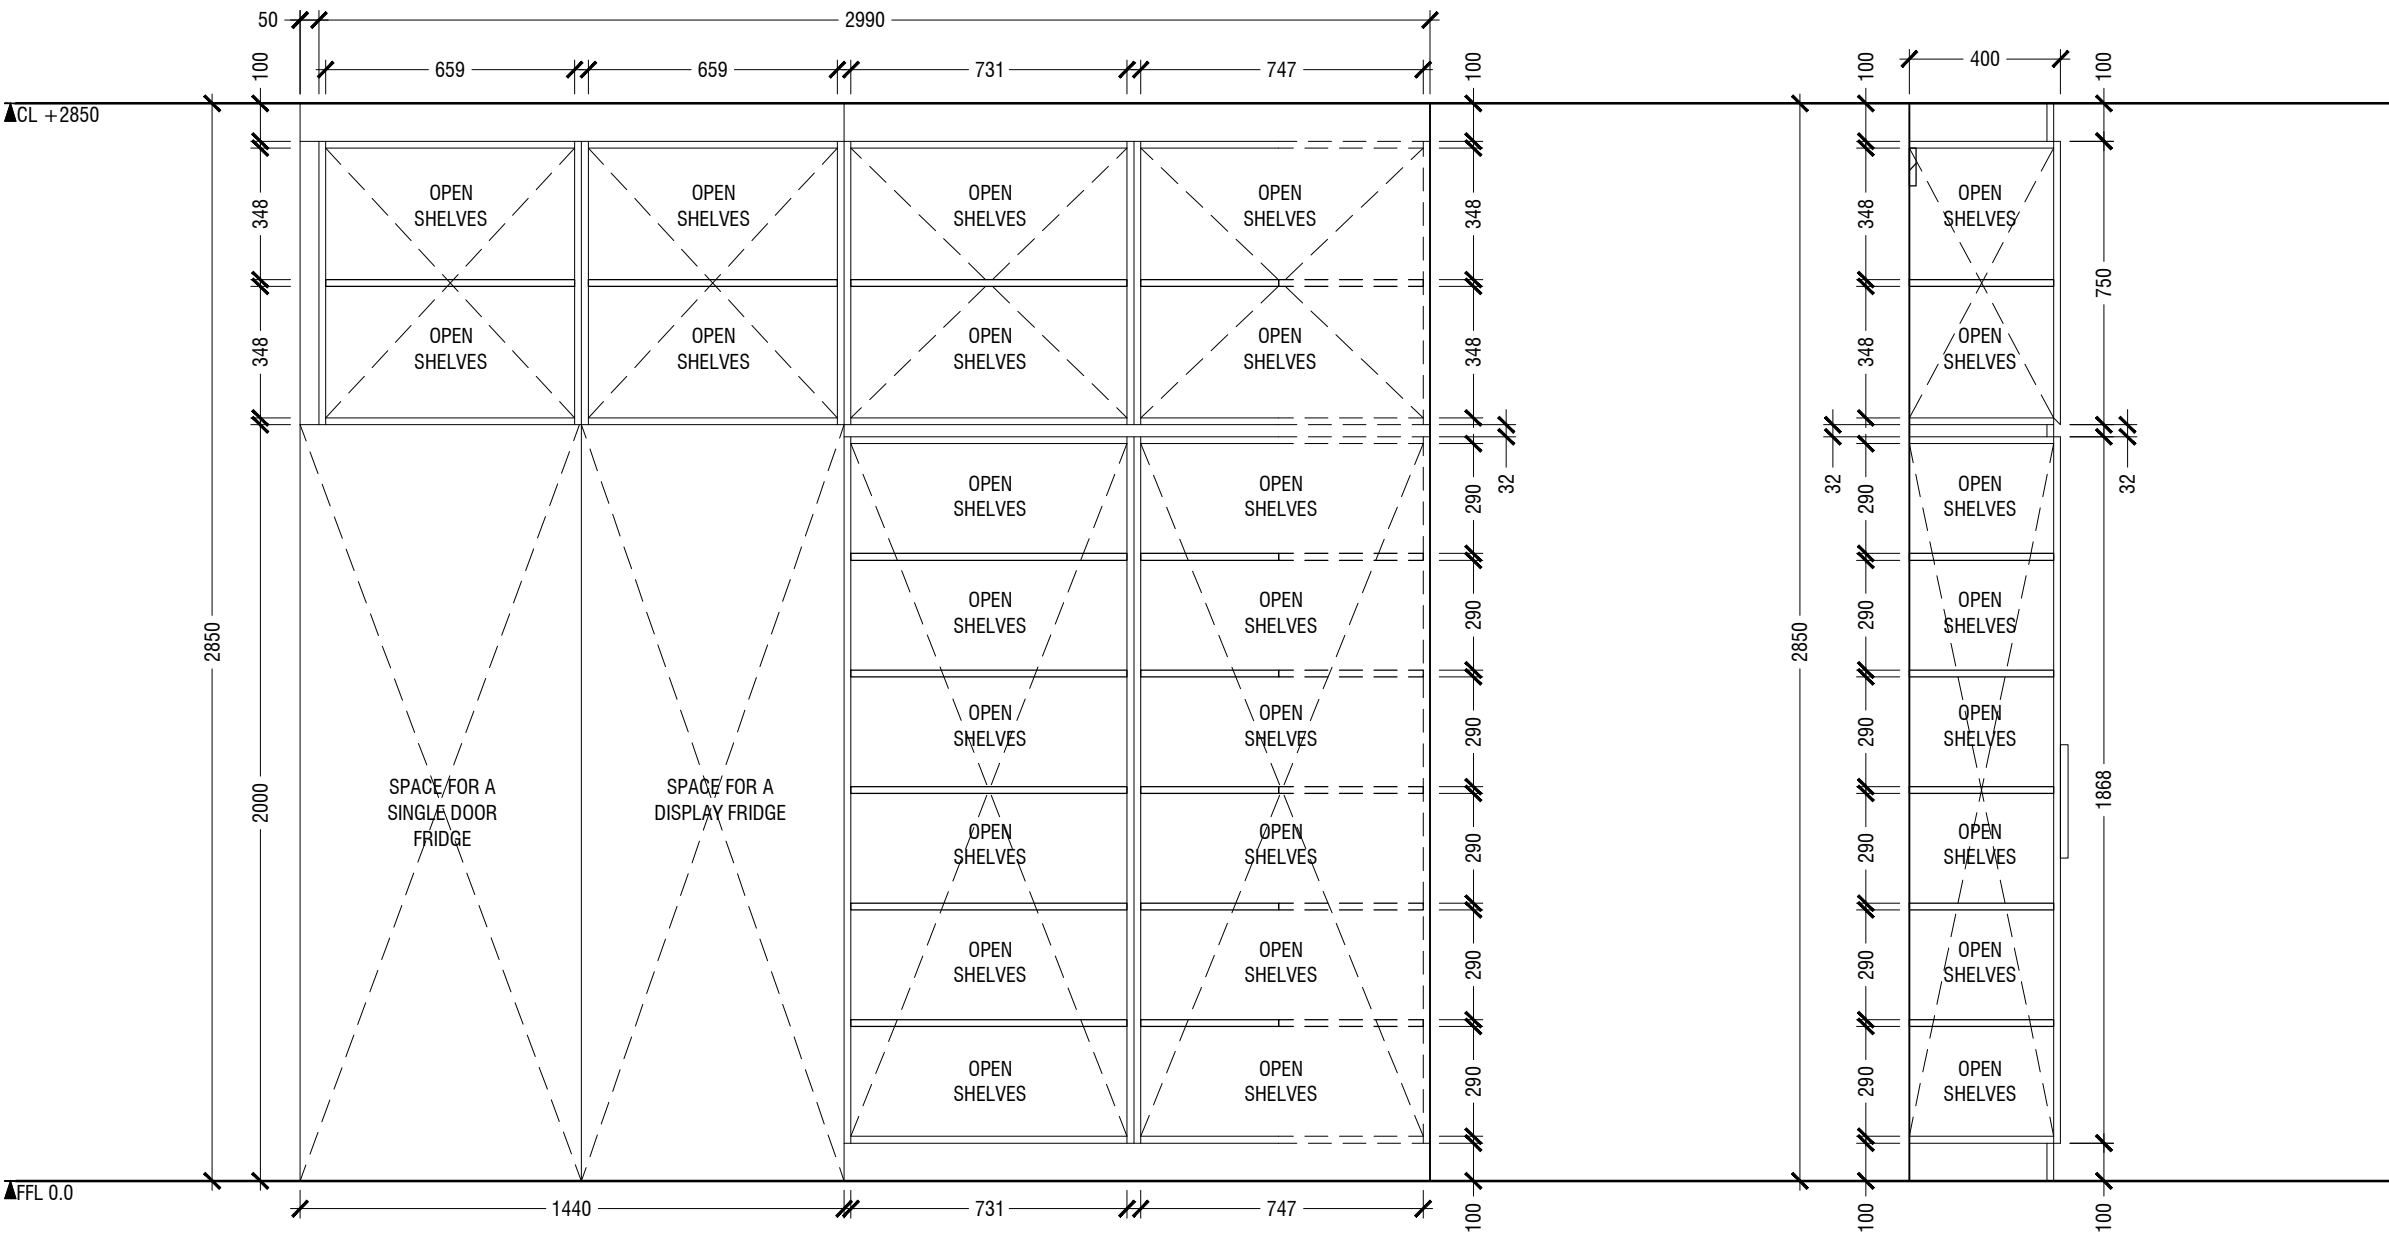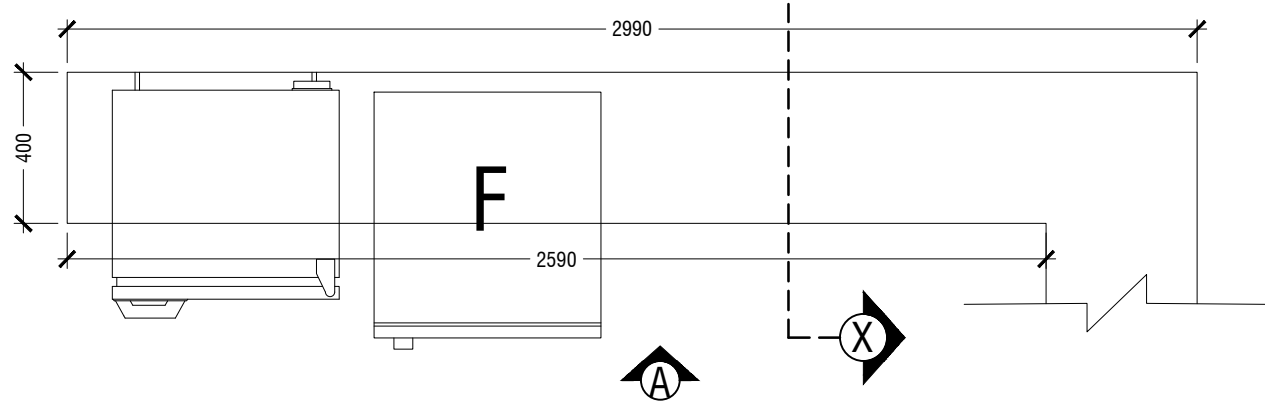

MACO
DESIGNS

Contact: 7989966, 7691671

Email: info@maco.mv

CLIENT:

IGMH

PROJECT:

IGMH CATH LAB

K. MALE

SCALE: AS GIVEN

DRWNG TITLE : AS GIVN

DATE: D015M07Y26

REVISION NO.: 00

FILE NAME:

\\DLINK-031BBD\Volume_1\MACO
PROJECTS\2026

WARNING:

- This drawing shall not be used for construction unless certified.
- Contractor to verify all dimensions of existing works on site before commencing any work or preparing shop drawings.
- Do not scale drawings, use written dimensions only.
- This drawing is to be read in conjunction with the specifications and conditions of contract.
- This drawing and design is copyright and no portion may be reproduced without the permission of the MACO architects



1.06 STORAGE CABINET
LOCATION "C.C.U"
SCALE 1:20

ID10

- NOTE
- CL = CEILING LINE
 - DCL = DROP CEILING LINE
 - FFL = FLOOR FINISH LINE

*FINAL DIMENSIONS ARE SUBJECT TO CHANGE DEPENDING ON CONTRACTORS ADJUSTMENTS ON SITE

*SLANTED WALL ALIGNMENT TO BE CONFIRMED ON SITE

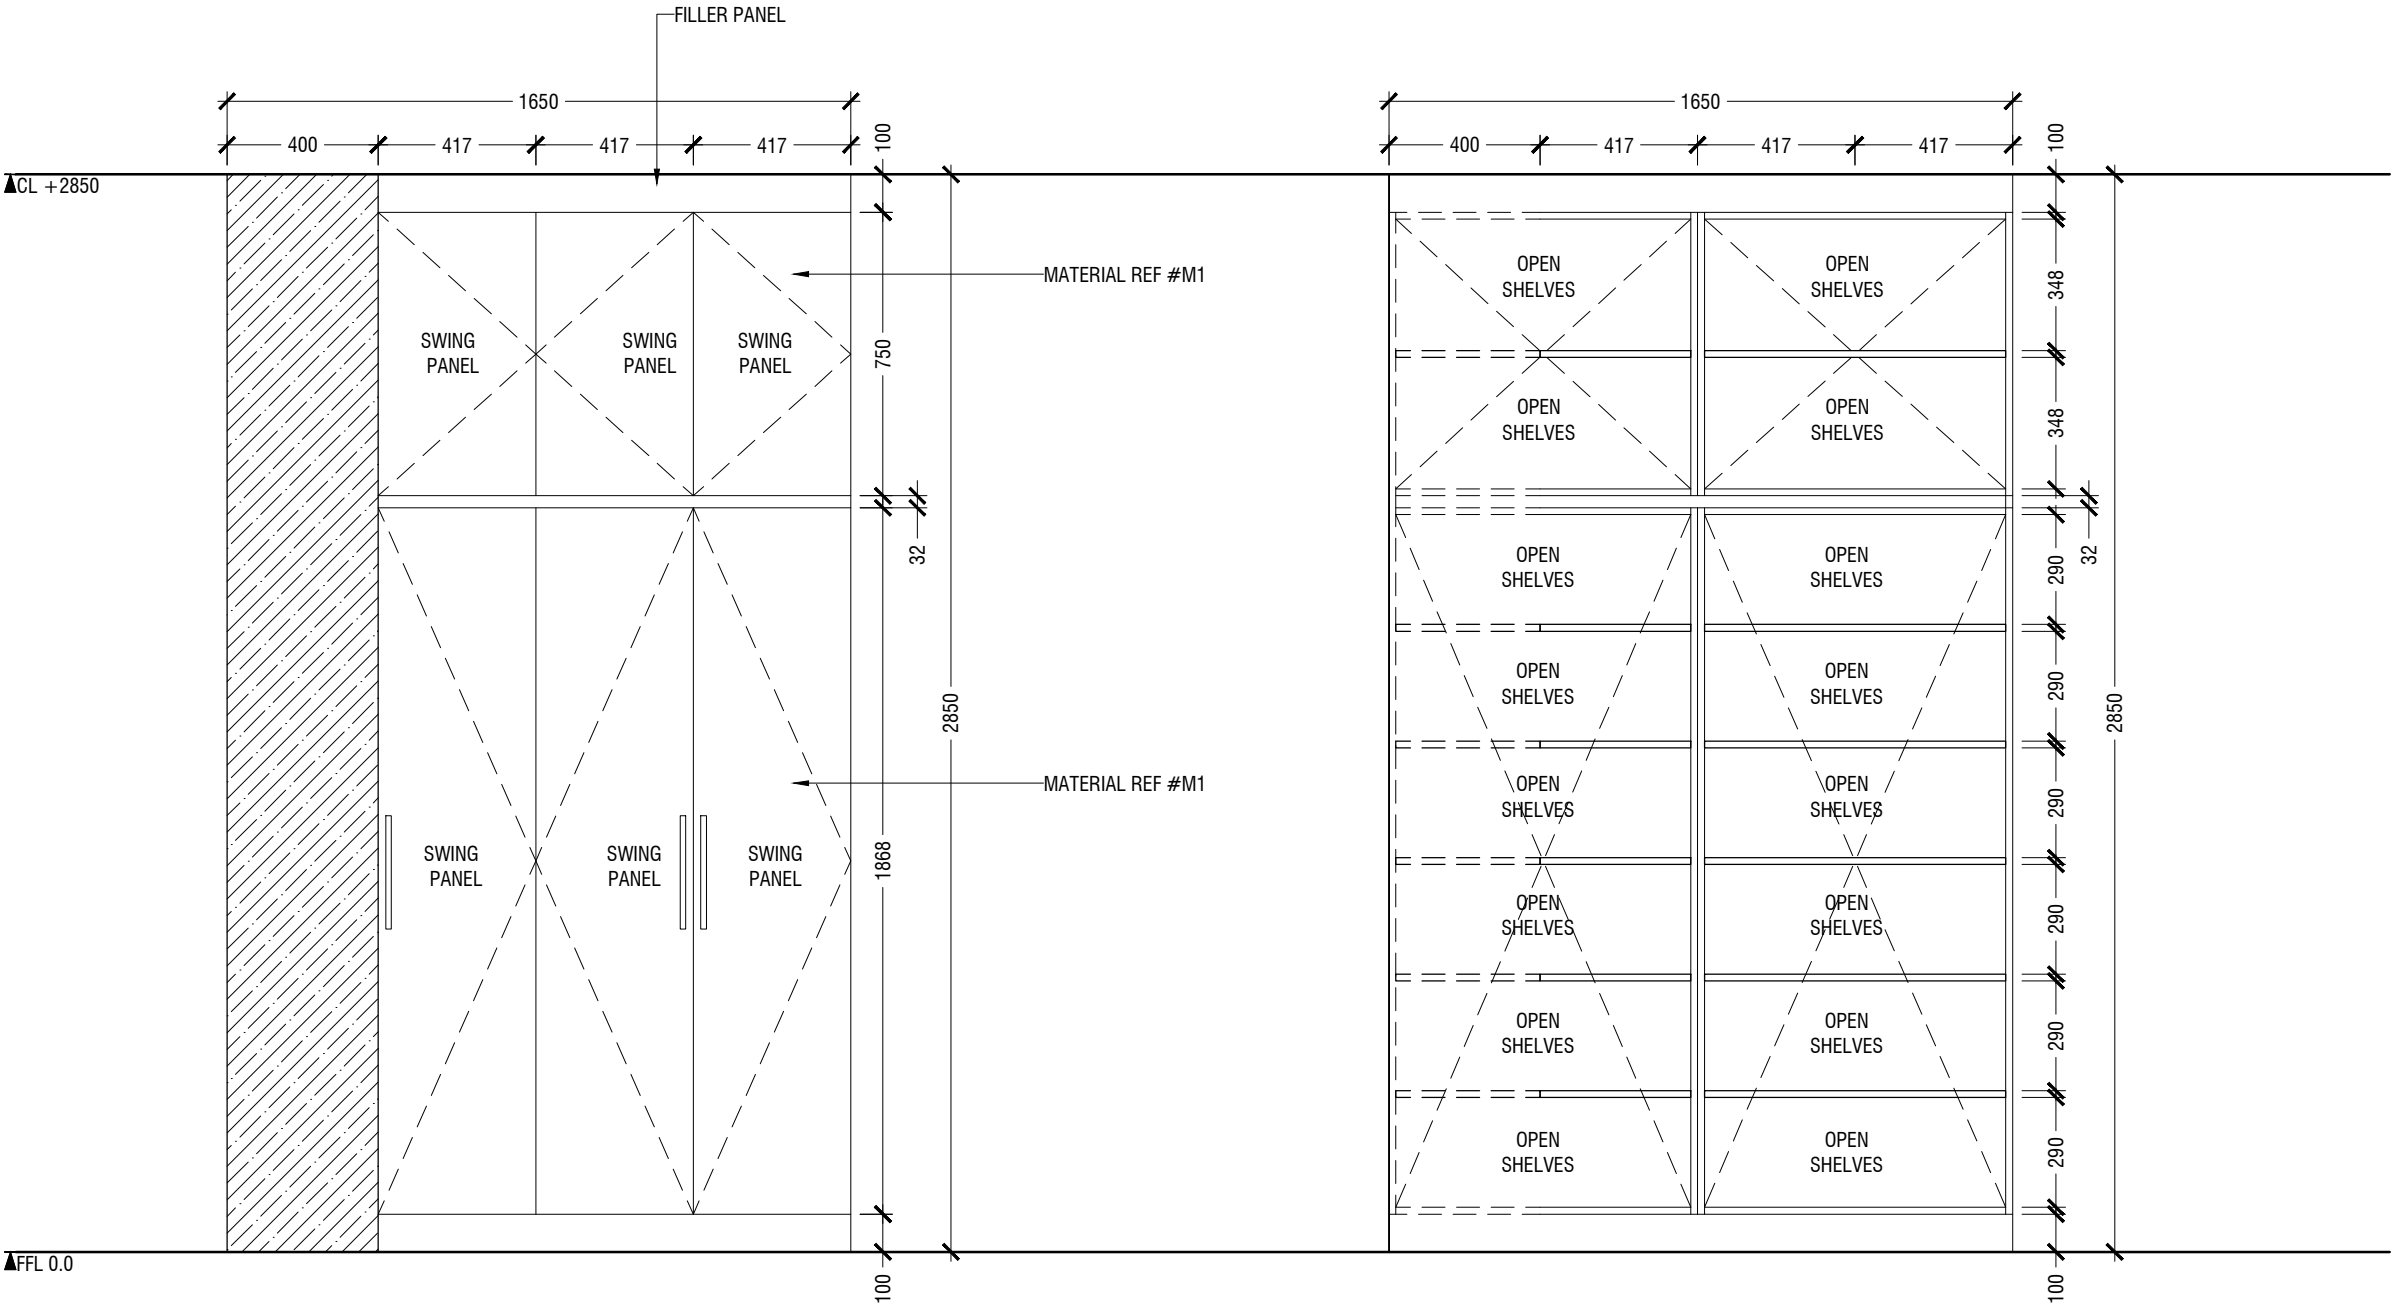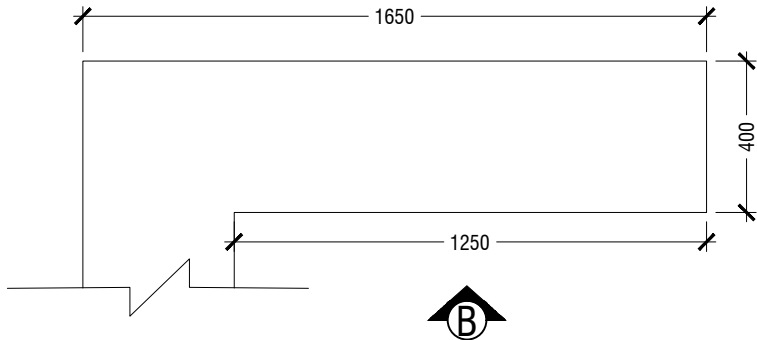

MACO
DESIGNS
Contact: 7989966, 7691671
Email: info@maco.mv

CLIENT:
IGMH

PROJECT:
IGMH CATH LAB
K. MALE

SCALE: AS GIVEN

DRWNG TITLE : AS GIVN


DATE: D015M07Y26

REVISION NO.: 00

FILE NAME:
\\DLINK-031BBD\Volume_1\MACO PROJECTS\2026


WARNING:
- This drawing shall not be used for construction unless certified.
- Contractor to verify all dimensions of existing works on site before commencing any work or preparing shop drawings.
- Do not scale drawings, use written dimensions only.
- This drawing is to be read in conjunction with the specifications and conditions of contract.
- This drawing and design is copyright and no portion may be reproduced without the permission of the MACO architects

- NOTE
- CL = CEILING LINE
 - DCL = DROP CEILING LINE
 - FFL = FLOOR FINISH LINE

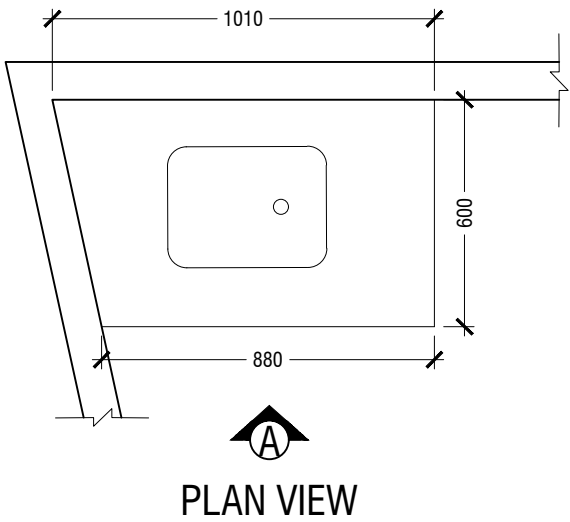

*FINAL DIMENSIONS ARE SUBJECT TO CHANGE DEPENDING ON CONTRACTORS ADJUSTMENTS ON SITE

*SLANTED WALL ALIGNMENT TO BE CONFIRMED ON SITE

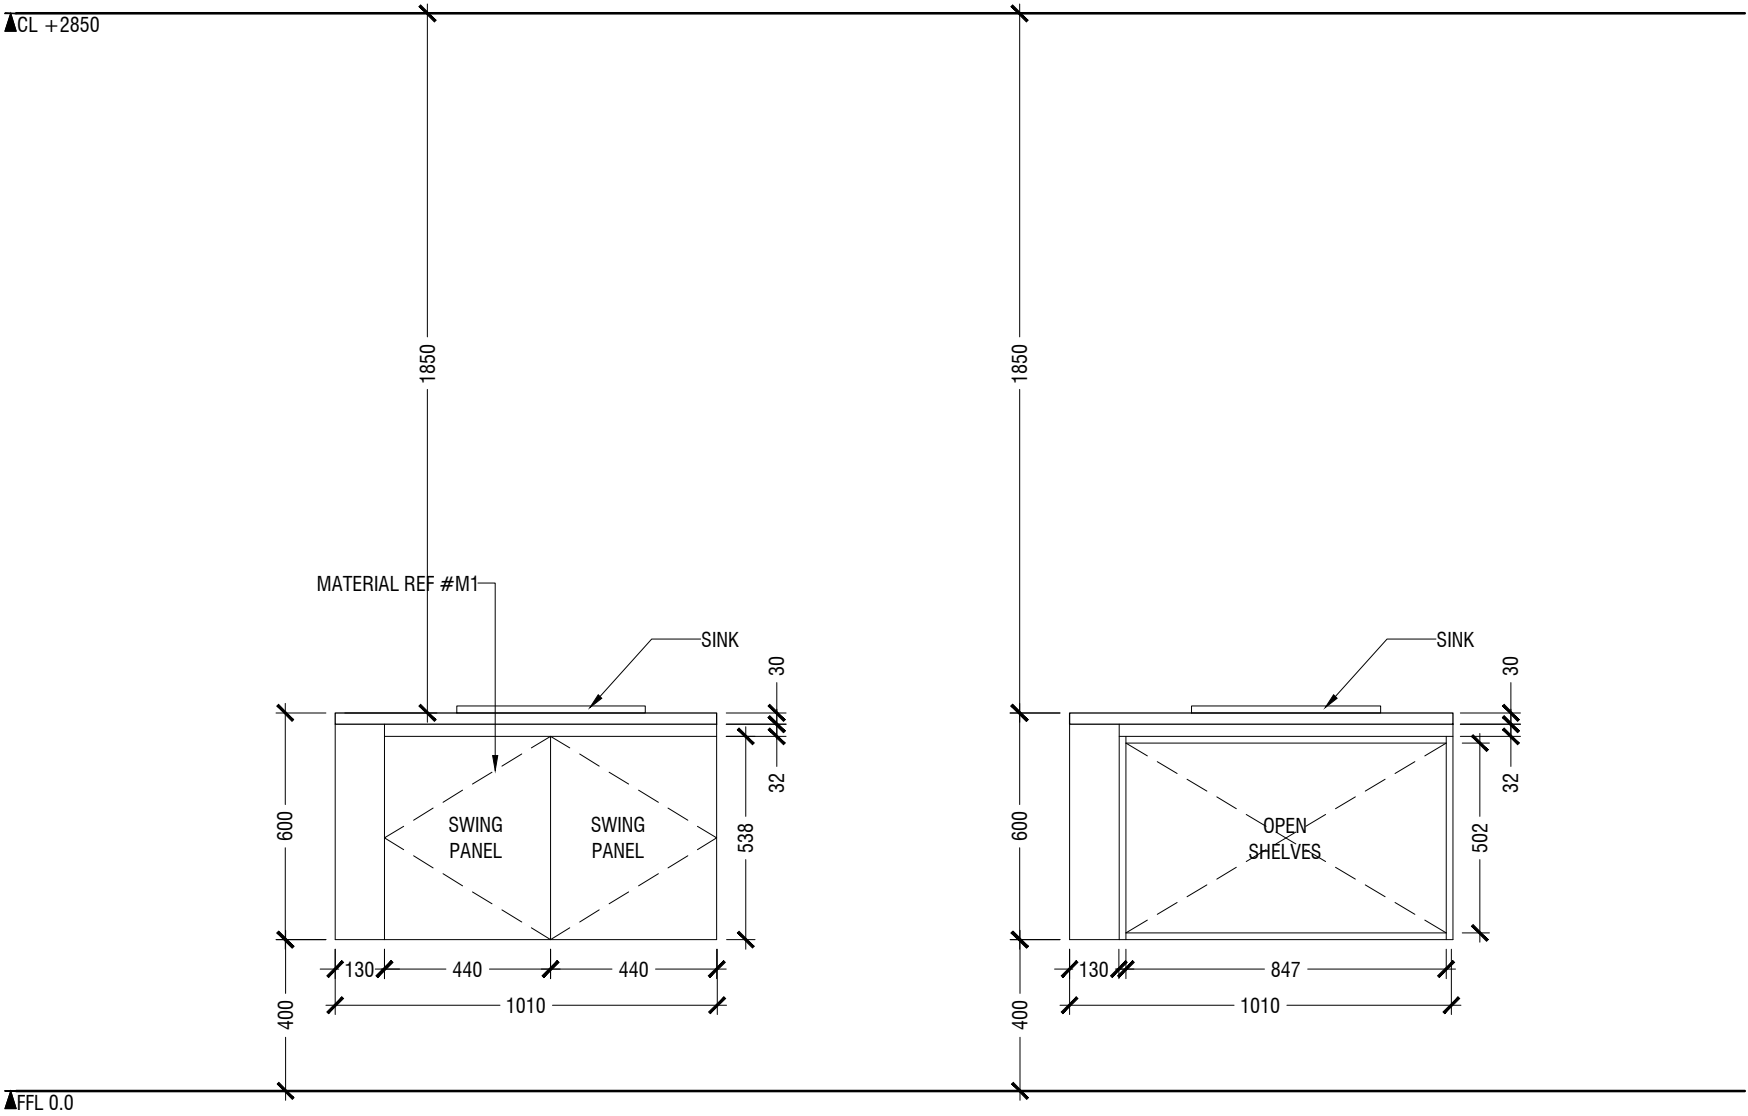

MACO

D E S I G N S

Contact: 7989966, 7691671

Email: info@maco.mv

CLIENT:

IGMH

PROJECT:

IGMH CATH LAB

K. MALE

SCALE: AS GIVEN

DRWNG TITLE : AS GIVN

DATE: D015M07Y26

REVISION NO.: 00

FILE NAME:

\\DLINK-031BBD\Volume_1\MACO
PROJECTS\2026


WARNING:

- This drawing shall not be used for construction unless certified.
- Contractor to verify all dimensions of existing works on site before commencing any work or preparing shop drawings.
- Do not scale drawings, use written dimensions only.
- This drawing is to be read in conjunction with the specifications and conditions of contract.
- This drawing and design is copyright and no portion may be reproduced without the permission of the MACO architects

ID12


1.07 HAND WASH AREA
LOCATION "PROCEDURE ROOM"
SCALE 1:20

- NOTE
- CL = CEILING LINE
 - DCL = DROP CEILING LINE
 - FFL = FLOOR FINISH LINE

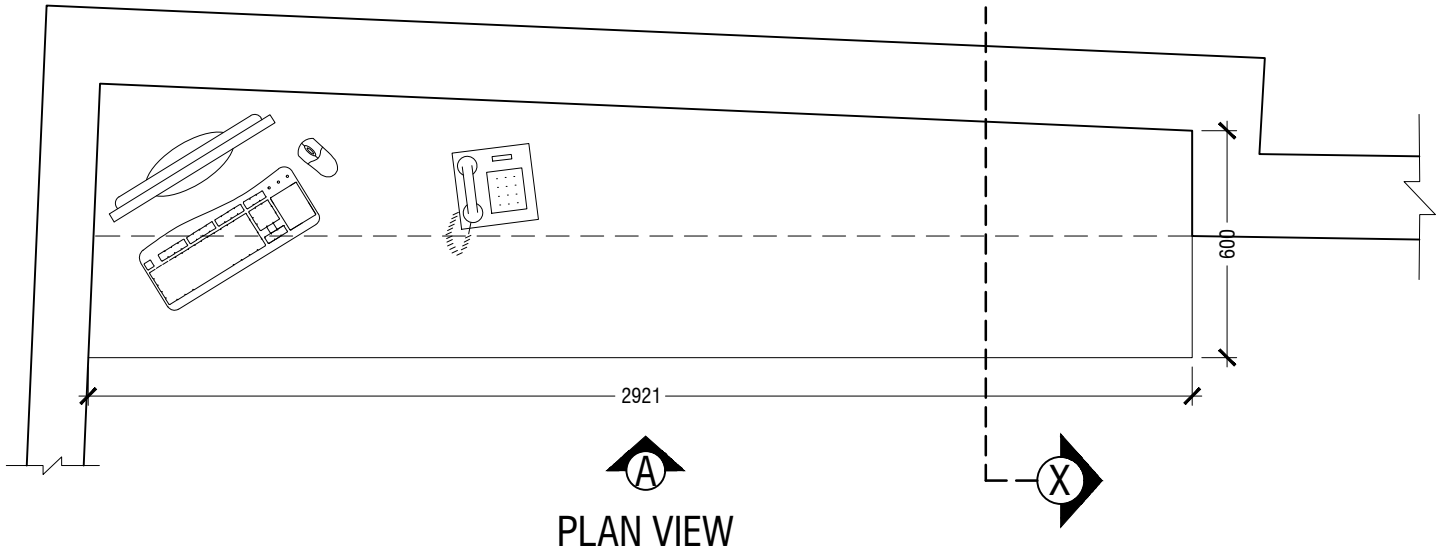

*FINAL DIMENSIONS ARE SUBJECT TO CHANGE DEPENDING ON CONTRACTORS ADJUSTMENTS ON SITE

*SLANTED WALL ALIGNMENT TO BE CONFIRMED ON SITE

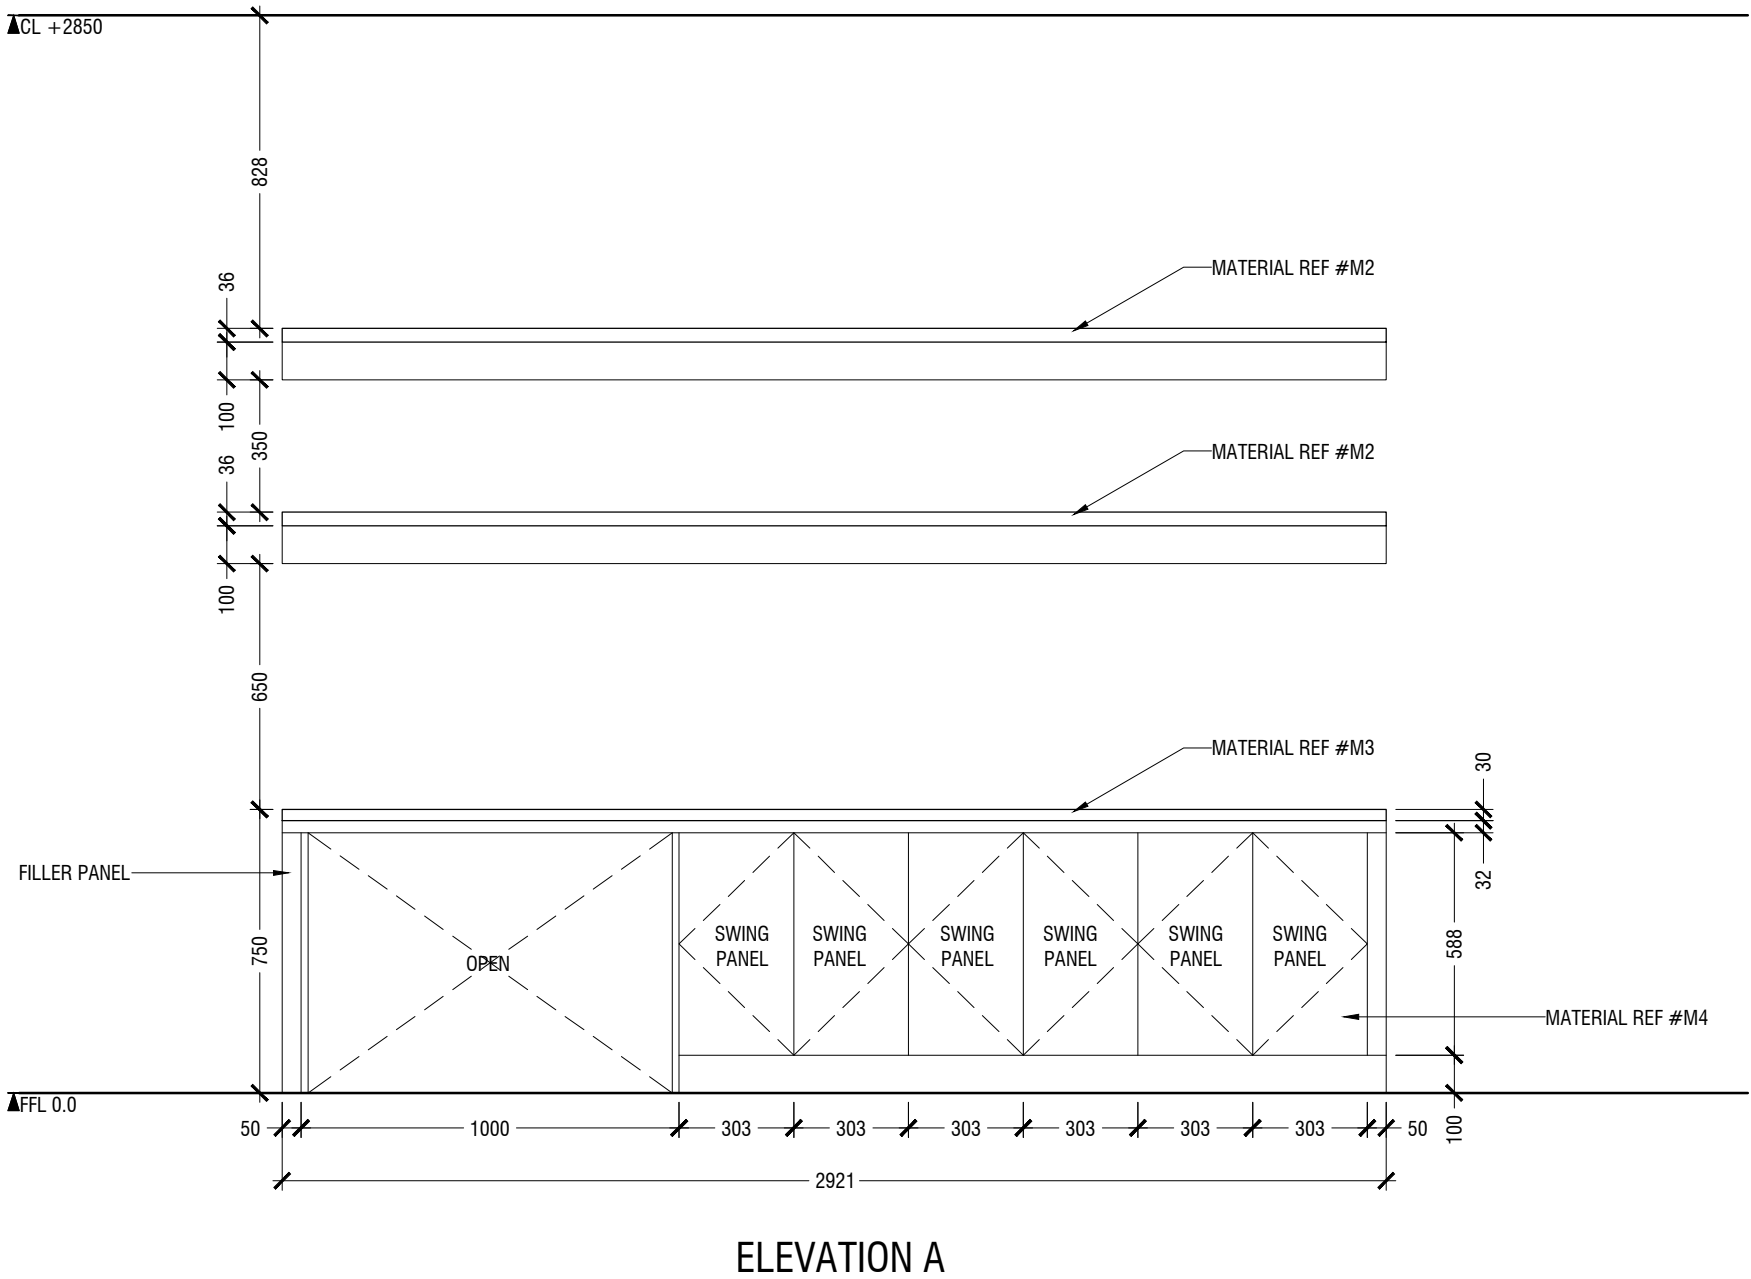

MACO
DESIGNS

Contact: 7989966, 7691671
Email: info@maco.mv

CLIENT:

IGMH

PROJECT:

IGMH CATH LAB
K. MALE

SCALE: AS GIVEN

DRWNG TITLE : AS GIVN

DATE: D015M07Y26

REVISION NO.: 00

FILE NAME:

\\DLINK-031BBD\Volume_1\MACO
PROJECTS\2026

WARNING:

- This drawing shall not be used for construction unless certified.
- Contractor to verify all dimensions of existing works on site before commencing any work or preparing shop drawings.
- Do not scale drawings, use written dimensions only.
- This drawing is to be read in conjunction with the specifications and conditions of contract.
- This drawing and design is copyright and no portion may be reproduced without the permission of the MACO architects



1.08 WORK STATION
LOCATION "PROCEDURE ROOM"
SCALE 1:20

ID13

- NOTE
- CL = CEILING LINE
 - DCL = DROP CEILING LINE
 - FFL = FLOOR FINISH LINE

*FINAL DIMENSIONS ARE SUBJECT TO CHANGE DEPENDING ON CONTRACTORS ADJUSTMENTS ON SITE

*SLANTED WALL ALIGNMENT TO BE CONFIRMED ON SITE

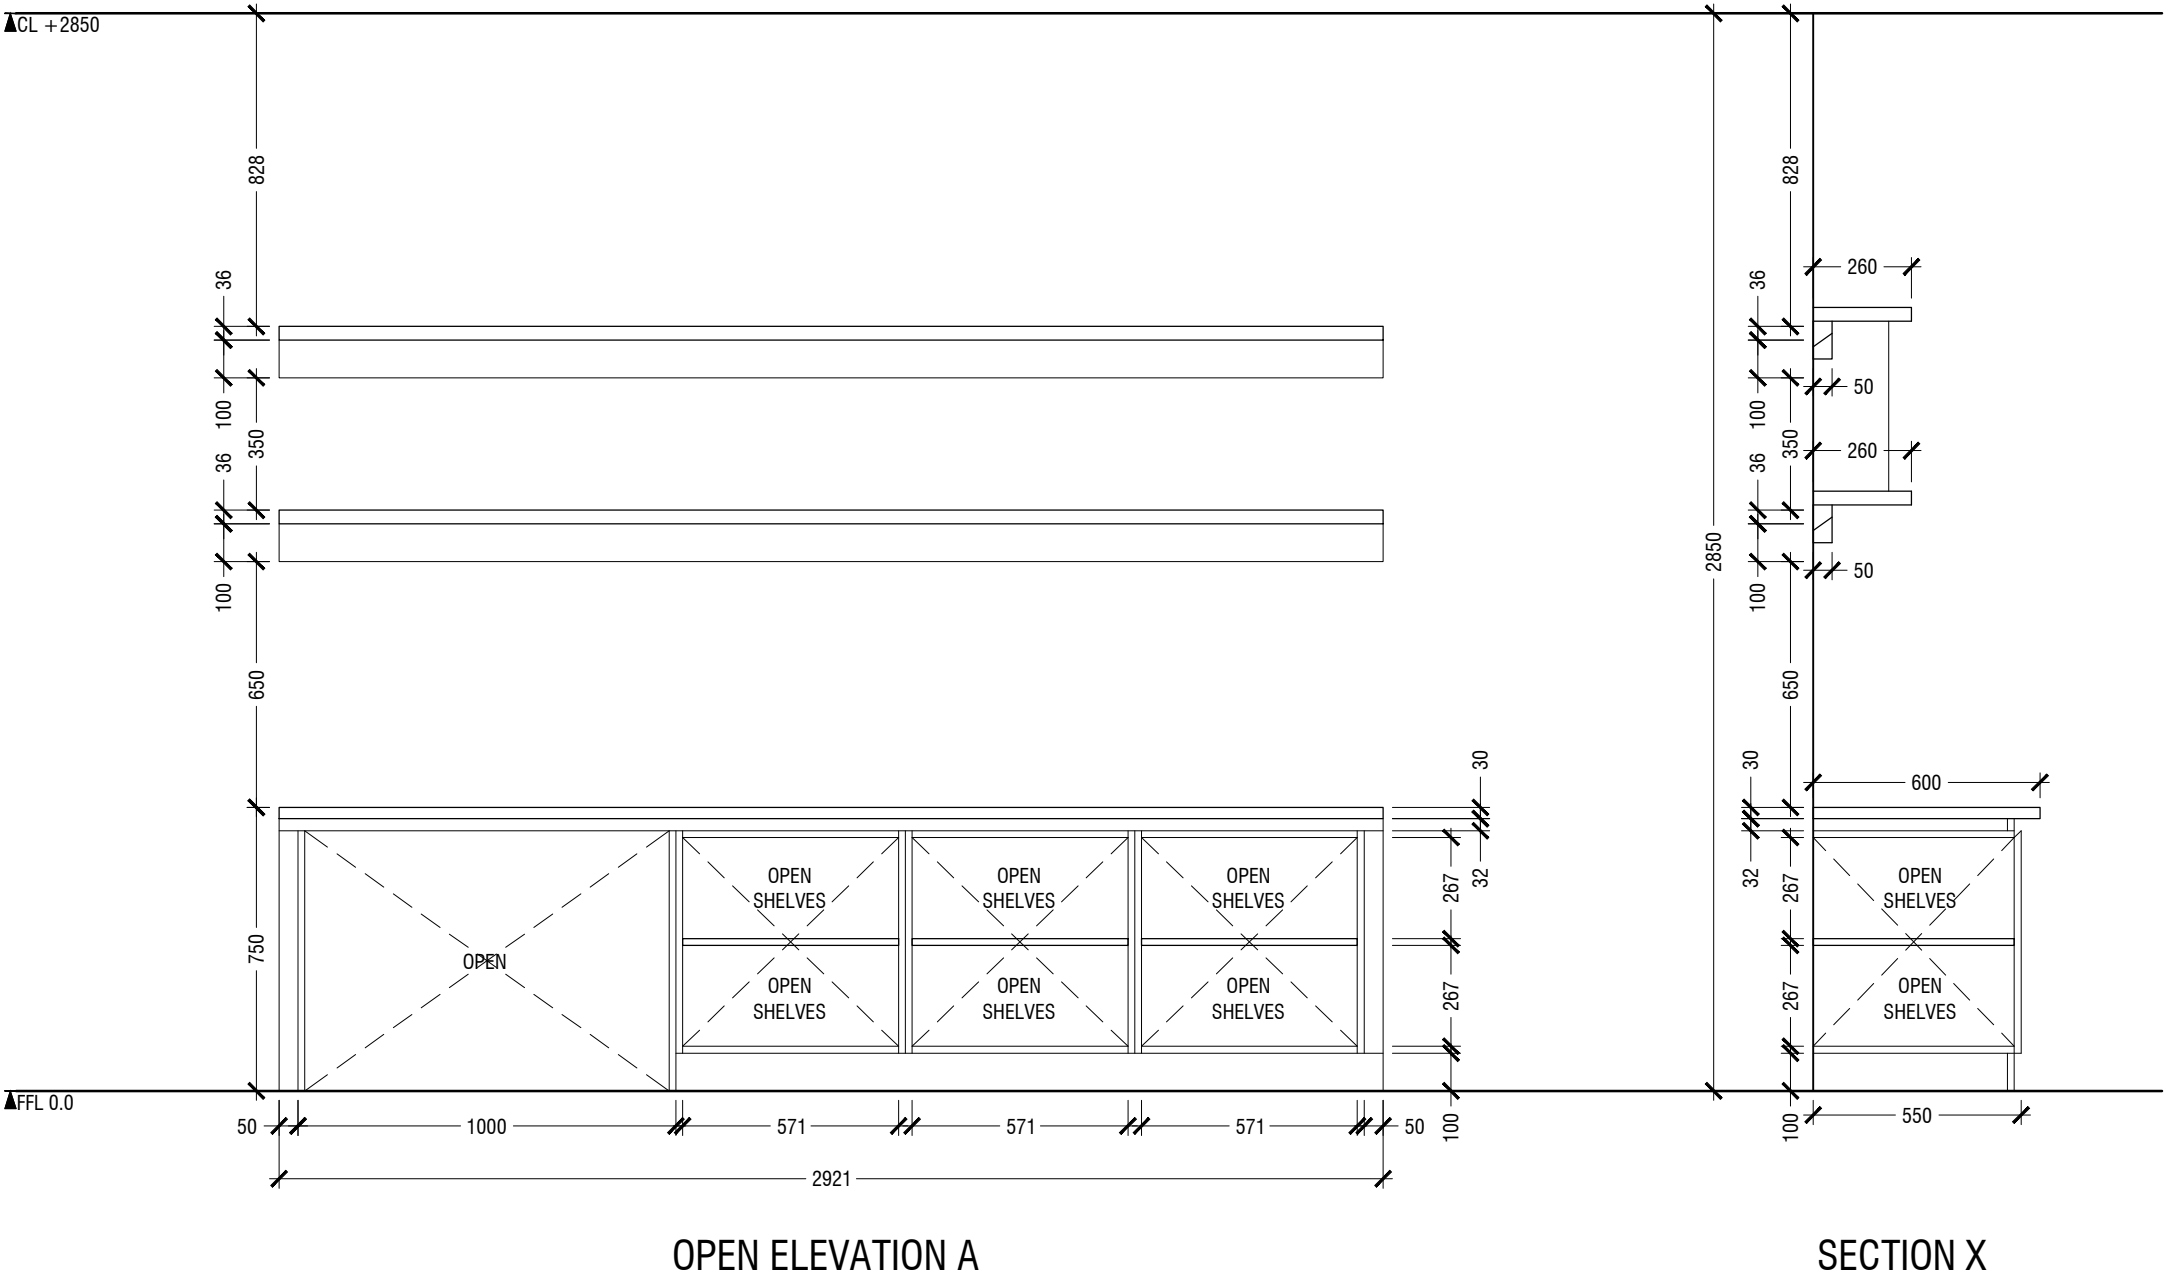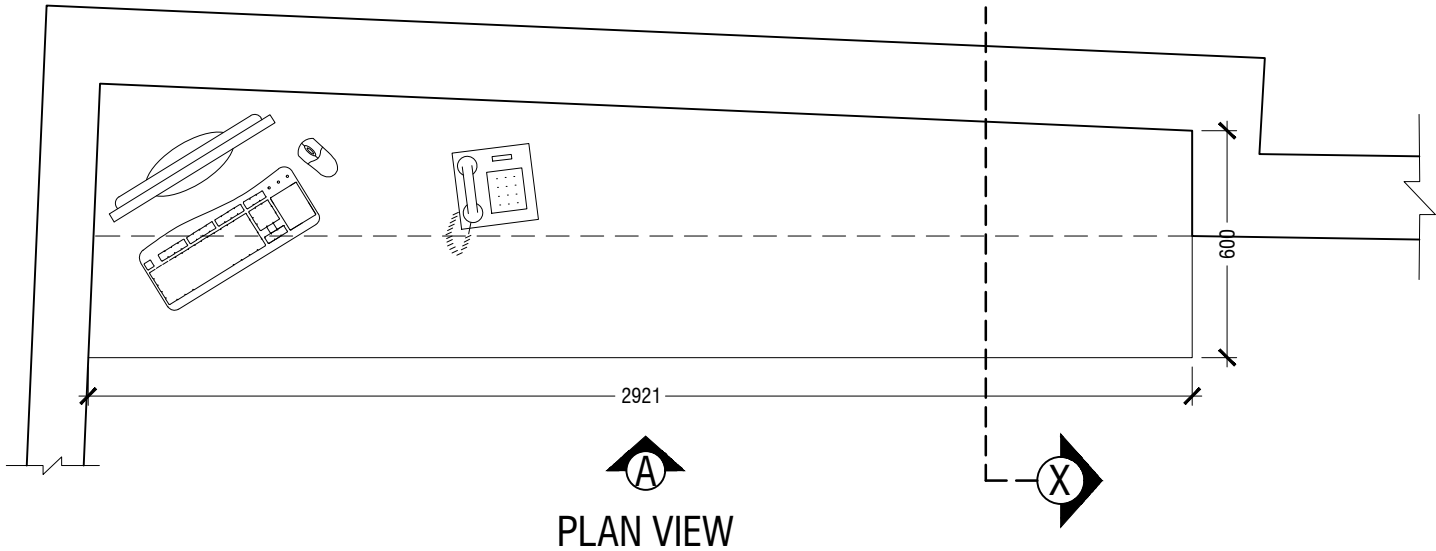

MACO
DESIGNS

Contact: 7989966, 7691671
Email: info@maco.mv

CLIENT:
IGMH

PROJECT:
IGMH CATH LAB
K. MALE

SCALE: AS GIVEN

DRWNG TITLE : AS GIVN

DATE: D015M07Y26

REVISION NO.: 00

FILE NAME:
\\DLINK-031BBD\Volume_1\MACO PROJECTS\2026

WARNING:

- This drawing shall not be used for construction unless certified.
- Contractor to verify all dimensions of existing works on site before commencing any work or preparing shop drawings.
- Do not scale drawings, use written dimensions only.
- This drawing is to be read in conjunction with the specifications and conditions of contract.
- This drawing and design is copyright and no portion may be reproduced without the permission of the MACO architects


1.08 WORK STATION
LOCATION "PROCEDURE ROOM"
SCALE 1:20

ID14

- NOTE
- CL = CEILING LINE
 - DCL = DROP CEILING LINE
 - FFL = FLOOR FINISH LINE

*FINAL DIMENSIONS ARE SUBJECT TO CHANGE DEPENDING ON CONTRACTORS ADJUSTMENTS ON SITE

*SLANTED WALL ALIGNMENT TO BE CONFIRMED ON SITE

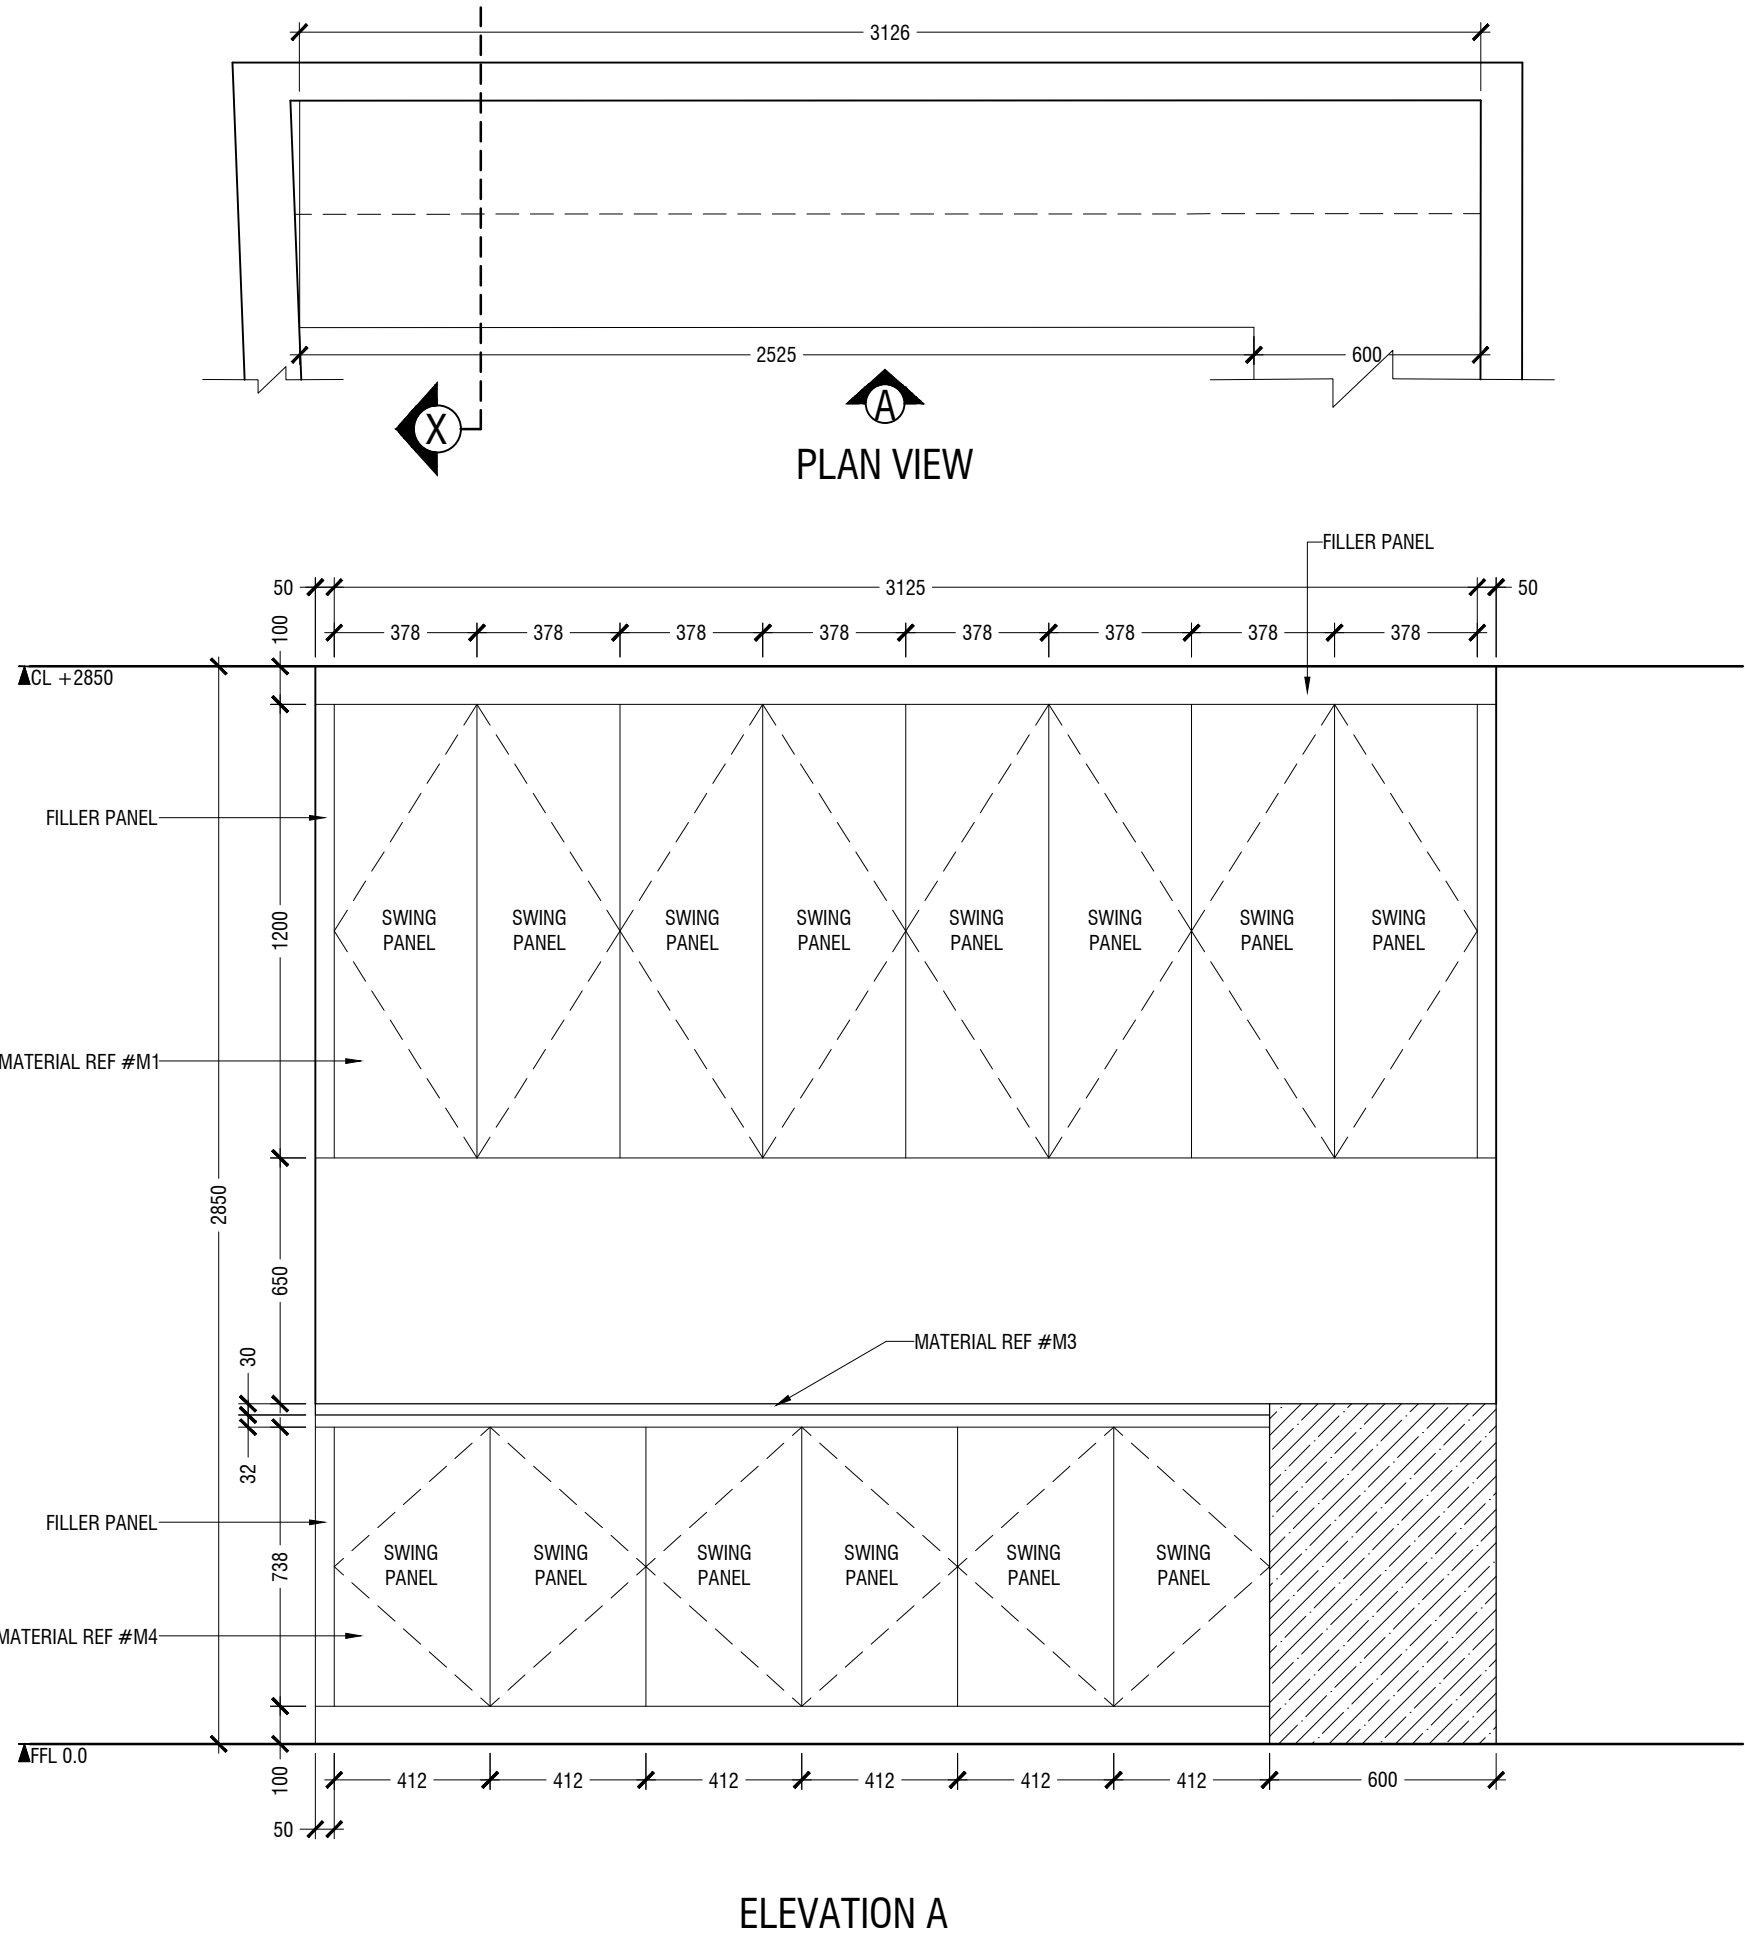

ELEVATION A

1.09 CLEAN UTILITY COUNTER
LOCATION "CLEAN UTILITY"
SCALE 1:20

MACO
DESIGNS
Contact: 7989966, 7691671
Email: info@maco.mv

CLIENT:
IGMH

PROJECT:
IGMH CATH LAB
K. MALE

SCALE: AS GIVEN

DRWNG TITLE : AS GIVN

DATE: D015M07Y26

REVISION NO.: 00

FILE NAME:
\\DLINK-031BBD\Volume_1\MACO
PROJECTS\2026



WARNING:
- This drawing shall not be used for construction unless certified.
- Contractor to verify all dimensions of existing works on site before commencing any work or preparing shop drawings.
- Do not scale drawings, use written dimensions only.
- This drawing is to be read in conjunction with the specifications and conditions of contract.
- This drawing and design is copyright and no portion may be reproduced without the permission of the MACO architects

ID15

- NOTE
- CL = CEILING LINE
 - DCL = DROP CEILING LINE
 - FFL = FLOOR FINISH LINE

*FINAL DIMENSIONS ARE SUBJECT TO CHANGE DEPENDING ON CONTRACTORS ADJUSTMENTS ON SITE

*SLANTED WALL ALIGNMENT TO BE CONFIRMED ON SITE

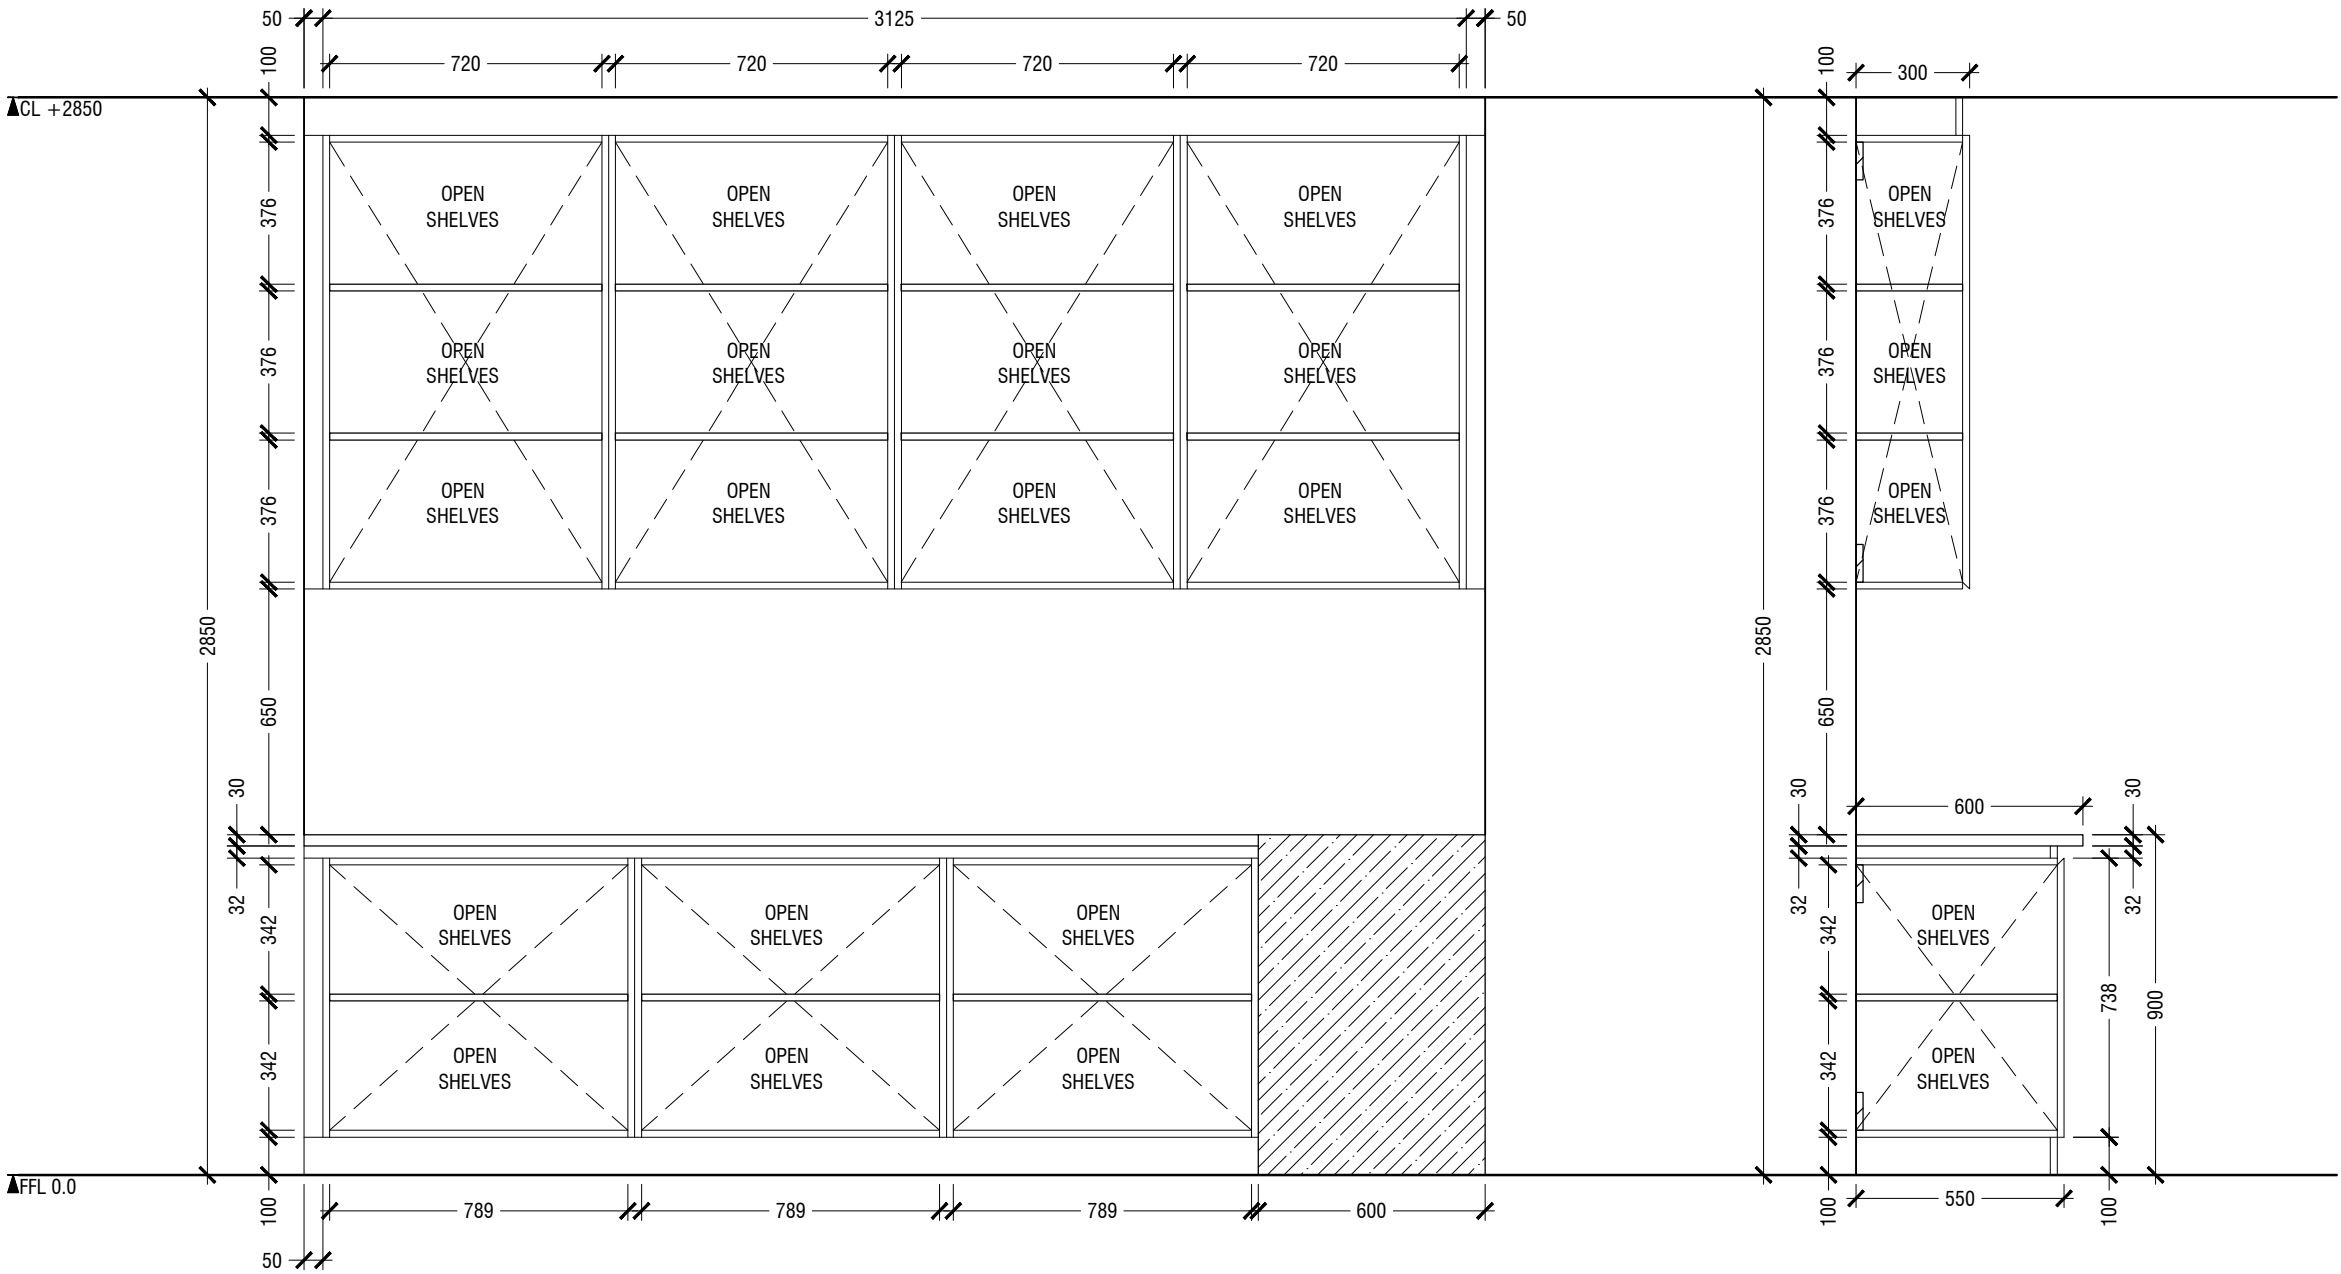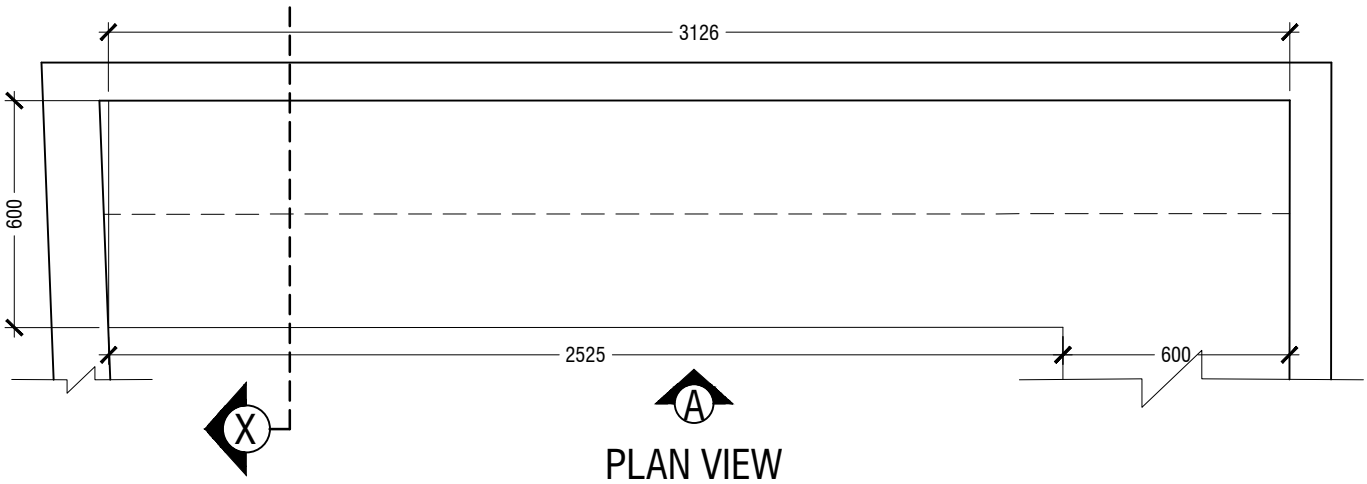

MACO
DESIGNS

Contact: 7989966, 7691671
Email: info@maco.mv

CLIENT:
IGMH

PROJECT:
IGMH CATH LAB
K. MALE

SCALE: AS GIVEN

DRWNG TITLE : AS GIVN

DATE: D015M07Y26

REVISION NO.: 00

FILE NAME:
\\DLINK-031BBD\Volume_1\MACO
PROJECTS\2026


WARNING:

- This drawing shall not be used for construction unless certified.
- Contractor to verify all dimensions of existing works on site before commencing any work or preparing shop drawings.
- Do not scale drawings, use written dimensions only.
- This drawing is to be read in conjunction with the specifications and conditions of contract.
- This drawing and design is copyright and no portion may be reproduced without the permission of the MACO architects


- NOTE
- CL = CEILING LINE
 - DCL = DROP CEILING LINE
 - FFL = FLOOR FINISH LINE

*FINAL DIMENSIONS ARE SUBJECT TO CHANGE DEPENDING ON CONTRACTORS ADJUSTMENTS ON SITE

*SLANTED WALL ALIGNMENT TO BE CONFIRMED ON SITE

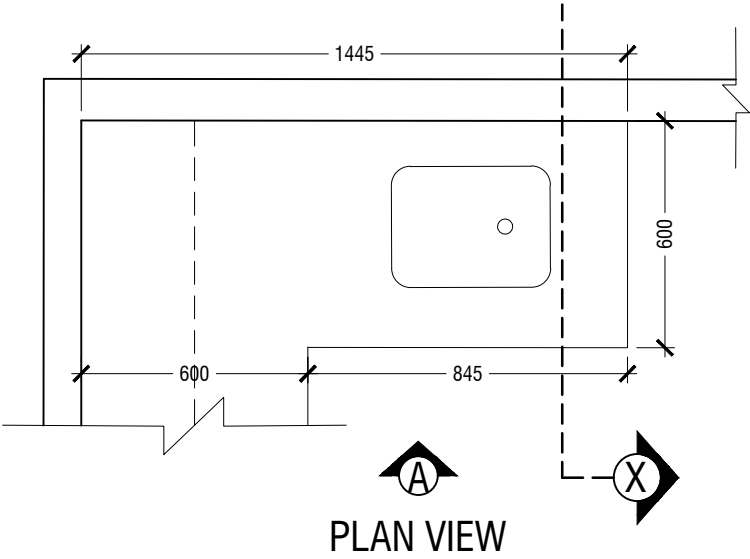

PLAN VIEW

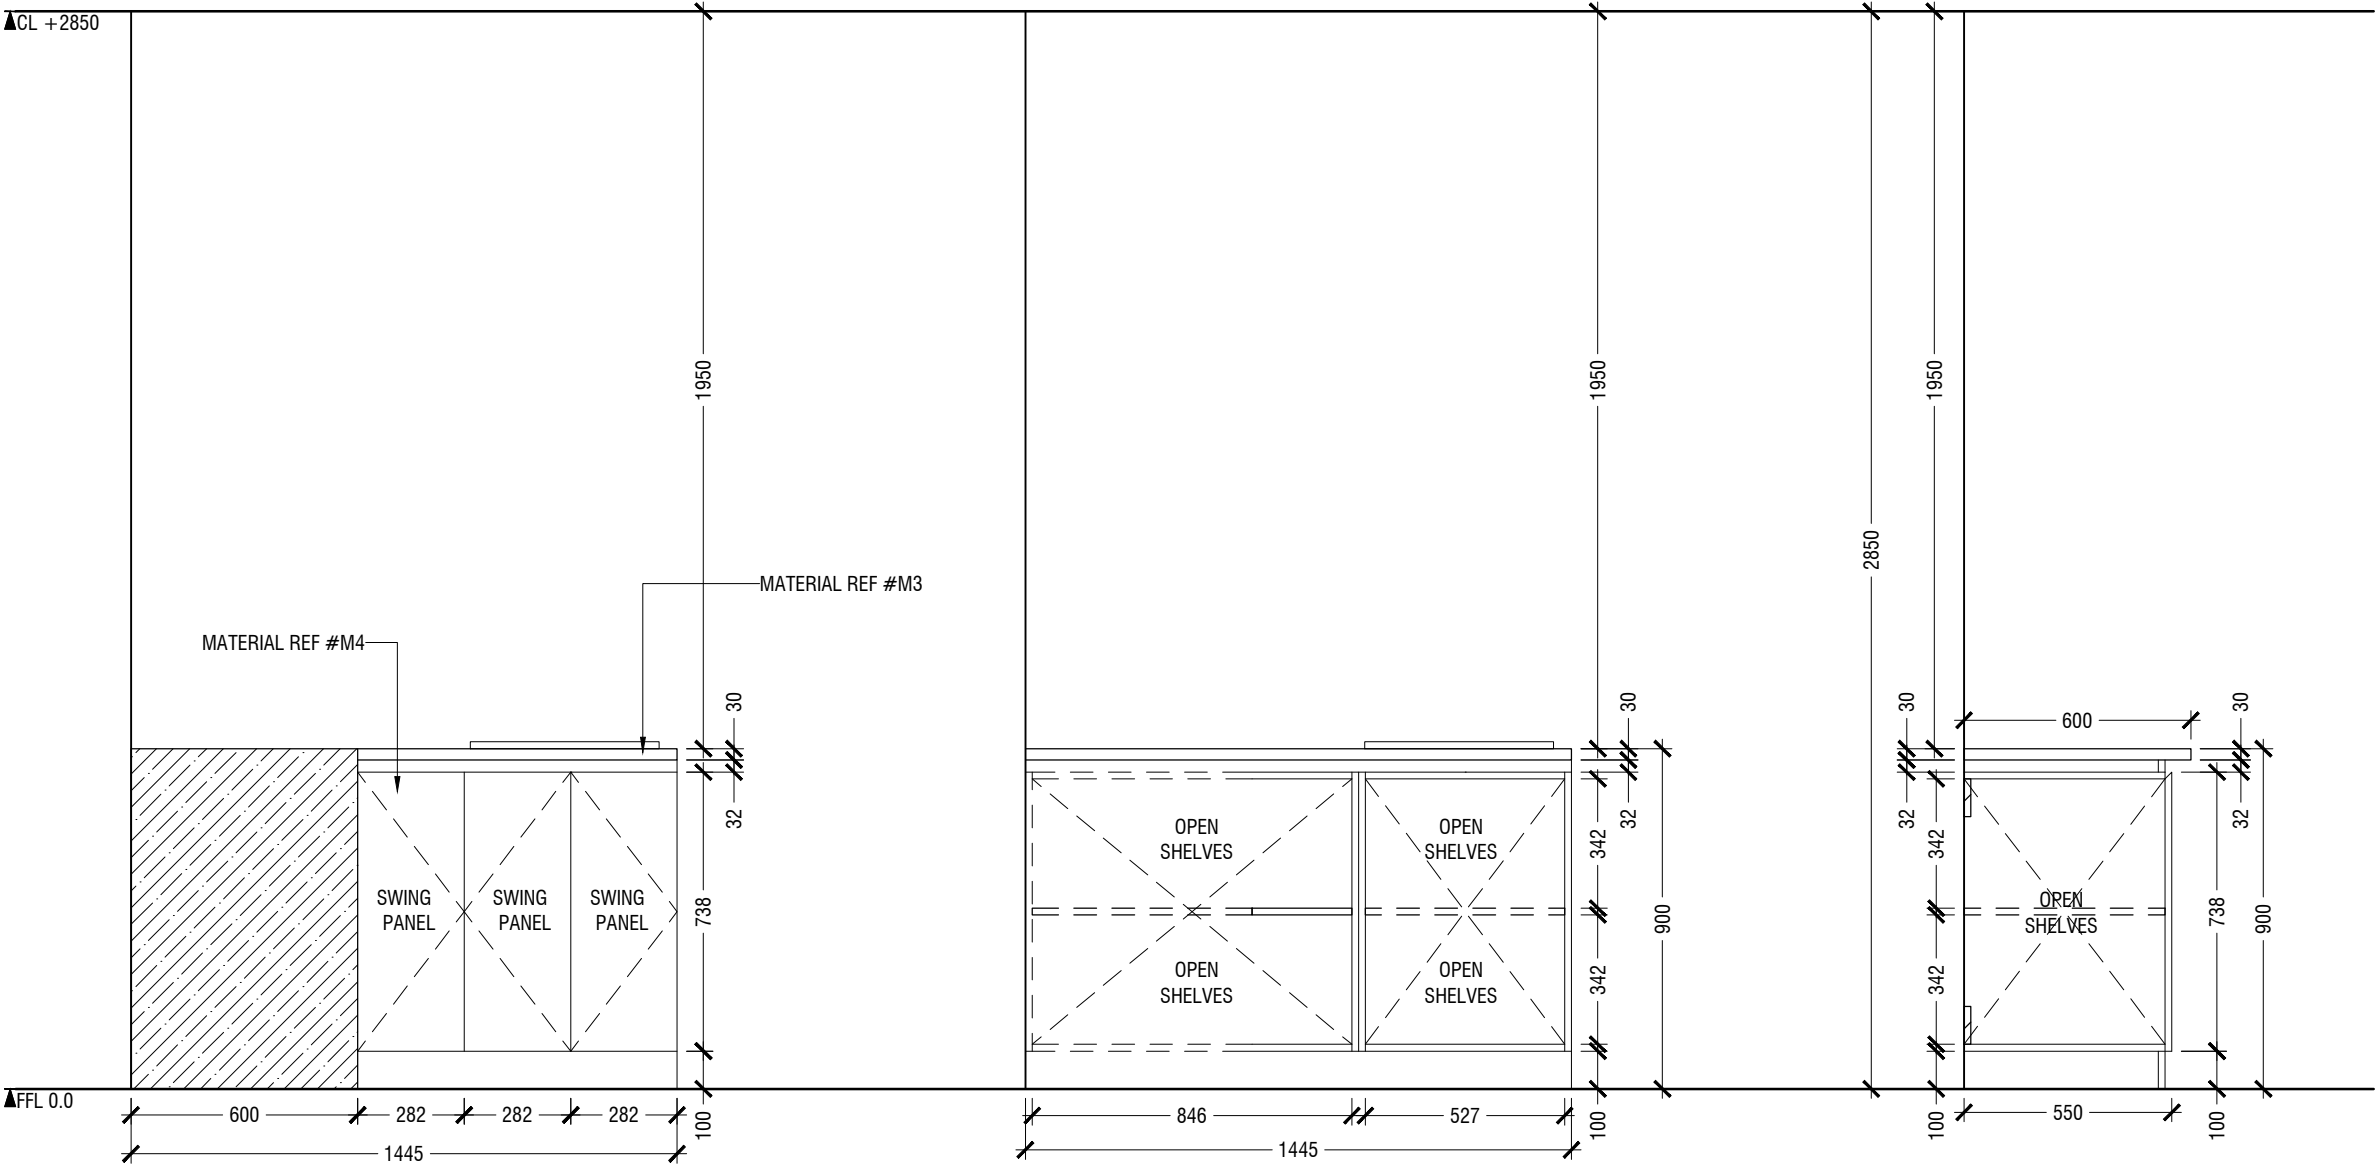

ELEVATION A

OPEN ELEVATION A

SECTION X

1.09 CLEAN UTILITY COUNTER
LOCATION "CLEAN UTILITY"
SCALE 1:20

MACO
DESIGNS
Contact: 7989966, 7691671
Email: info@maco.mv

CLIENT:
IGMH

PROJECT:
IGMH CATH LAB
K. MALE

SCALE: AS GIVEN

DRWNG TITLE : AS GIVN

DATE: D015M07Y26

REVISION NO.: 00

FILE NAME:
\\DLINK-031BBD\Volume_1\MACO
PROJECTS\2026

WARNING:
- This drawing shall not be used for construction unless certified.
- Contractor to verify all dimensions of existing works on site before commencing any work or preparing shop drawings.
- Do not scale drawings, use written dimensions only.
- This drawing is to be read in conjunction with the specifications and conditions of contract.
- This drawing and design is copyright and no portion may be reproduced without the permission of the MACO architects

ID17

- CL = CEILING LINE
- DCL = DROP CEILING LINE
- FFL = FLOOR FINISH LINE

*SLANTED WALL ALIGNMENT TO BE CONFIRMED ON SITE



ELEVATION A

- This drawing shall not be used for construction unless certified.
- Contractor to verify all dimensions of existing works on site before commencing any work or preparing shop drawings.
- Do not scale drawings, use written dimensions only.
- This drawing is to be read in conjunction with the specifications and conditions of contract.
- This drawing and design is copyright and no portion may be reproduced without the permission of the MACO architects



ID18

1.10 STORAGE COUNTER
LOCATION "TEA ROOM"
SCALE 1:20

- NOTE
- CL = CEILING LINE
 - DCL = DROP CEILING LINE
 - FFL = FLOOR FINISH LINE

*FINAL DIMENSIONS ARE SUBJECT TO CHANGE DEPENDING ON CONTRACTORS ADJUSTMENTS ON SITE

*SLANTED WALL ALIGNMENT TO BE CONFIRMED ON SITE

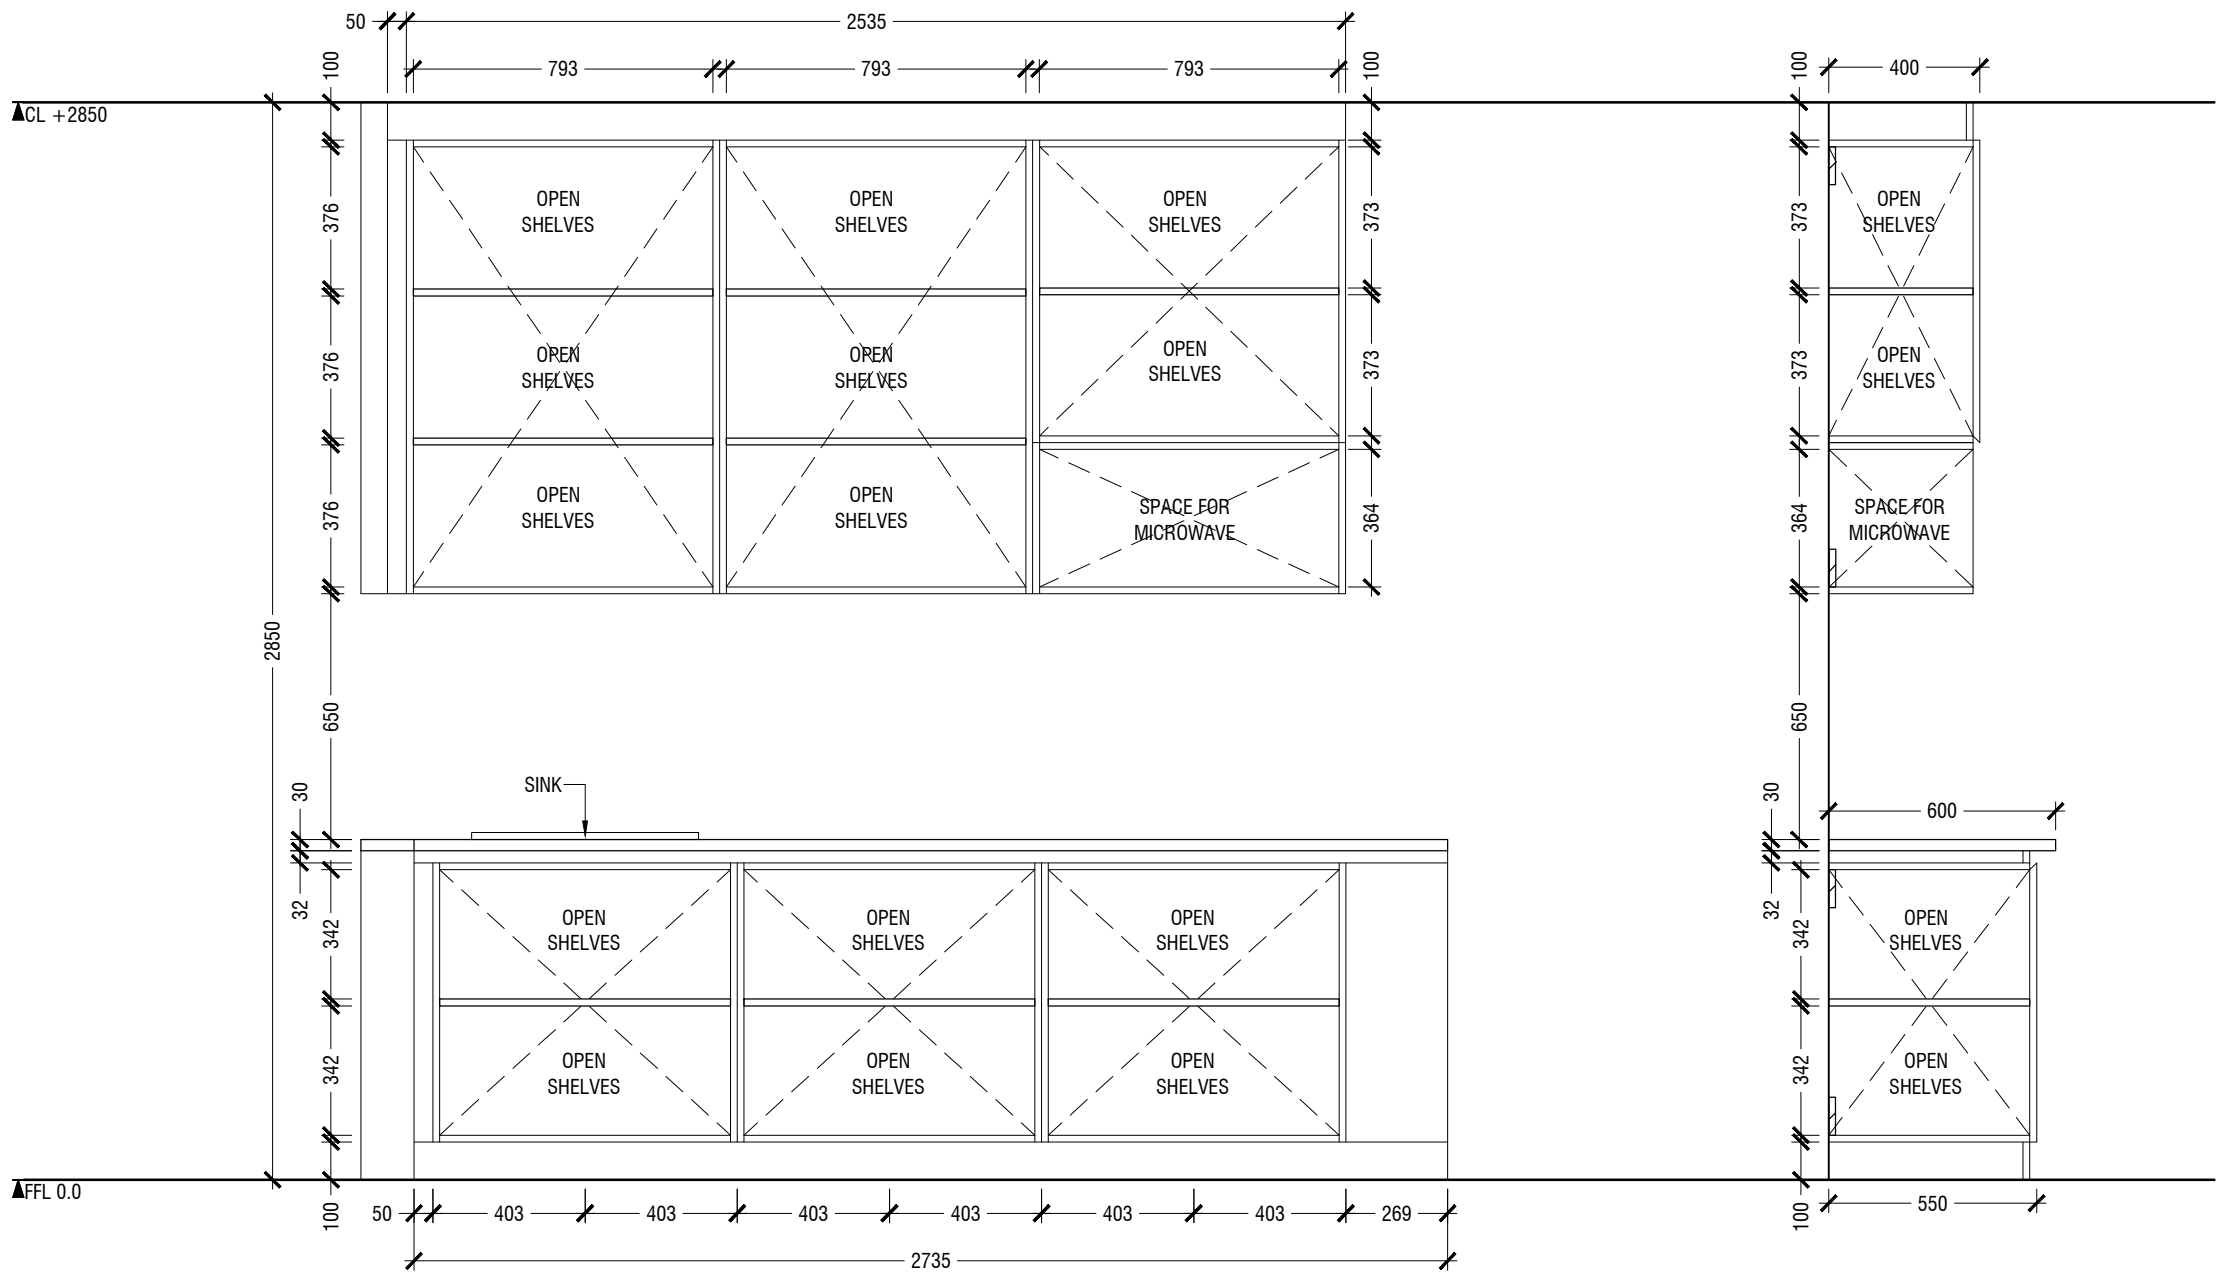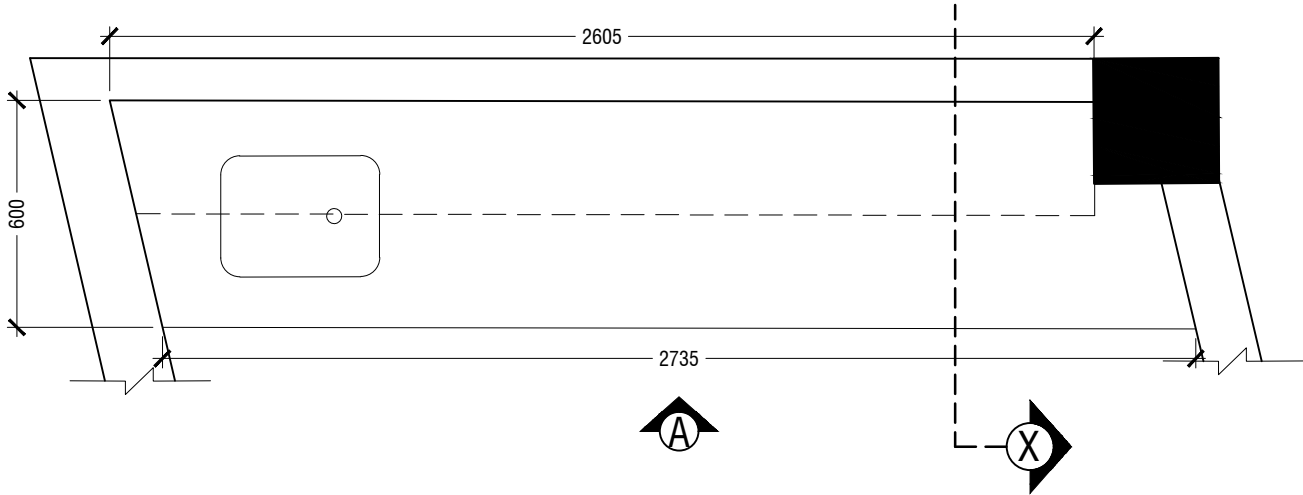

1.10 STORAGE COUNTER
LOCATION "TEA ROOM"
SCALE 1:20

MACO
DESIGNS
Contact: 7989966, 7691671
Email: info@maco.mv

CLIENT:
IGMH
PROJECT:
IGMH CATH LAB
K. MALE

SCALE: AS GIVEN
DRWNG TITLE : AS GIVN
DATE: D015M07Y26
REVISION NO.: 00

FILE NAME:
\\DLINK-031BBD\Volume_1\MACO
PROJECTS\2026



WARNING:
- This drawing shall not be used for construction unless certified.
- Contractor to verify all dimensions of existing works on site before commencing any work or preparing shop drawings.
- Do not scale drawings, use written dimensions only.
- This drawing is to be read in conjunction with the specifications and conditions of contract.
- This drawing and design is copyright and no portion may be reproduced without the permission of the MACO architects

ID19

- NOTE
- CL = CEILING LINE
 - DCL = DROP CEILING LINE
 - FFL = FLOOR FINISH LINE

*FINAL DIMENSIONS ARE SUBJECT TO CHANGE DEPENDING ON CONTRACTORS ADJUSTMENTS ON SITE

*SLANTED WALL ALIGNMENT TO BE CONFIRMED ON SITE

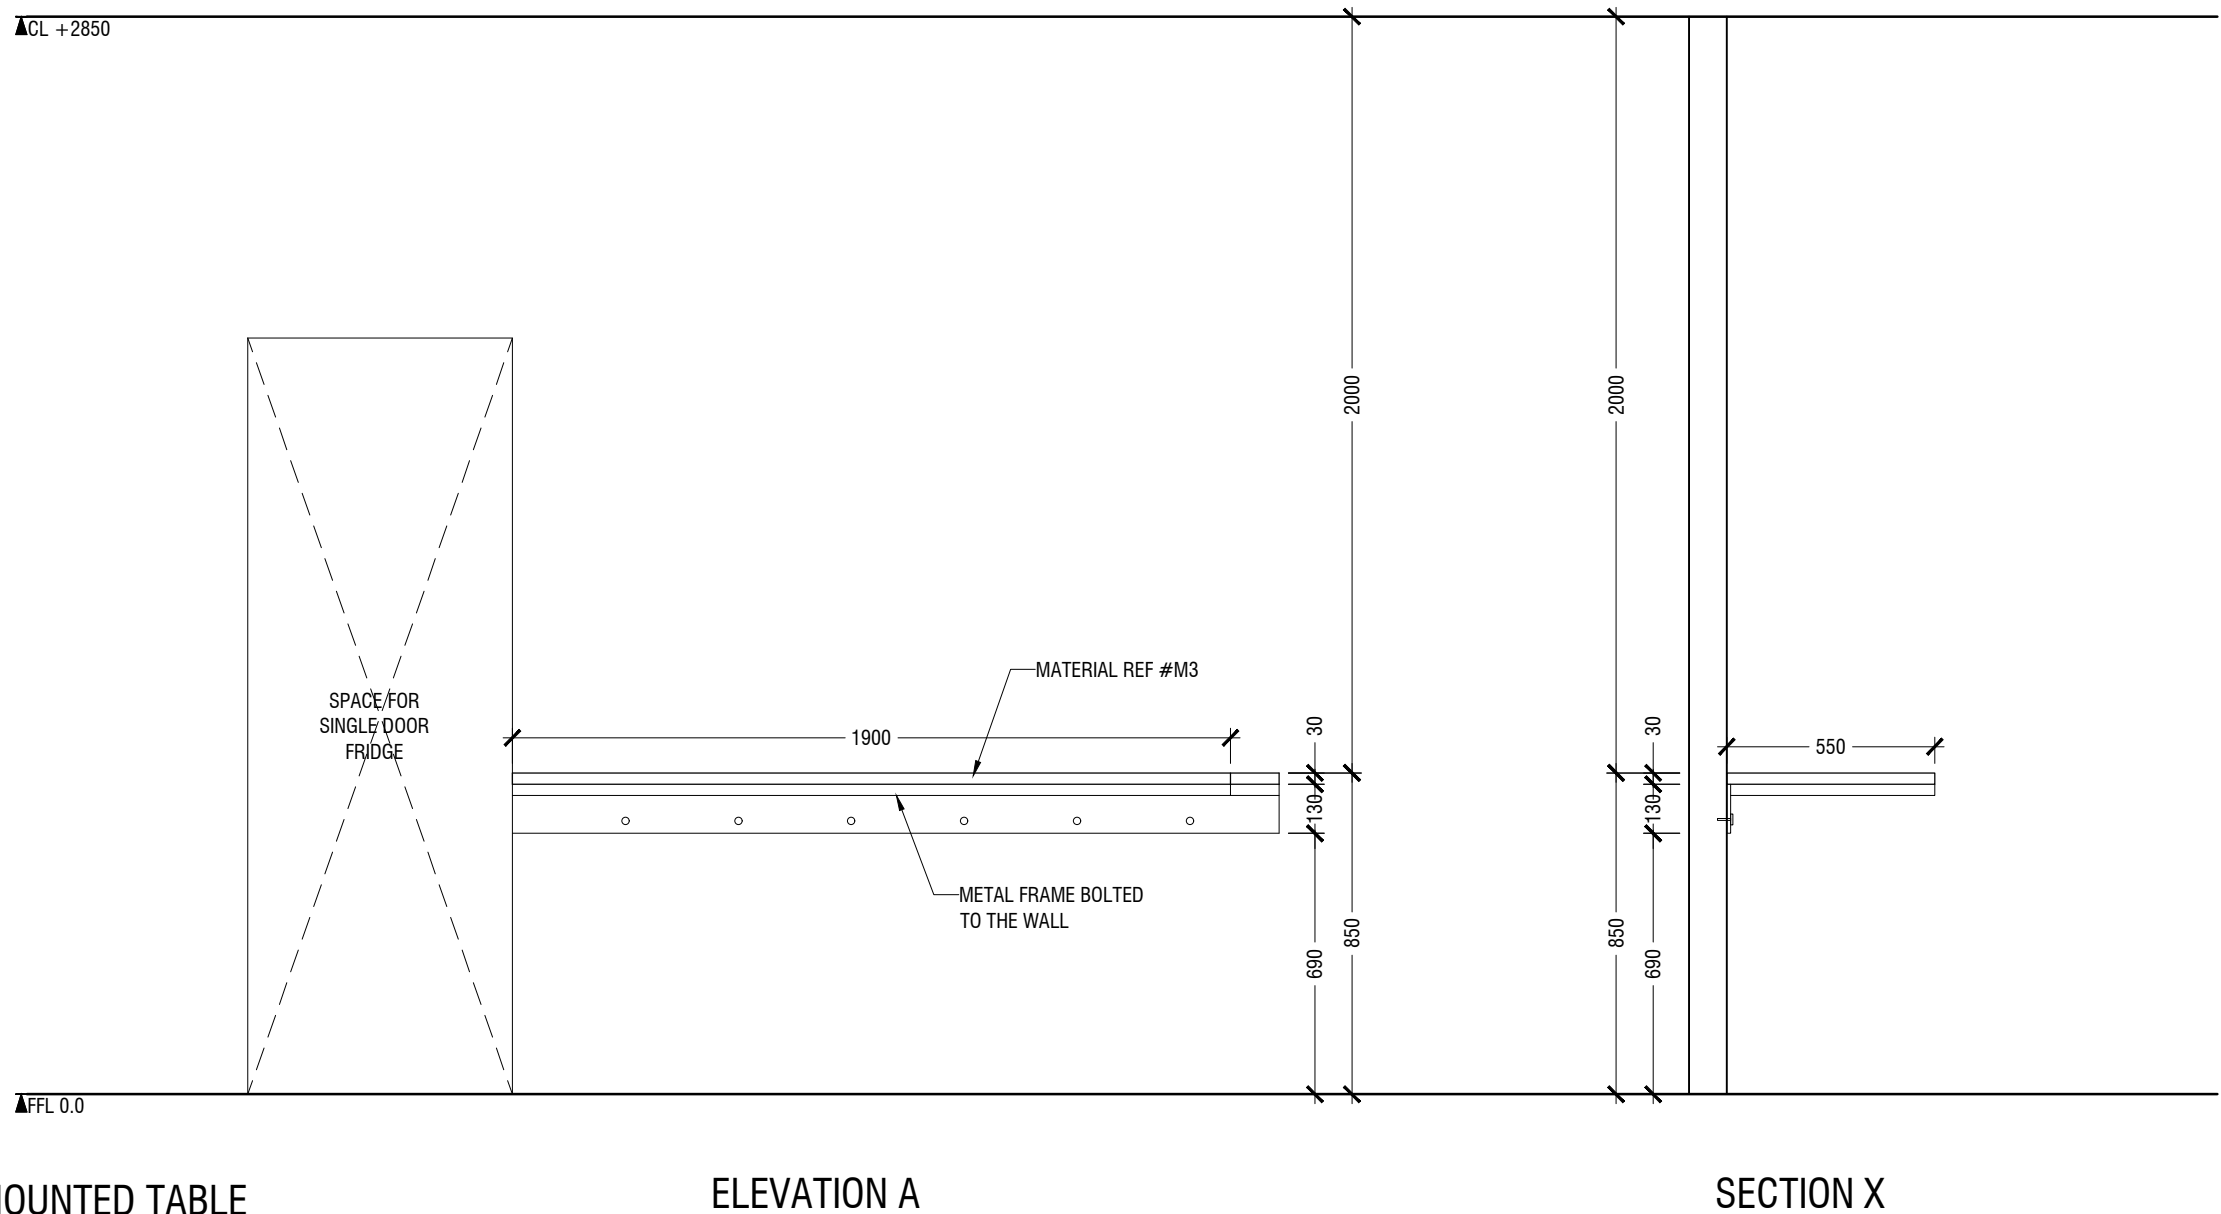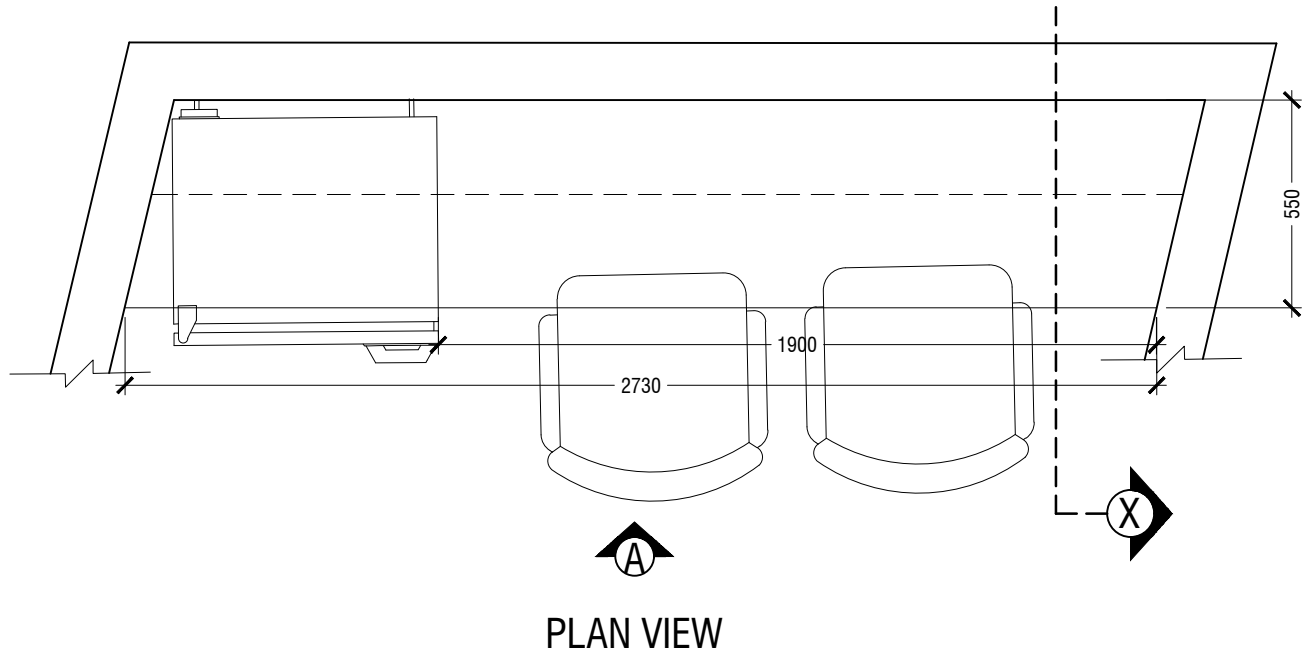

MACO
DESIGNS

Contact: 7989966, 7691671
Email: info@maco.mv

CLIENT:
IGMH

PROJECT:
IGMH CATH LAB
K. MALE

SCALE: AS GIVEN

DRWNG TITLE : AS GIVN

DATE: D015M07Y26

REVISION NO.: 00

FILE NAME:
\\DLINK-031BBD\Volume_1\MACO
PROJECTS\2026

WARNING:

- This drawing shall not be used for construction unless certified.
- Contractor to verify all dimensions of existing works on site before commencing any work or preparing shop drawings.
- Do not scale drawings, use written dimensions only.
- This drawing is to be read in conjunction with the specifications and conditions of contract.
- This drawing and design is copyright and no portion may be reproduced without the permission of the MACO architects



1.11 WALL MOUNTED TABLE
LOCATION "TEA ROOM"
SCALE 1:20

ID20

- NOTE
- CL = CEILING LINE
 - DCL = DROP CEILING LINE
 - FFL = FLOOR FINISH LINE

*FINAL DIMENSIONS ARE SUBJECT TO CHANGE DEPENDING ON CONTRACTORS ADJUSTMENTS ON SITE

*SLANTED WALL ALIGNMENT TO BE CONFIRMED ON SITE

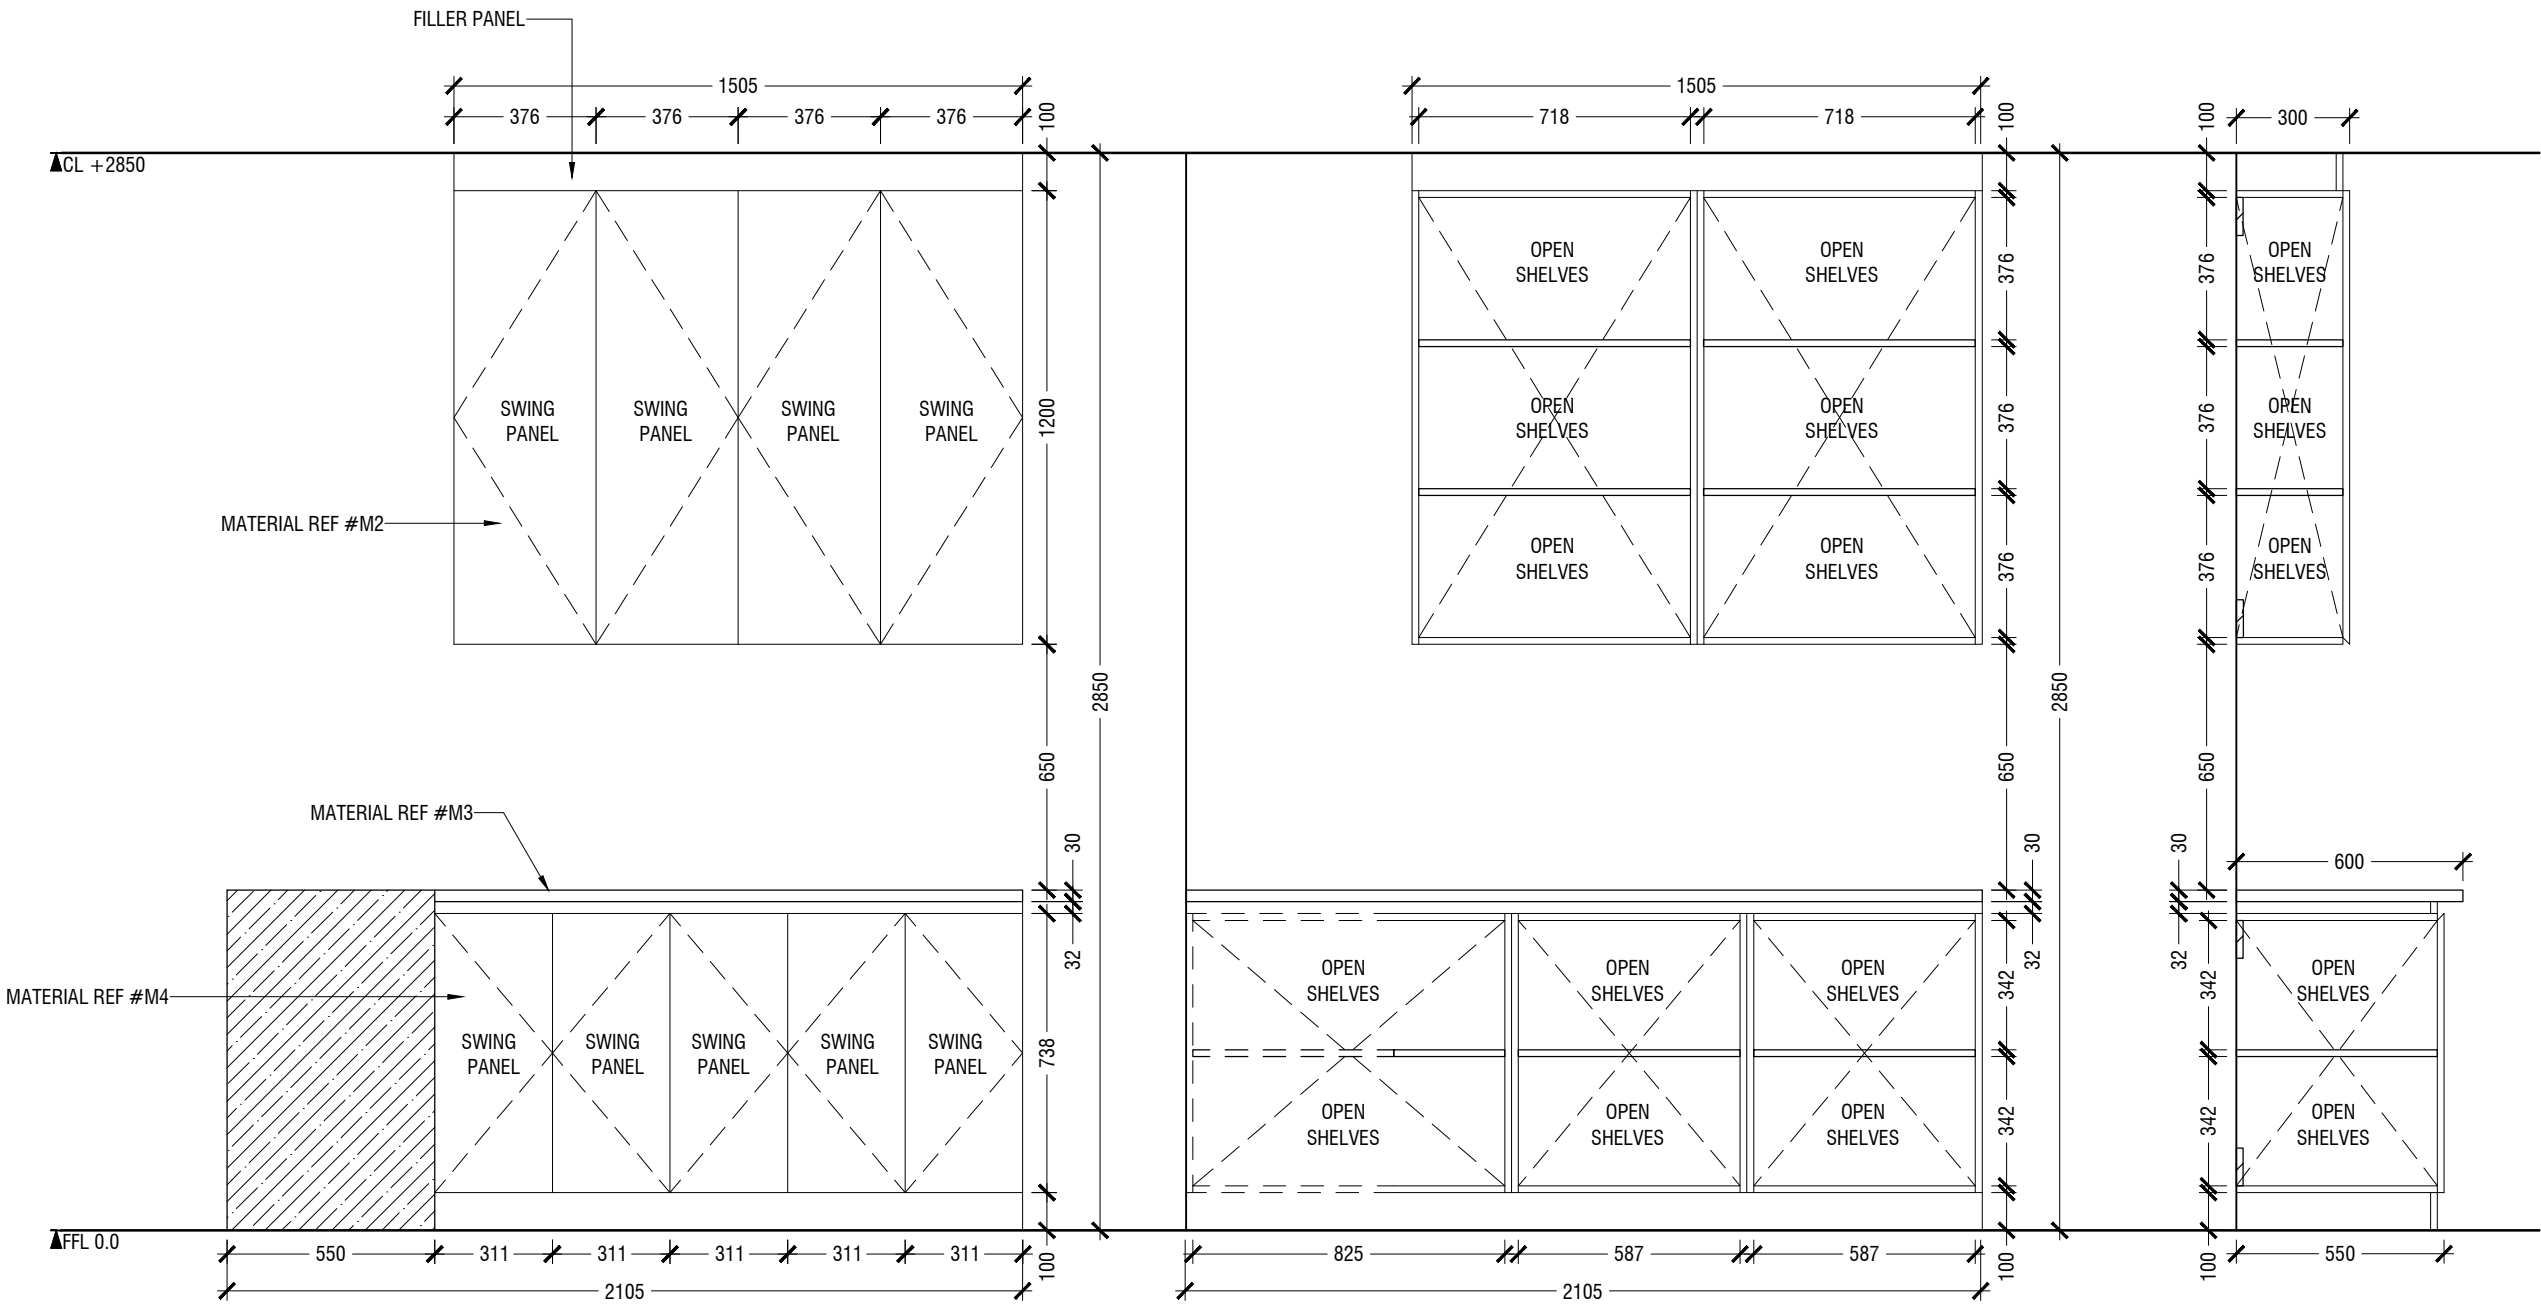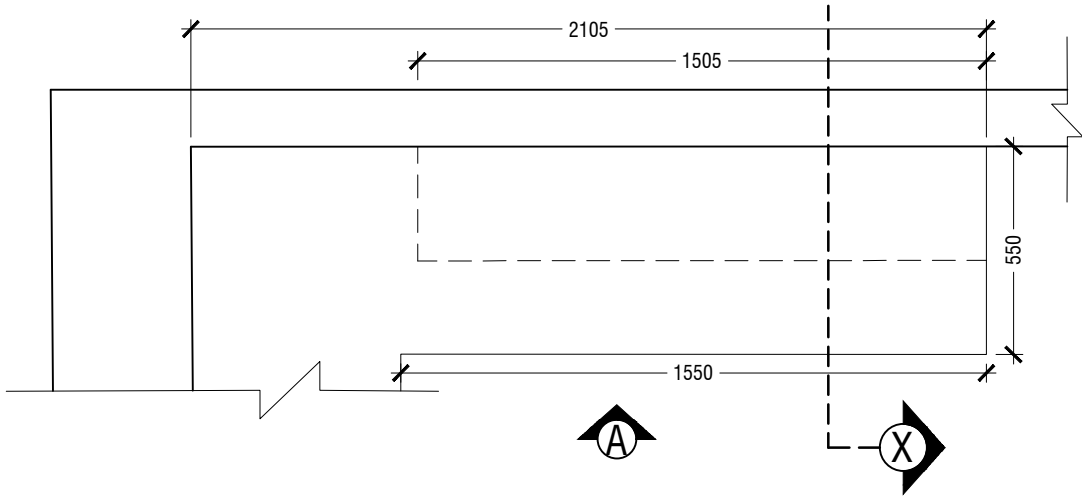

MACO
DESIGNS

Contact: 7989966, 7691671

Email: info@maco.mv

CLIENT:

IGMH

PROJECT:

IGMH CATH LAB

K. MALE

SCALE: AS GIVEN

DRWNG TITLE : AS GIVN

DATE: D015M07Y26

REVISION NO.: 00

FILE NAME:

\\DLINK-031BBD\\Volume_1\\MACO
PROJECTS\\2026

WARNING:

- This drawing shall not be used for construction unless certified.
- Contractor to verify all dimensions of existing works on site before commencing any work or preparing shop drawings.
- Do not scale drawings, use written dimensions only.
- This drawing is to be read in conjunction with the specifications and conditions of contract.
- This drawing and design is copyright and no portion may be reproduced without the permission of the MACO architects

1.12


STORAGE CABINET
LOCATION "CATH LAB AREA"
SCALE 1:20

ID21


- NOTE
- CL = CEILING LINE
 - DCL = DROP CEILING LINE
 - FFL = FLOOR FINISH LINE

*FINAL DIMENSIONS ARE SUBJECT TO CHANGE DEPENDING ON CONTRACTORS ADJUSTMENTS ON SITE

*SLANTED WALL ALIGNMENT TO BE CONFIRMED ON SITE

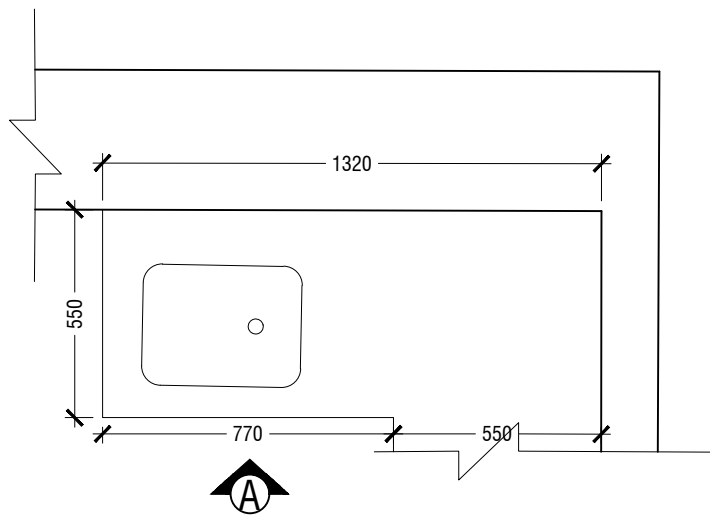

PLAN VIEW

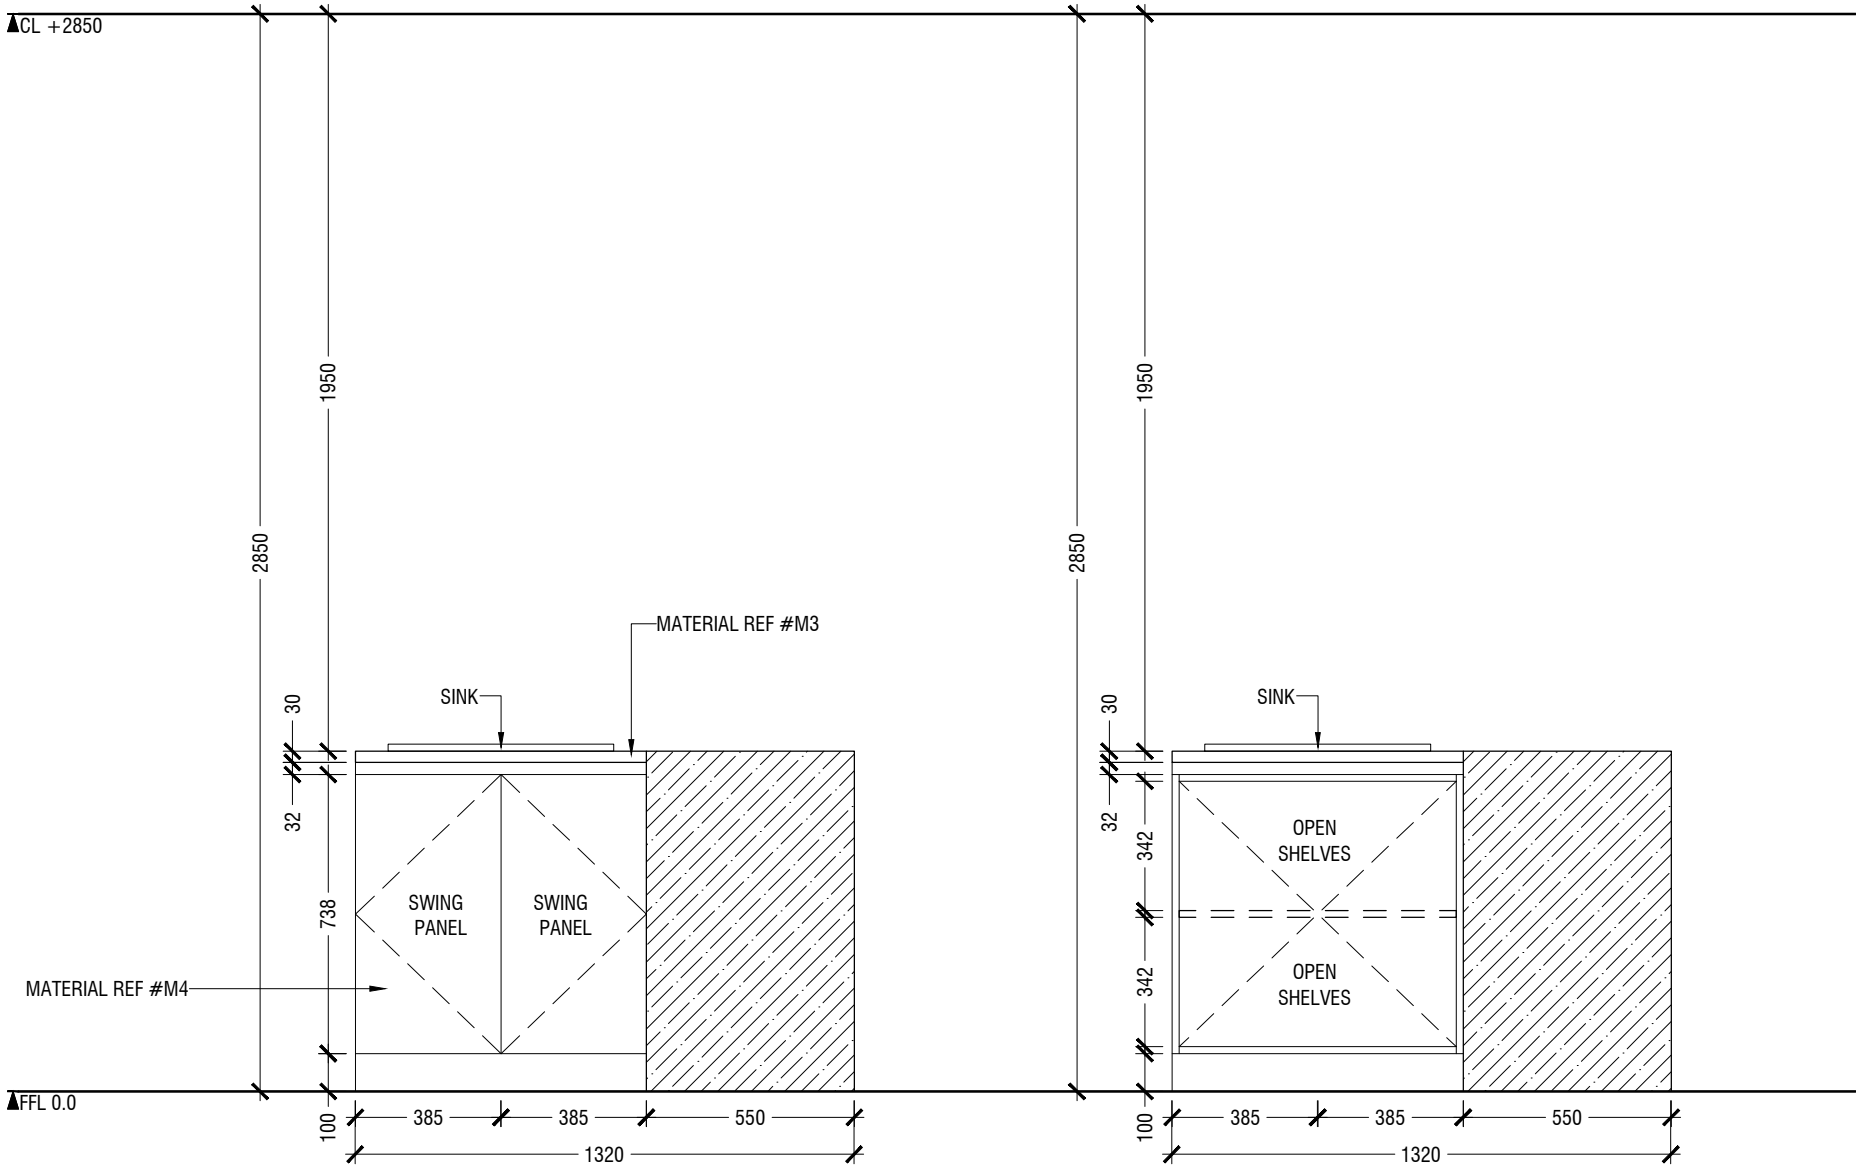

ELEVATION A

OPEN ELEVATION A

1.12 STORAGE CABINET
LOCATION "CATH LAB AREA"
SCALE 1:20

MACO
DESIGNS
Contact: 7989966, 7691671
Email: info@maco.mv

CLIENT:
IGMH

PROJECT:
IGMH CATH LAB
K. MALE

SCALE: AS GIVEN

DRWNG TITLE : AS GIVN

DATE: D015M07Y26

REVISION NO.: 00

FILE NAME:
\\DLINK-031BBD\Volume_1\MACO
PROJECTS\2026



WARNING:
– This drawing shall not be used for construction unless certified.
– Contractor to verify all dimensions of existing works on site before commencing any work or preparing shop drawings.
– Do not scale drawings, use written dimensions only.
– This drawing is to be read in conjunction with the specifications and conditions of contract.
– This drawing and design is copyright and no portion may be reproduced without the permission of the MACO architects

ID22

- NOTE
- CL = CEILING LINE
 - DCL = DROP CEILING LINE
 - FFL = FLOOR FINISH LINE

*FINAL DIMENSIONS ARE SUBJECT TO CHANGE DEPENDING ON CONTRACTORS ADJUSTMENTS ON SITE

*SLANTED WALL ALIGNMENT TO BE CONFIRMED ON SITE

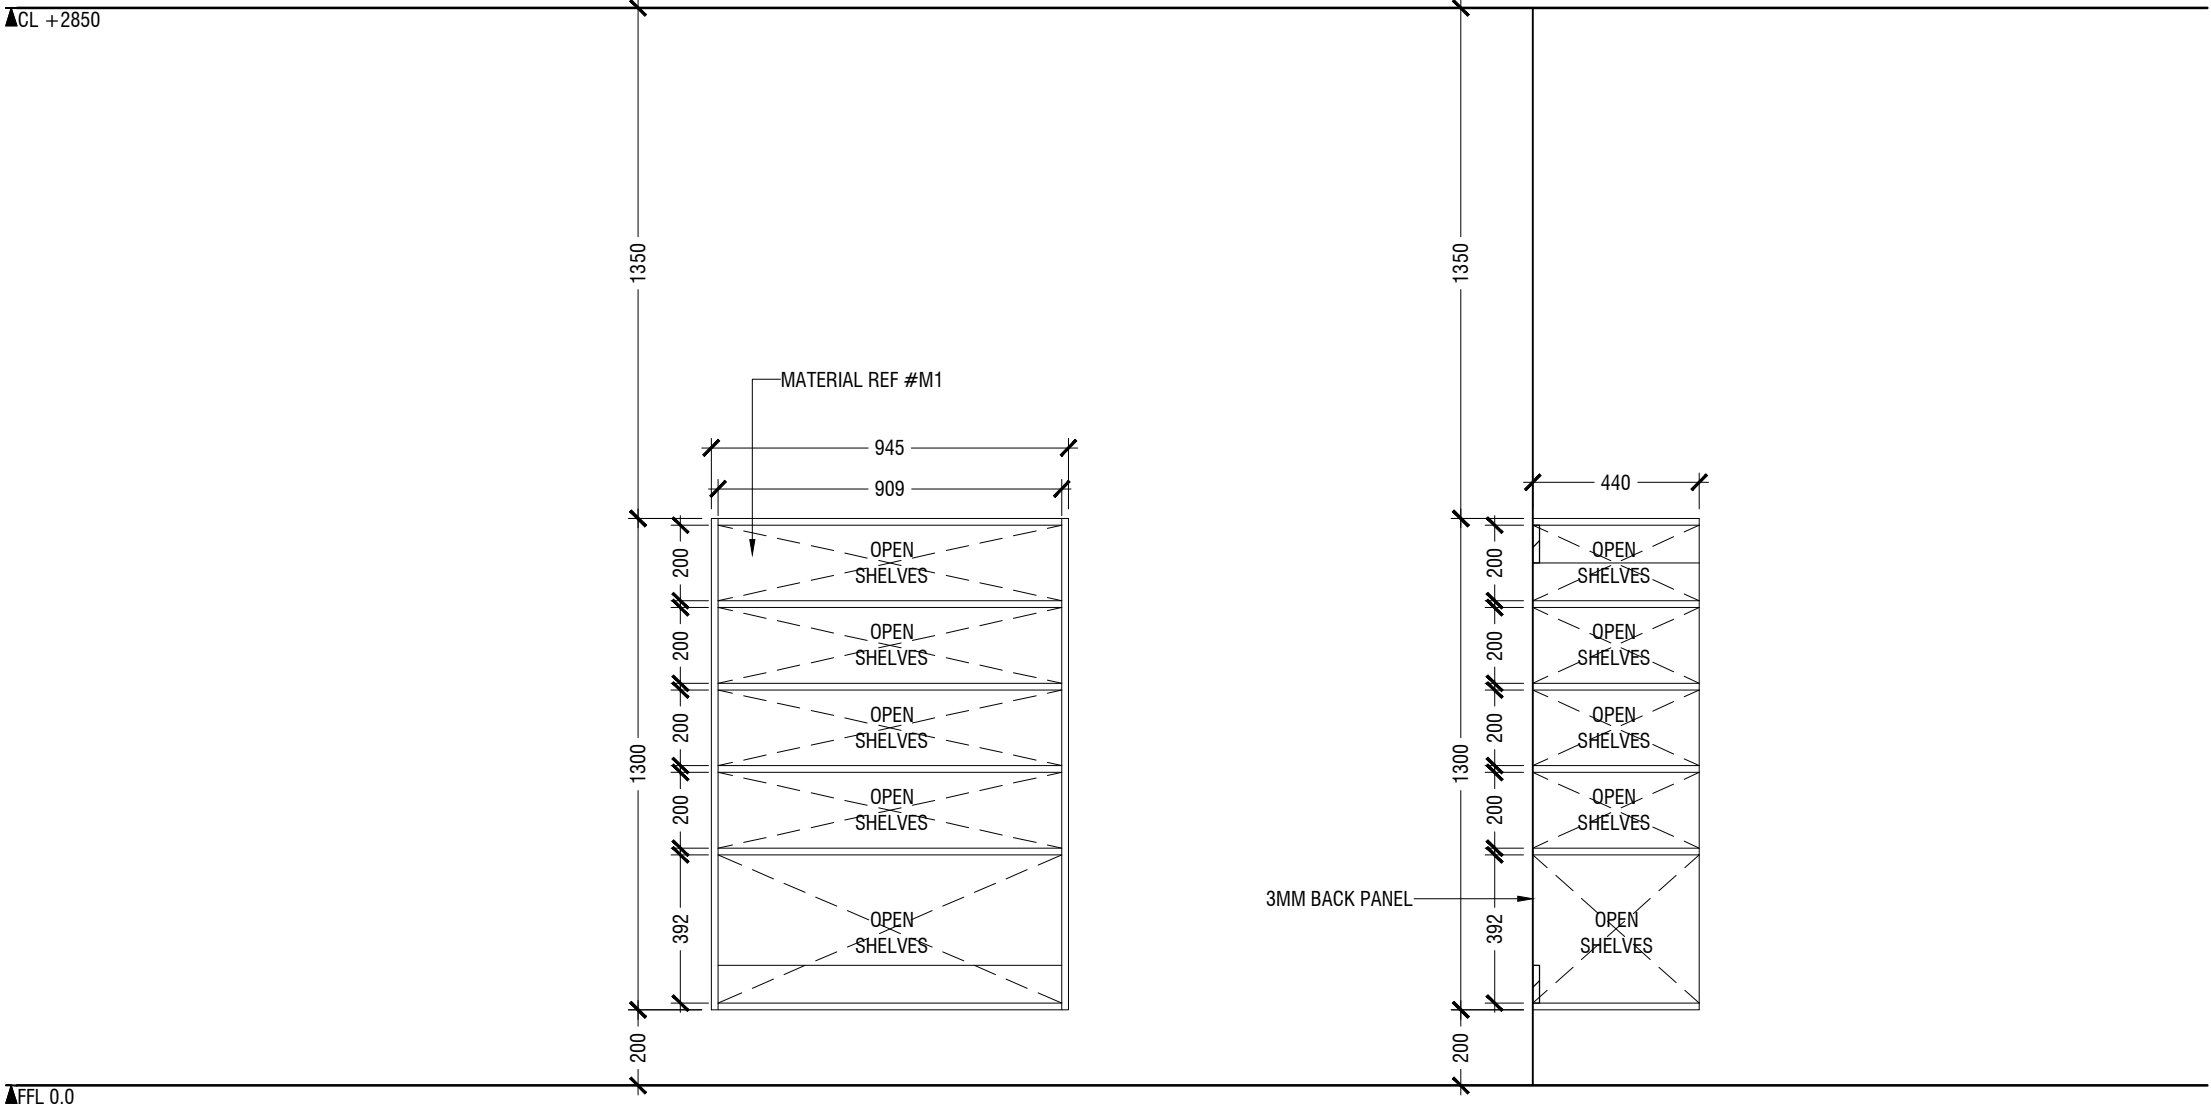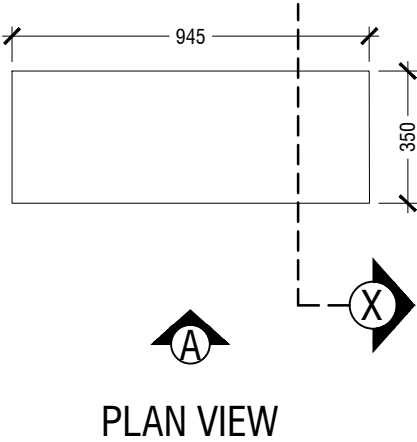

MACO
DESIGNS

Contact: 7989966, 7691671
Email: info@maco.mv

CLIENT:

IGMH

PROJECT:

IGMH CATH LAB
K. MALE

SCALE: AS GIVEN

DRWNG TITLE : AS GIVN

DATE: D015M07Y26

REVISION NO.: 00

FILE NAME:

\\DLINK-031BBD\Volume_1\MACO
PROJECTS\2026

WARNING:

- This drawing shall not be used for construction unless certified.
- Contractor to verify all dimensions of existing works on site before commencing any work or preparing shop drawings.
- Do not scale drawings, use written dimensions only.
- This drawing is to be read in conjunction with the specifications and conditions of contract.
- This drawing and design is copyright and no portion may be reproduced without the permission of the MACO architects




1.13 WALL MOUNTED CABINET
LOCATION "CATH LAB AREA"
SCALE 1:20

ID23

- NOTE
- CL = CEILING LINE
 - DCL = DROP CEILING LINE
 - FFL = FLOOR FINISH LINE

*FINAL DIMENSIONS ARE SUBJECT TO CHANGE DEPENDING ON CONTRACTORS ADJUSTMENTS ON SITE

*SLANTED WALL ALIGNMENT TO BE CONFIRMED ON SITE

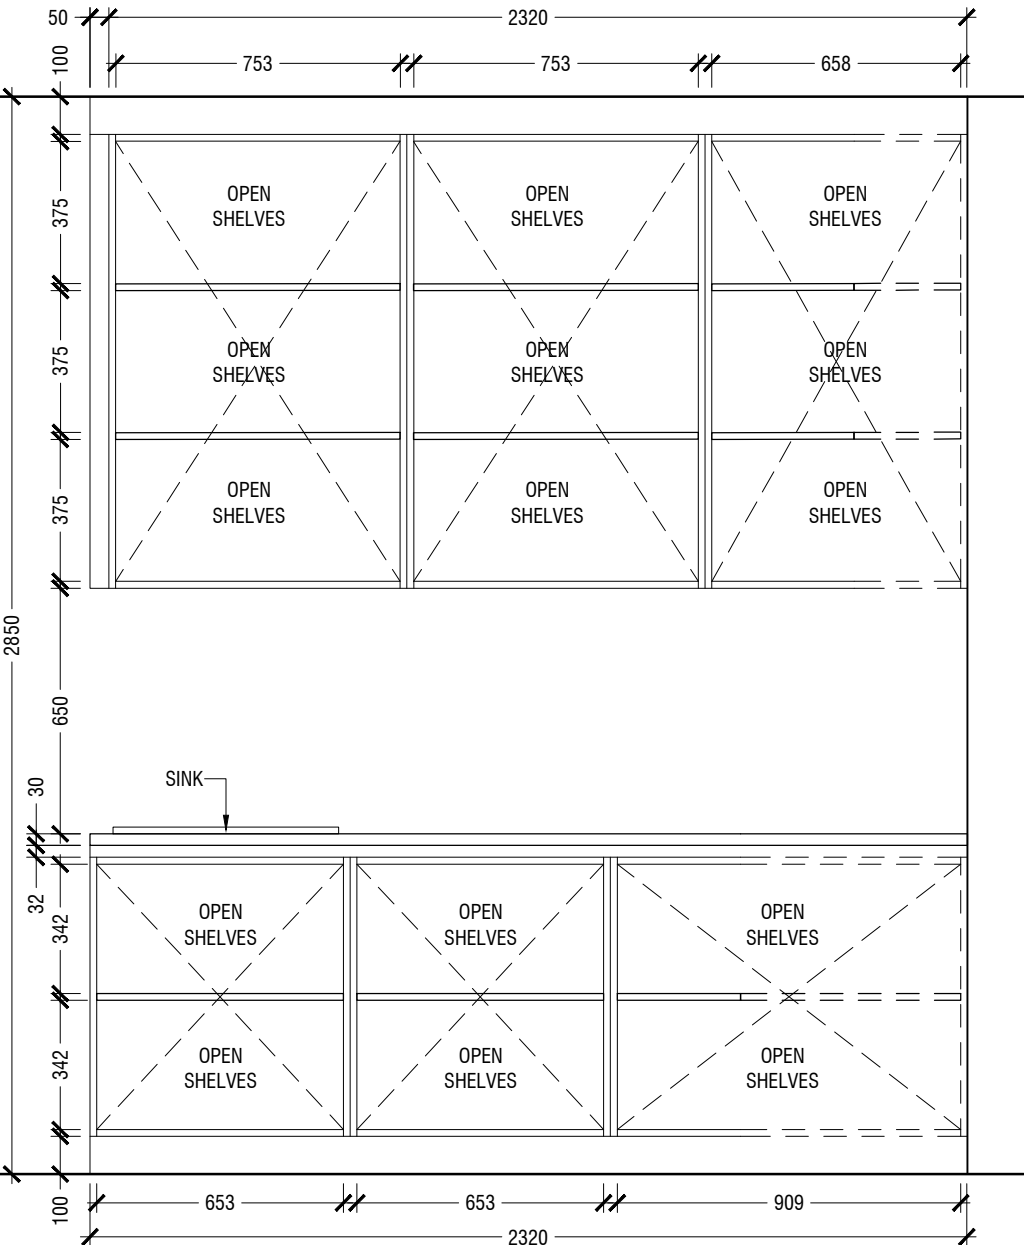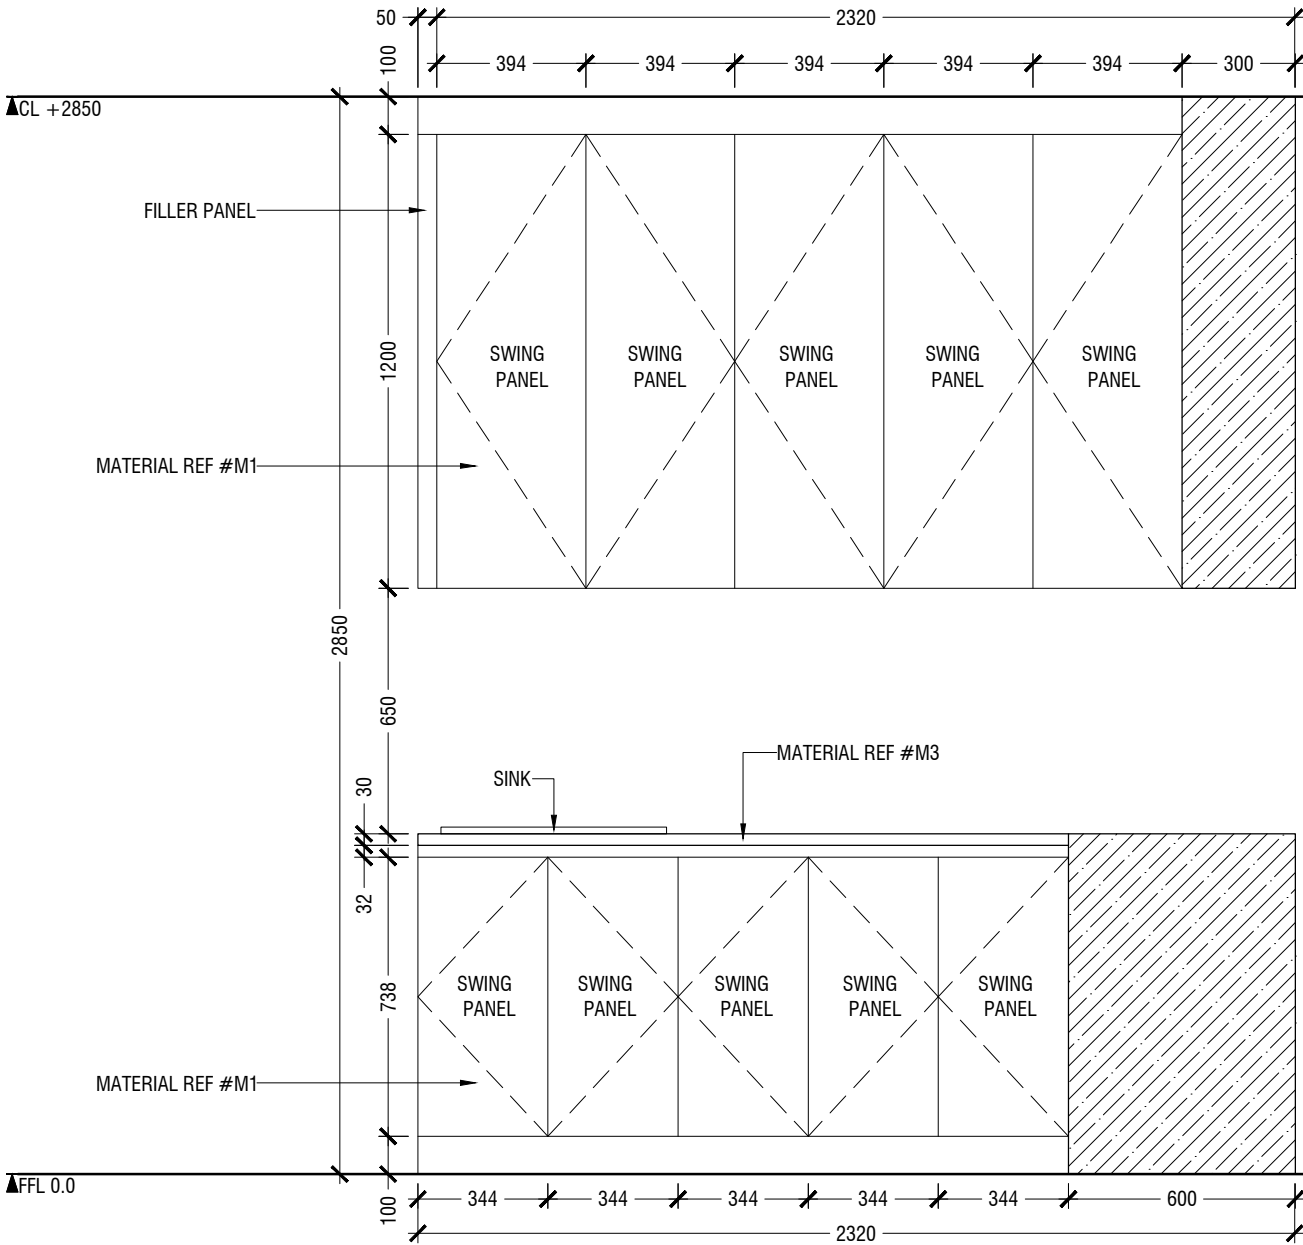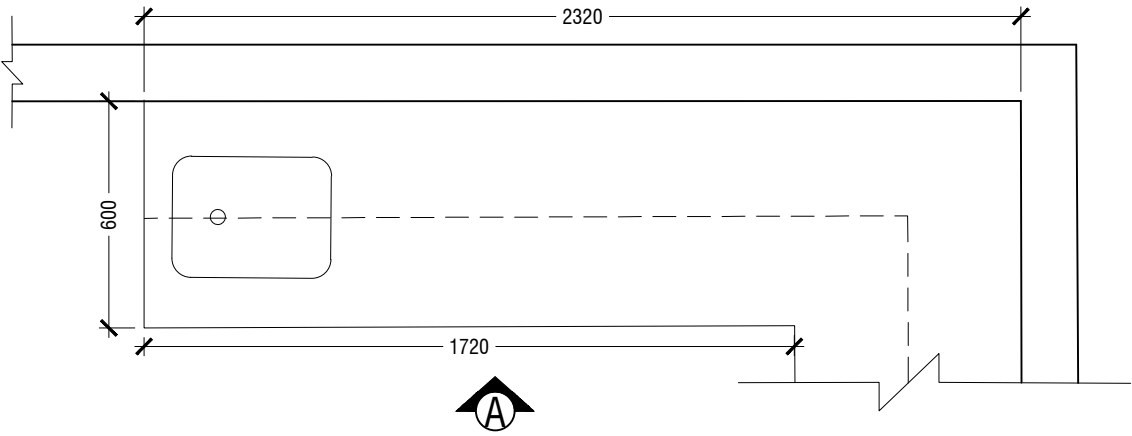

MACO
DESIGNS

Contact: 7989966, 7691671

Email: info@maco.mv

CLIENT:

IGMH

PROJECT:

IGMH CATH LAB

K. MALE

SCALE: AS GIVEN

DRWNG TITLE : AS GIVN

DATE: D015M07Y26

REVISION NO.: 00

FILE NAME:

\\DLINK-031BBD\Volume_1\MACO
PROJECTS\2026


WARNING:

- This drawing shall not be used for construction unless certified.
- Contractor to verify all dimensions of existing works on site before commencing any work or preparing shop drawings.
- Do not scale drawings, use written dimensions only.
- This drawing is to be read in conjunction with the specifications and conditions of contract.
- This drawing and design is copyright and no portion may be reproduced without the permission of the MACO architects


- NOTE
- CL = CEILING LINE
 - DCL = DROP CEILING LINE
 - FFL = FLOOR FINISH LINE

*FINAL DIMENSIONS ARE SUBJECT TO CHANGE DEPENDING ON CONTRACTORS ADJUSTMENTS ON SITE

*SLANTED WALL ALIGNMENT TO BE CONFIRMED ON SITE

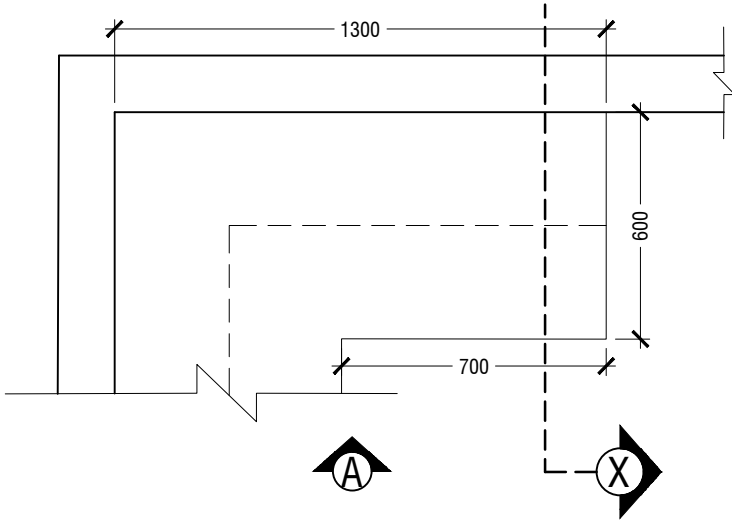

PLAN VIEW

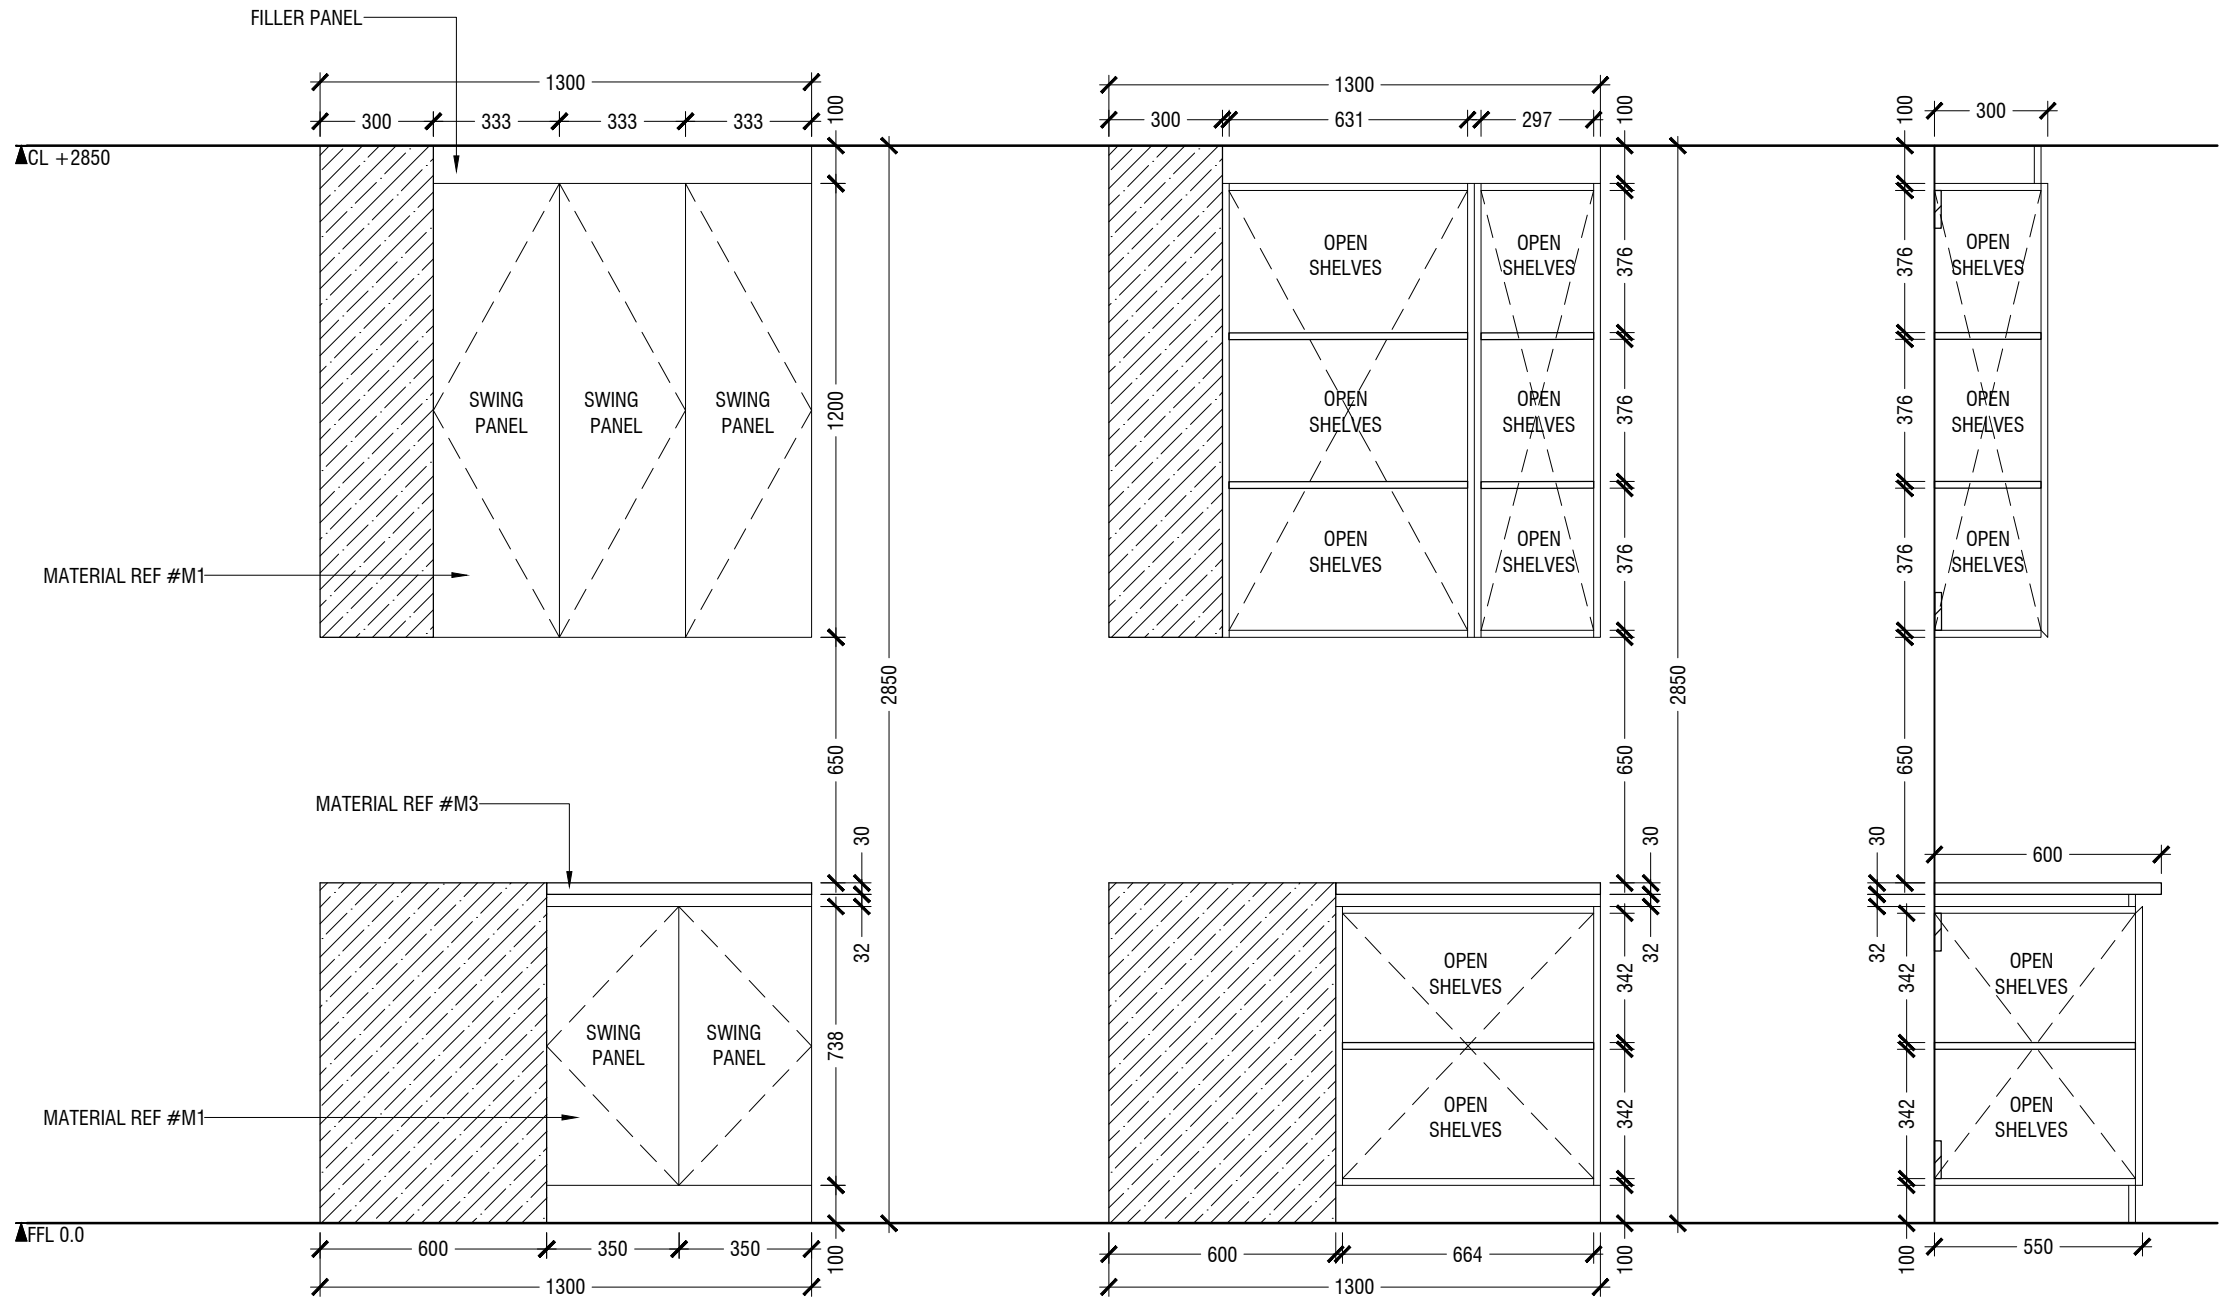

ELEVATION B

OPEN ELEVATION B

SECTION X

1.14 DIRTY UTILITY COUNTER
LOCATION "CATH LAB AREA"
SCALE 1:20

MACO
DESIGNS
Contact: 7989966, 7691671
Email: info@maco.mv

CLIENT:
IGMH

PROJECT:
IGMH CATH LAB
K. MALE

SCALE: AS GIVEN

DRWNG TITLE : AS GIVN

DATE: D015M07Y26

REVISION NO.: 00

FILE NAME:
\\DLINK-031BBD\Volume_1\MACO
PROJECTS\2026


WARNING:
- This drawing shall not be used for construction unless certified.
- Contractor to verify all dimensions of existing works on site before commencing any work or preparing shop drawings.
- Do not scale drawings, use written dimensions only.
- This drawing is to be read in conjunction with the specifications and conditions of contract.
- This drawing and design is copyright and no portion may be reproduced without the permission of the MACO architects

ID25

- NOTE
- CL = CEILING LINE
 - DCL = DROP CEILING LINE
 - FFL = FLOOR FINISH LINE

*FINAL DIMENSIONS ARE SUBJECT TO CHANGE DEPENDING ON CONTRACTORS ADJUSTMENTS ON SITE

*SLANTED WALL ALIGNMENT TO BE CONFIRMED ON SITE

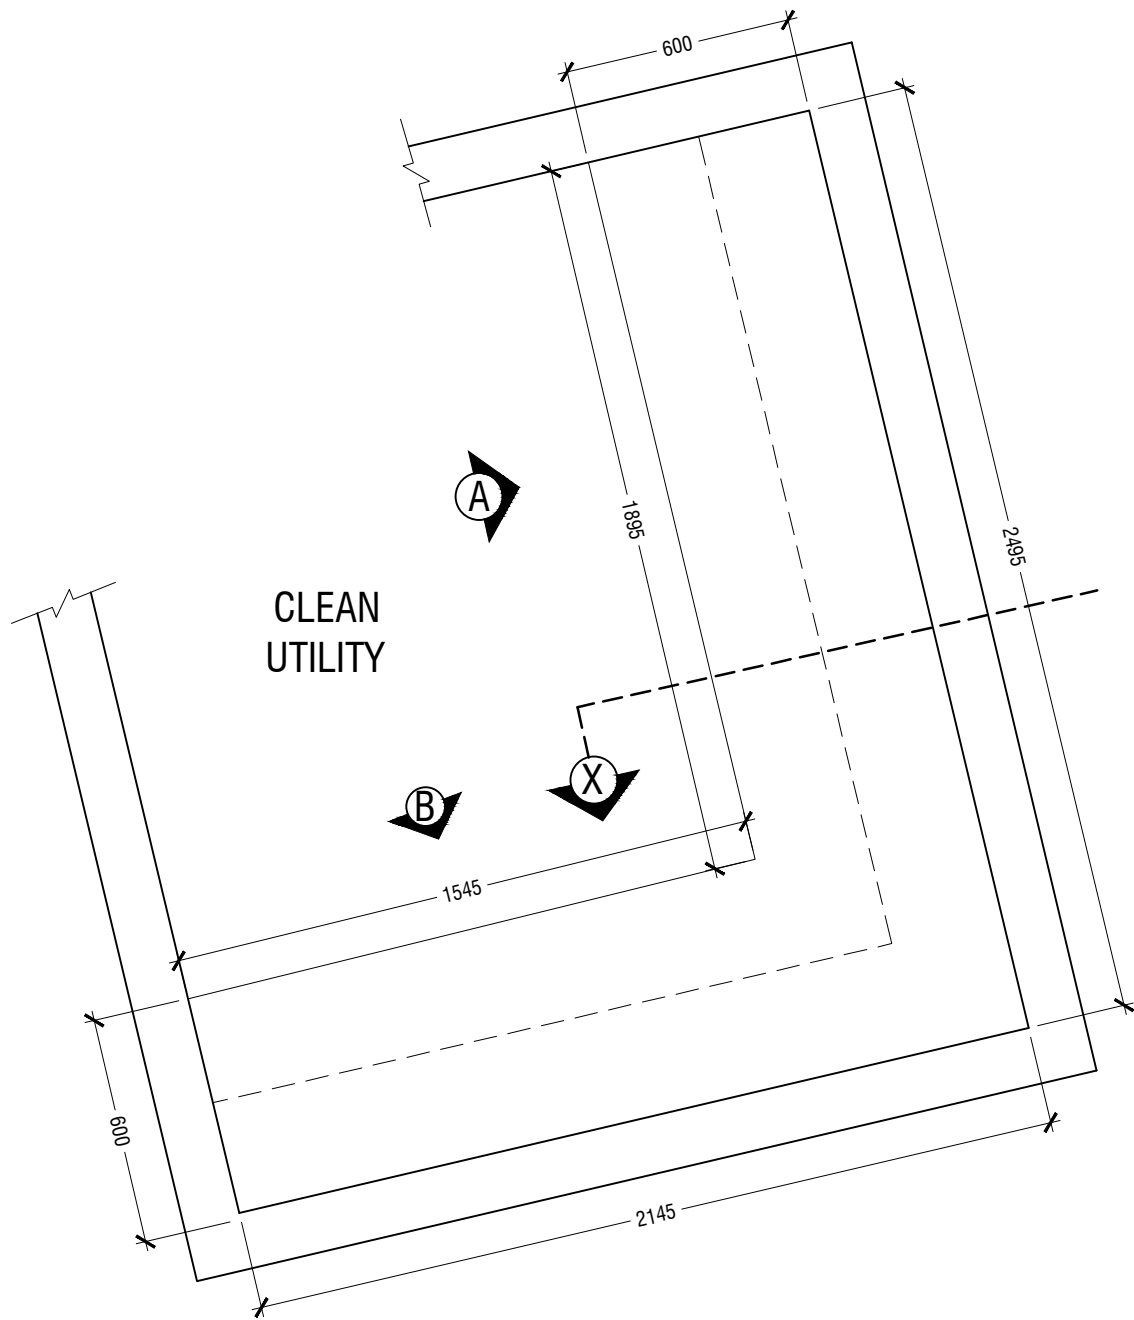

PLAN VIEW

1.15 CLEAN UTILITY COUNTER
LOCATION "CATH LAB AREA"
SCALE 1:20

MACO
DESIGNS
Contact: 7989966, 7691671
Email: info@maco.mv

CLIENT:
IGMH

PROJECT:
IGMH CATH LAB
K. MALE

SCALE: AS GIVEN

DRWNG TITLE : AS GIVN

DATE: D015M07Y26

REVISION NO.: 00

FILE NAME:
\\DLINK-031BBD\Volume_1\MACO
PROJECTS\2026



WARNING:
– This drawing shall not be used for construction unless certified.
– Contractor to verify all dimensions of existing works on site before commencing any work or preparing shop drawings.
– Do not scale drawings, use written dimensions only.
– This drawing is to be read in conjunction with the specifications and conditions of contract.
– This drawing and design is copyright and no portion may be reproduced without the permission of the MACO architects

ID26

- NOTE
- CL = CEILING LINE
 - DCL = DROP CEILING LINE
 - FFL = FLOOR FINISH LINE

*FINAL DIMENSIONS ARE SUBJECT TO CHANGE DEPENDING ON CONTRACTORS ADJUSTMENTS ON SITE

*SLANTED WALL ALIGNMENT TO BE CONFIRMED ON SITE

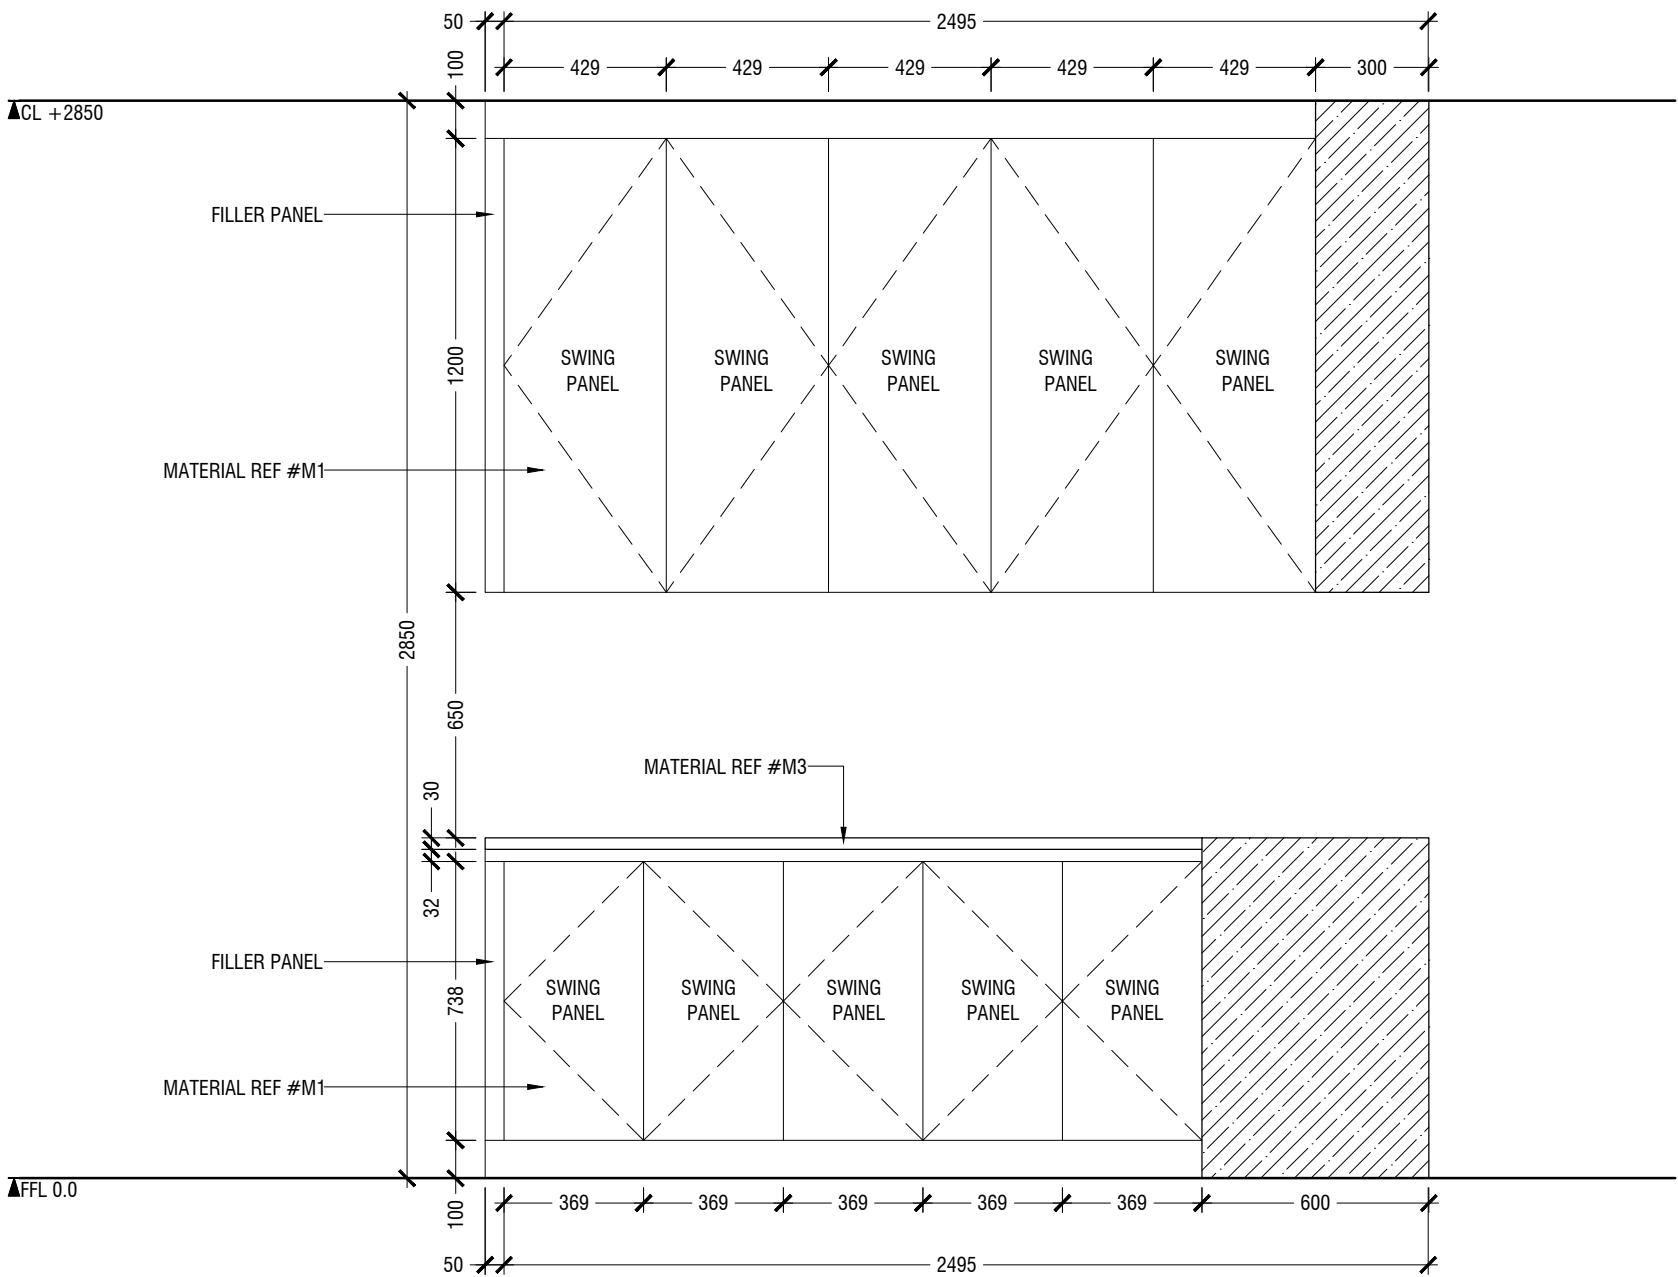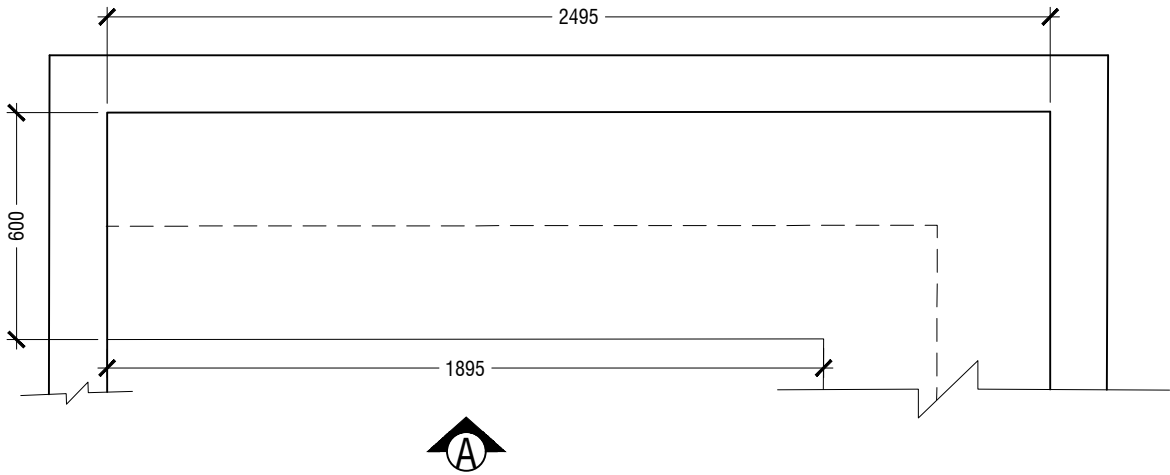

1.15 CLEAN UTILITY COUNTER
LOCATION "CATH LAB AREA"
SCALE 1:20

MACO
DESIGNS
Contact: 7989966, 7691671
Email: info@maco.mv

CLIENT:
IGMH

PROJECT:
IGMH CATH LAB
K. MALE

SCALE: AS GIVEN

DRWNG TITLE : AS GIVN

DATE: D015M07Y26

REVISION NO.: 00

FILE NAME:
\\DLINK-031BBD\Volume_1\MACO
PROJECTS\2026



WARNING:
- This drawing shall not be used for construction unless certified.
- Contractor to verify all dimensions of existing works on site before commencing any work or preparing shop drawings.
- Do not scale drawings, use written dimensions only.
- This drawing is to be read in conjunction with the specifications and conditions of contract.
- This drawing and design is copyright and no portion may be reproduced without the permission of the MACO architects

ID27

- NOTE
- CL = CEILING LINE
 - DCL = DROP CEILING LINE
 - FFL = FLOOR FINISH LINE

*FINAL DIMENSIONS ARE SUBJECT TO CHANGE DEPENDING ON CONTRACTORS ADJUSTMENTS ON SITE

*SLANTED WALL ALIGNMENT TO BE CONFIRMED ON SITE

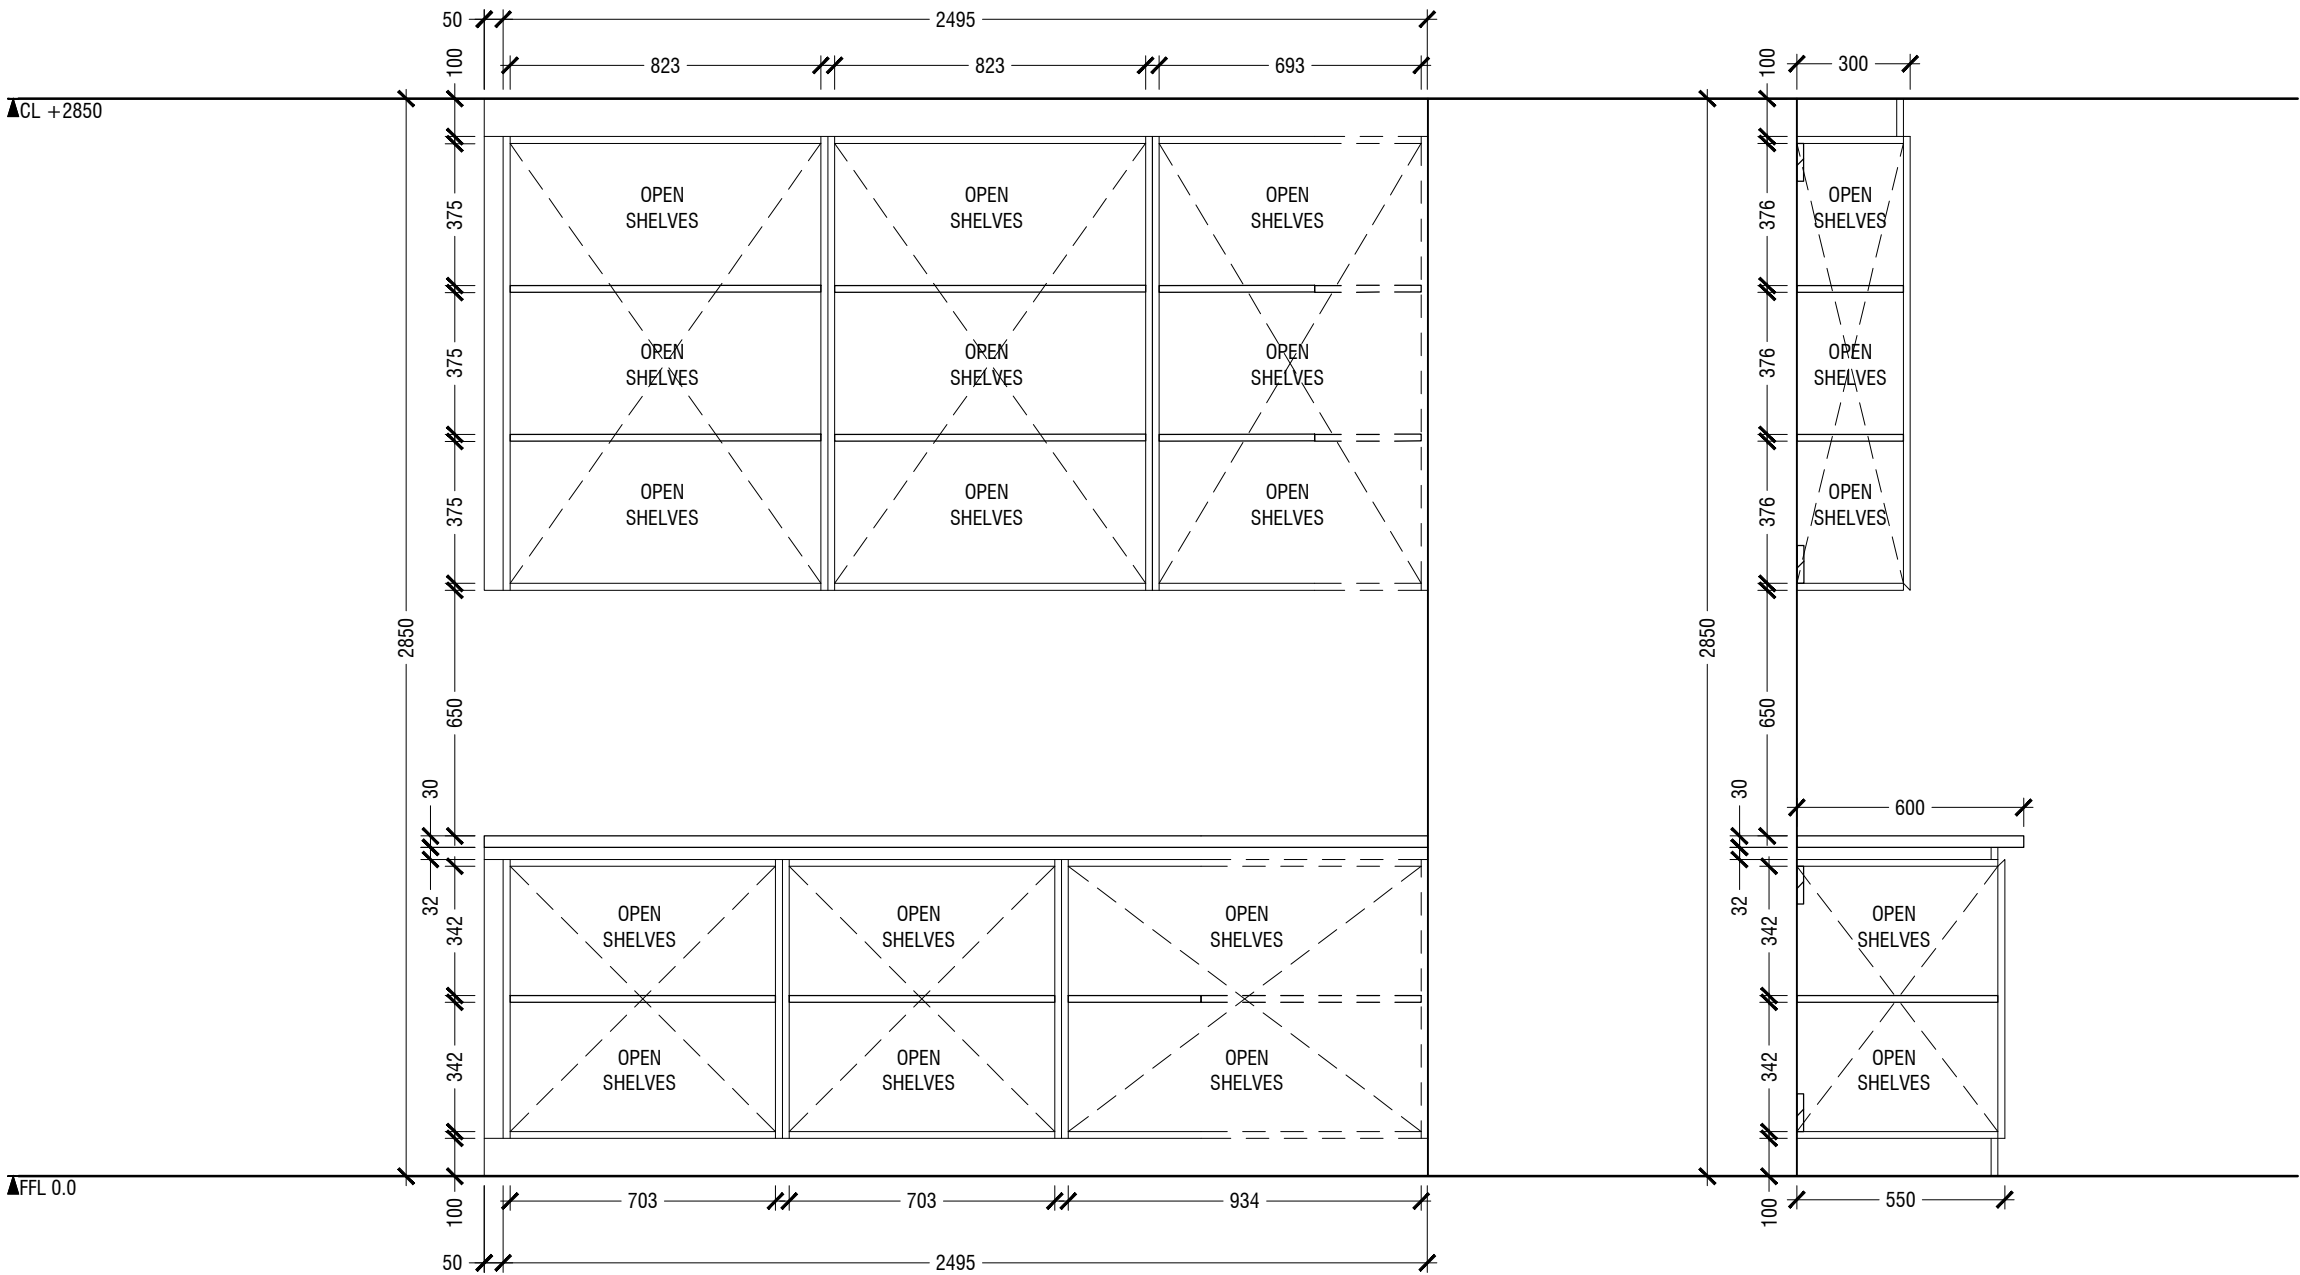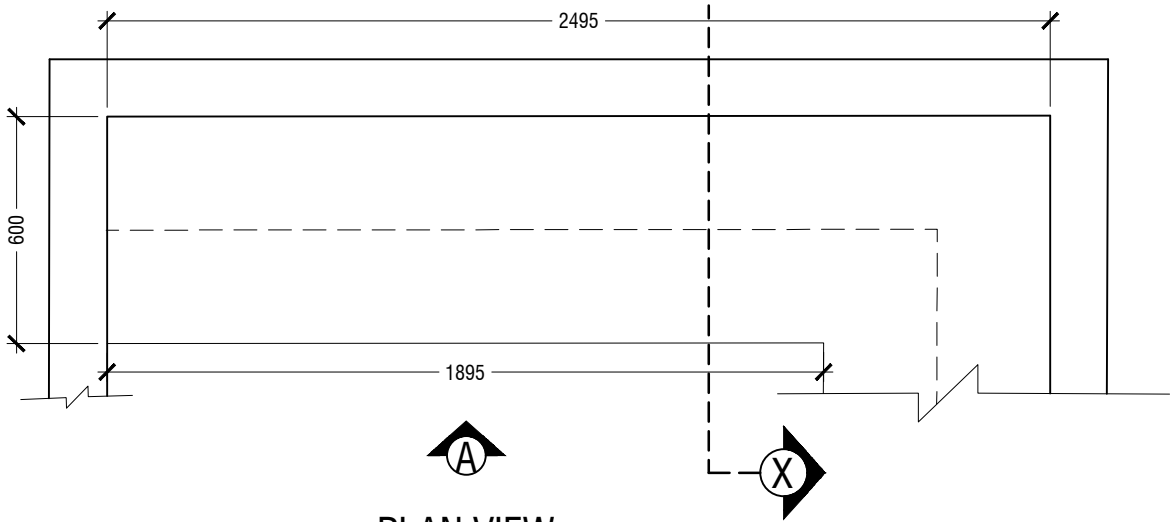

MACO
DESIGNS
Contact: 7989966, 7691671
Email: info@maco.mv

CLIENT:
IGMH

PROJECT:
IGMH CATH LAB
K. MALE

SCALE: AS GIVEN

DRWNG TITLE : AS GIVN

DATE: D015M07Y26

REVISION NO.: 00

FILE NAME:
\\DLINK-031BBD\Volume_1\MACO PROJECTS\2026

WARNING:

- This drawing shall not be used for construction unless certified.
- Contractor to verify all dimensions of existing works on site before commencing any work or preparing shop drawings.
- Do not scale drawings, use written dimensions only.
- This drawing is to be read in conjunction with the specifications and conditions of contract.
- This drawing and design is copyright and no portion may be reproduced without the permission of the MACO architects


ID28

1.15 CLEAN UTILITY COUNTER
LOCATION "CATH LAB AREA"
SCALE 1:20


- NOTE
- CL = CEILING LINE
 - DCL = DROP CEILING LINE
 - FFL = FLOOR FINISH LINE

*FINAL DIMENSIONS ARE SUBJECT TO CHANGE DEPENDING ON CONTRACTORS ADJUSTMENTS ON SITE

*SLANTED WALL ALIGNMENT TO BE CONFIRMED ON SITE

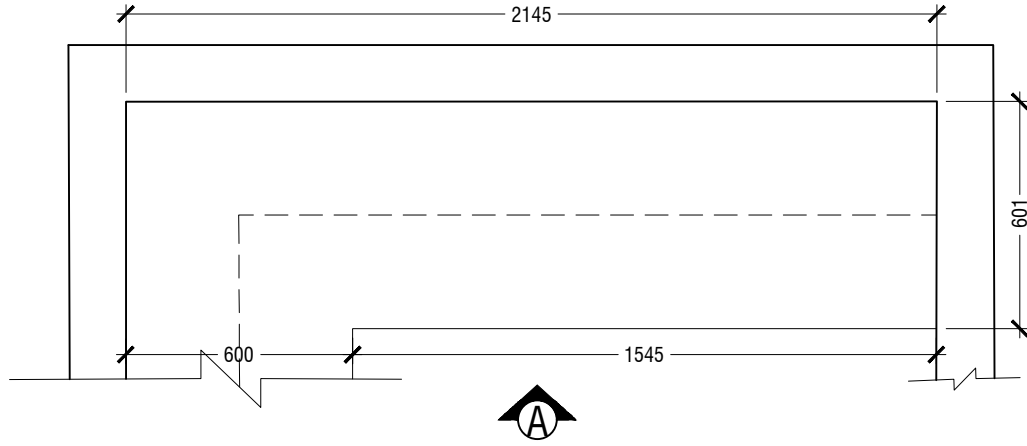

PLAN VIEW

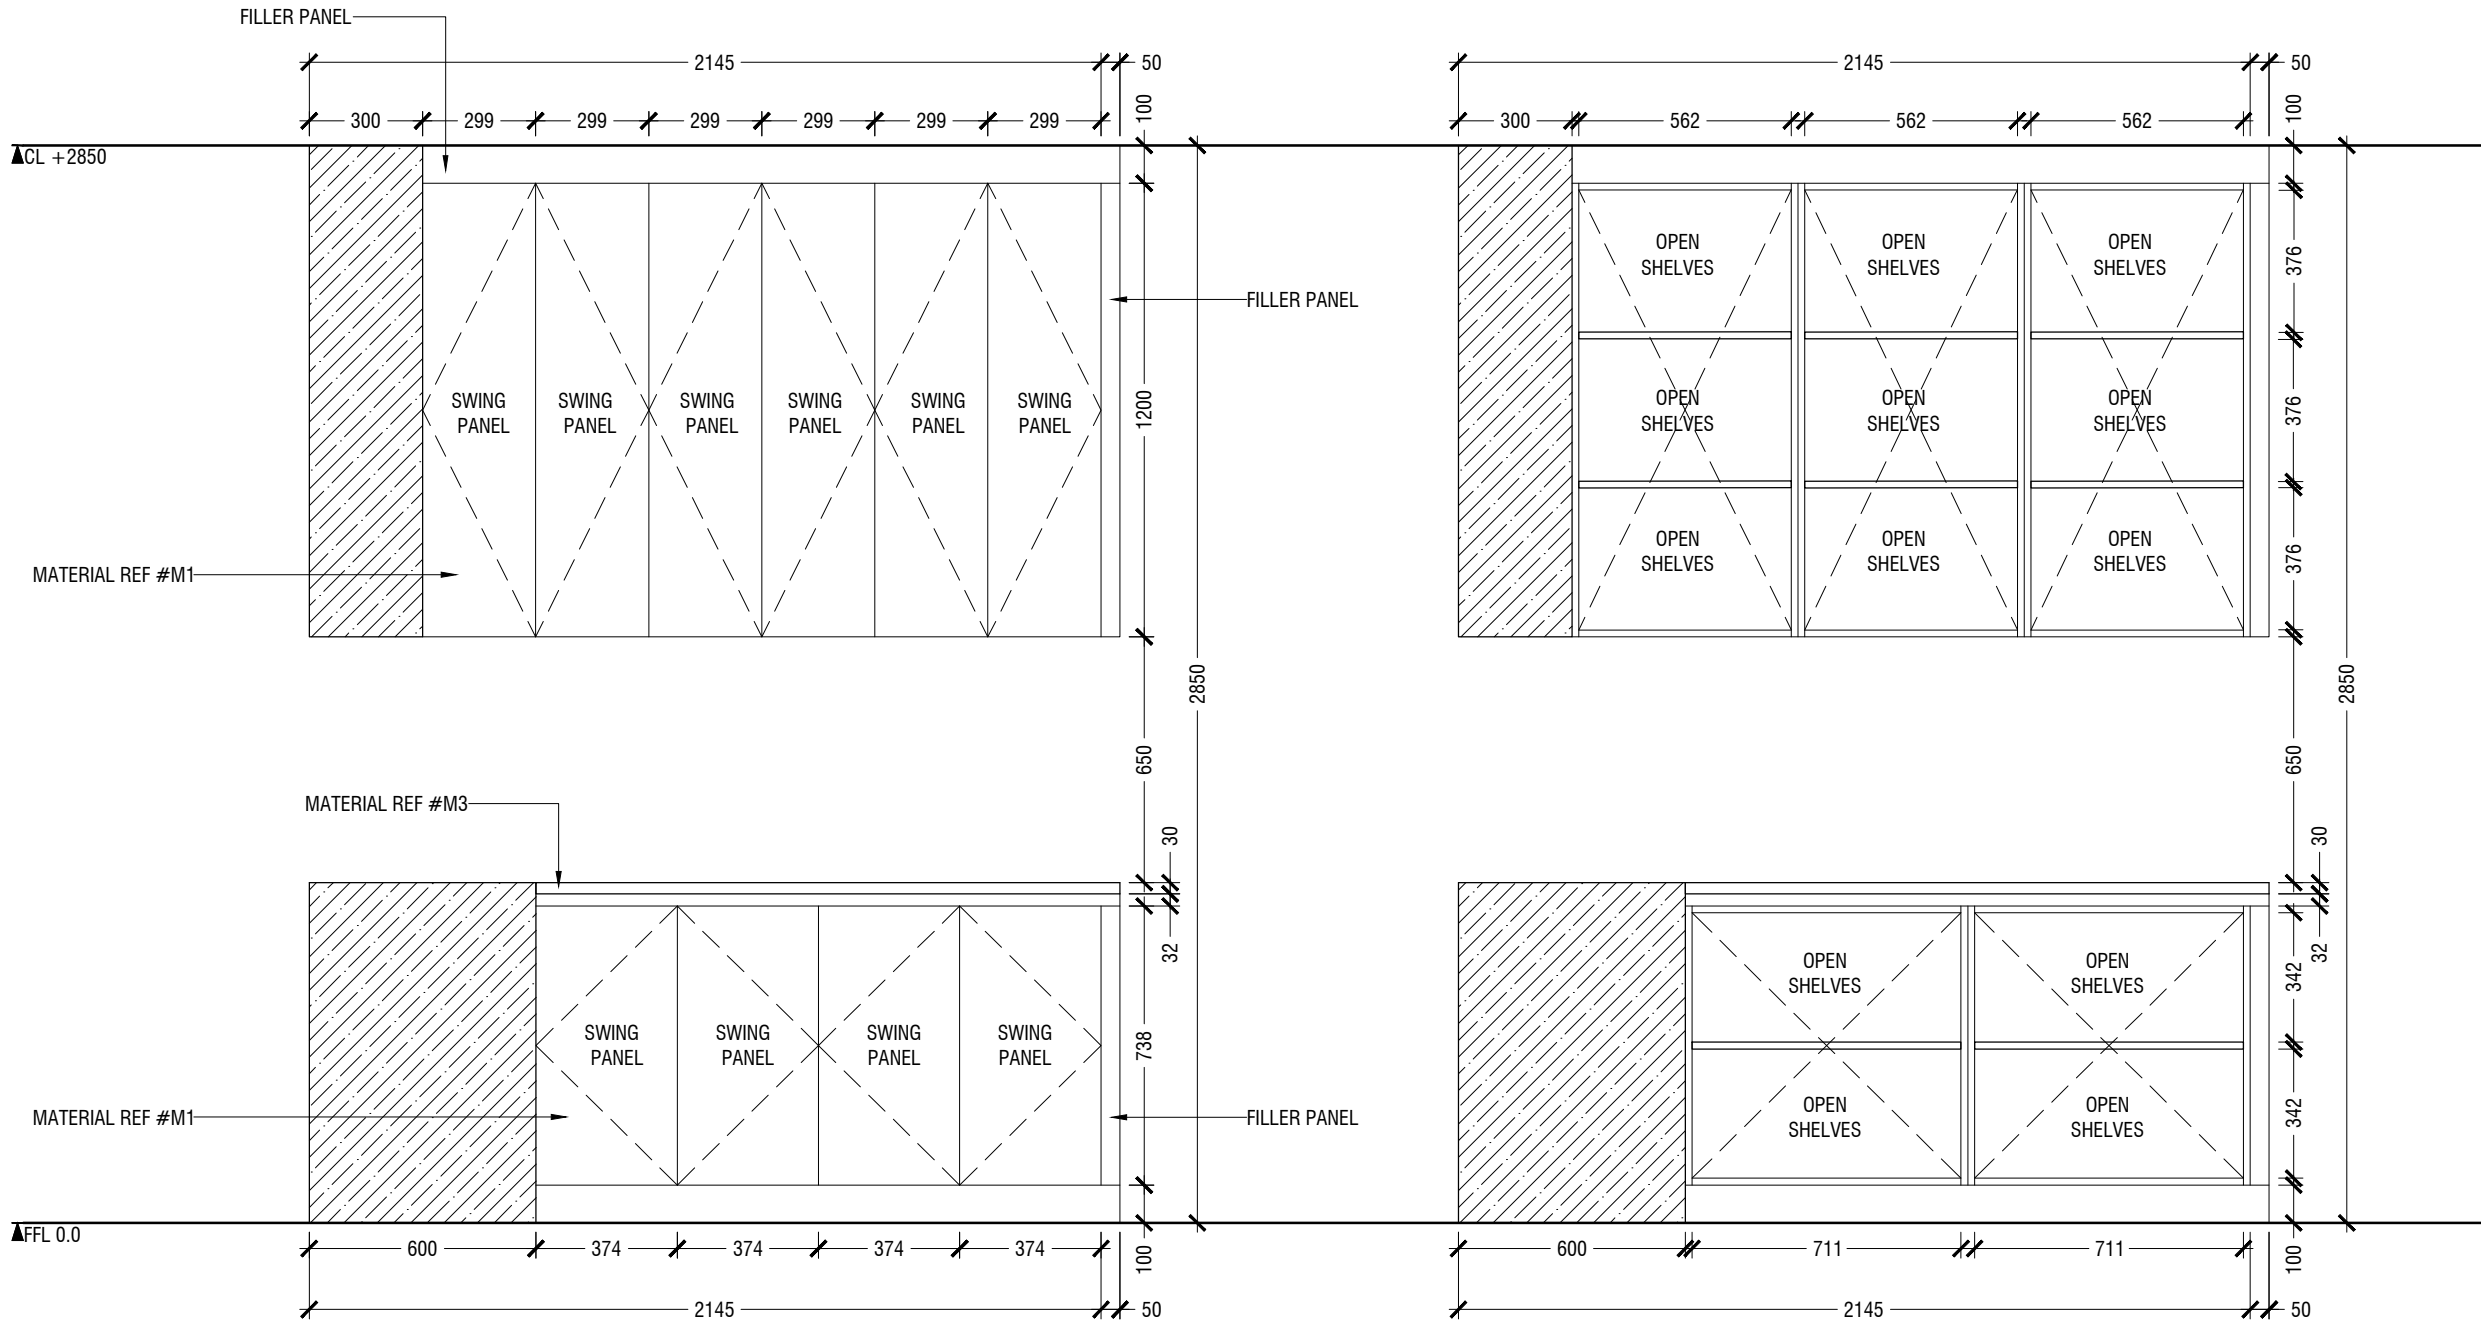

ELEVATION B

OPEN ELEVATION B

1.15 CLEAN UTILITY COUNTER
LOCATION "CATH LAB AREA"
SCALE 1:20

MACO
DESIGNS

Contact: 7989966, 7691671

Email: info@maco.mv

CLIENT:

IGMH

PROJECT:

IGMH CATH LAB

K. MALE

SCALE: AS GIVEN

DRWNG TITLE : AS GIVN

DATE: D015M07Y26

REVISION NO.: 00

FILE NAME:

\\DLINK-031BBD\Volume_1\MACO
PROJECTS\2026

WARNING:



- This drawing shall not be used for construction unless certified.
- Contractor to verify all dimensions of existing works on site before commencing any work or preparing shop drawings.
- Do not scale drawings, use written dimensions only.
- This drawing is to be read in conjunction with the specifications and conditions of contract.
- This drawing and design is copyright and no portion may be reproduced without the permission of the MACO architects

ID29

- NOTE
- CL = CEILING LINE
 - DCL = DROP CEILING LINE
 - FFL = FLOOR FINISH LINE

*FINAL DIMENSIONS ARE SUBJECT TO CHANGE DEPENDING ON CONTRACTORS ADJUSTMENTS ON SITE

*SLANTED WALL ALIGNMENT TO BE CONFIRMED ON SITE

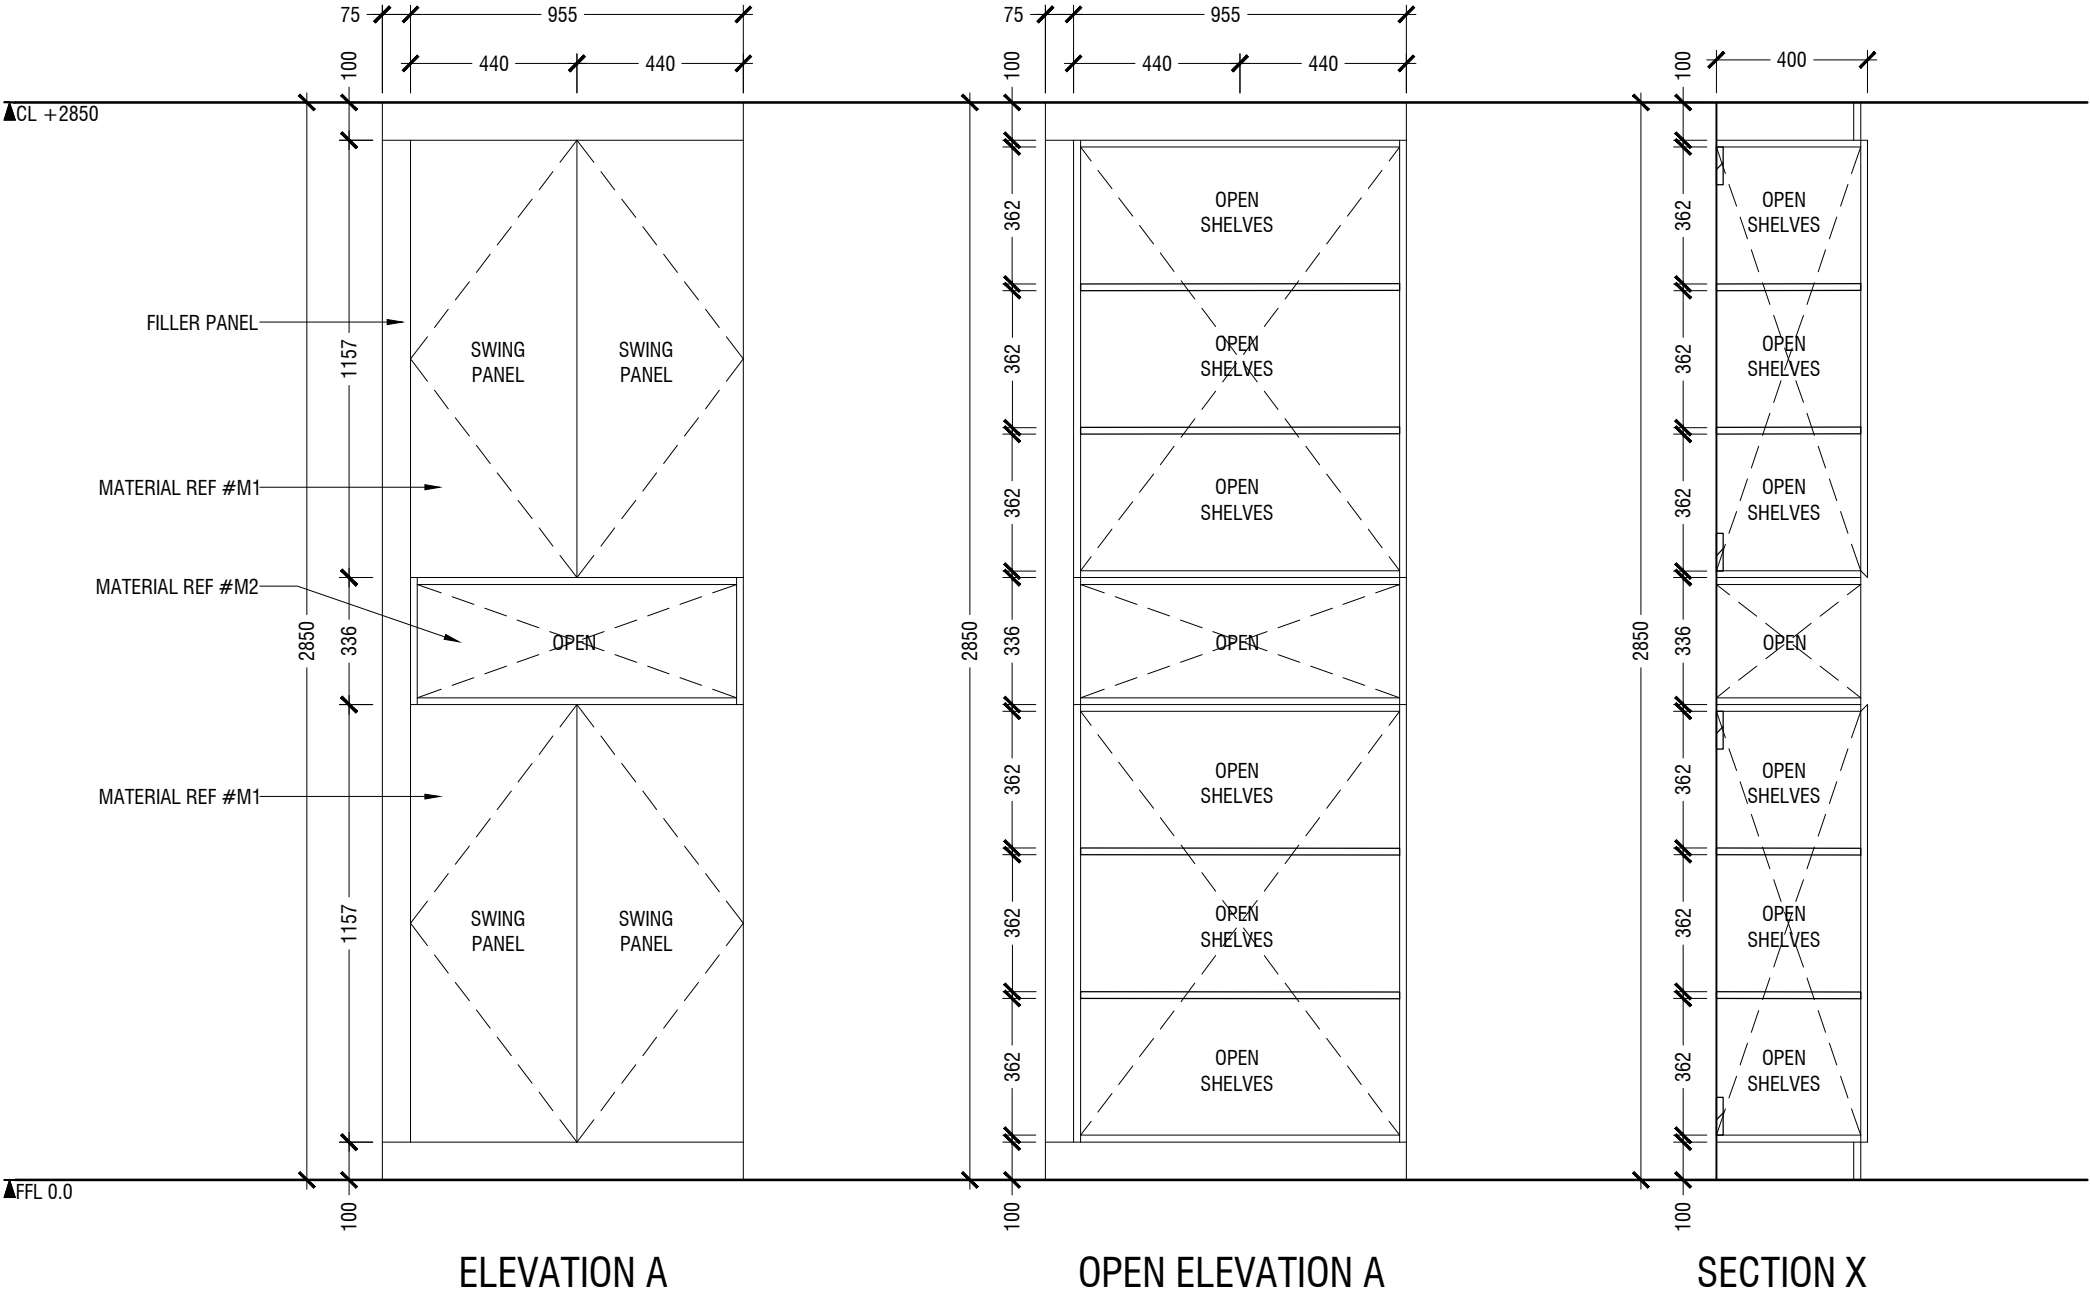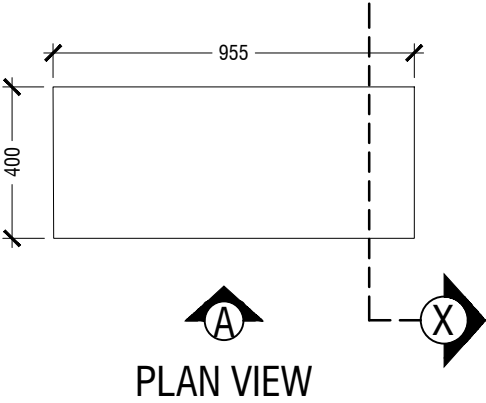

MACO
DESIGNS

Contact: 7989966, 7691671

Email: info@maco.mv

CLIENT:

IGMH

PROJECT:

IGMH CATH LAB

K. MALE

SCALE: AS GIVEN

DRWNG TITLE : AS GIVN

DATE: D015M07Y26

REVISION NO.: 00


FILE NAME:

\\DLINK-031BBD\\Volume_1\\MACO PROJECTS\\2026

WARNING:


- This drawing shall not be used for construction unless certified.
- Contractor to verify all dimensions of existing works on site before commencing any work or preparing shop drawings.
- Do not scale drawings, use written dimensions only.
- This drawing is to be read in conjunction with the specifications and conditions of contract.
- This drawing and design is copyright and no portion may be reproduced without the permission of the MACO architects

- NOTE
- CL = CEILING LINE
 - DCL = DROP CEILING LINE
 - FFL = FLOOR FINISH LINE

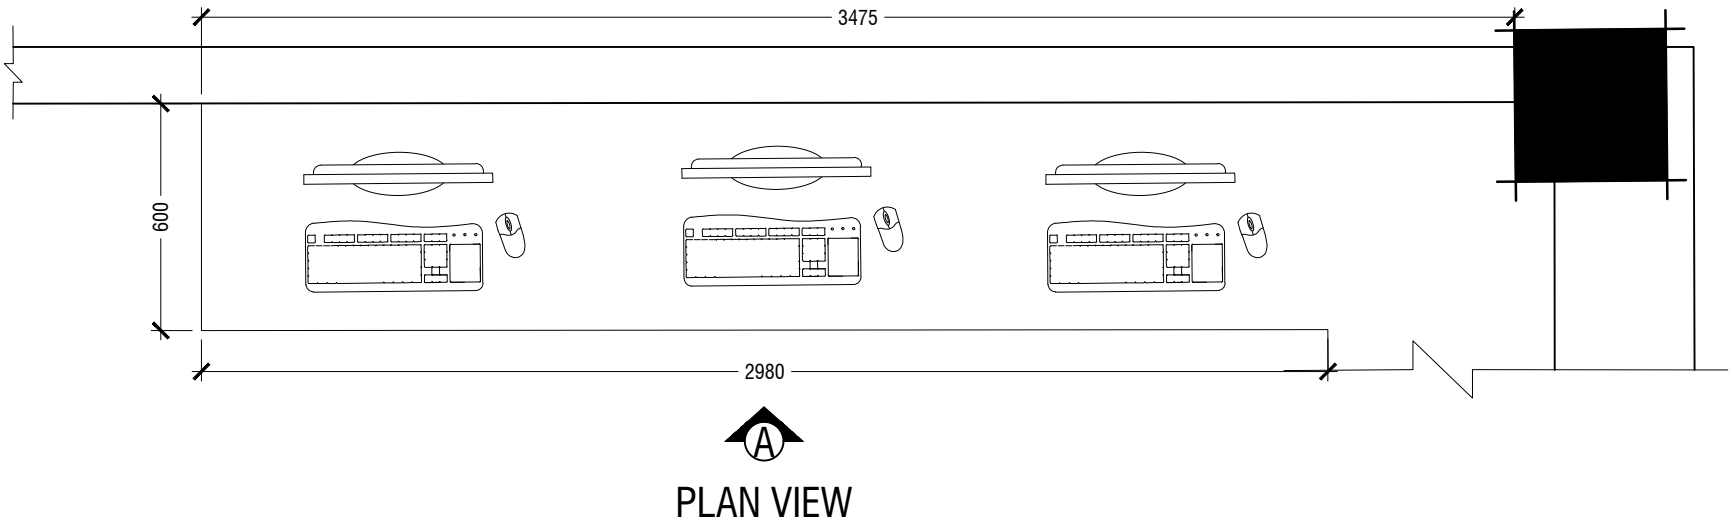

*FINAL DIMENSIONS ARE SUBJECT TO CHANGE DEPENDING ON CONTRACTORS ADJUSTMENTS ON SITE

*SLANTED WALL ALIGNMENT TO BE CONFIRMED ON SITE

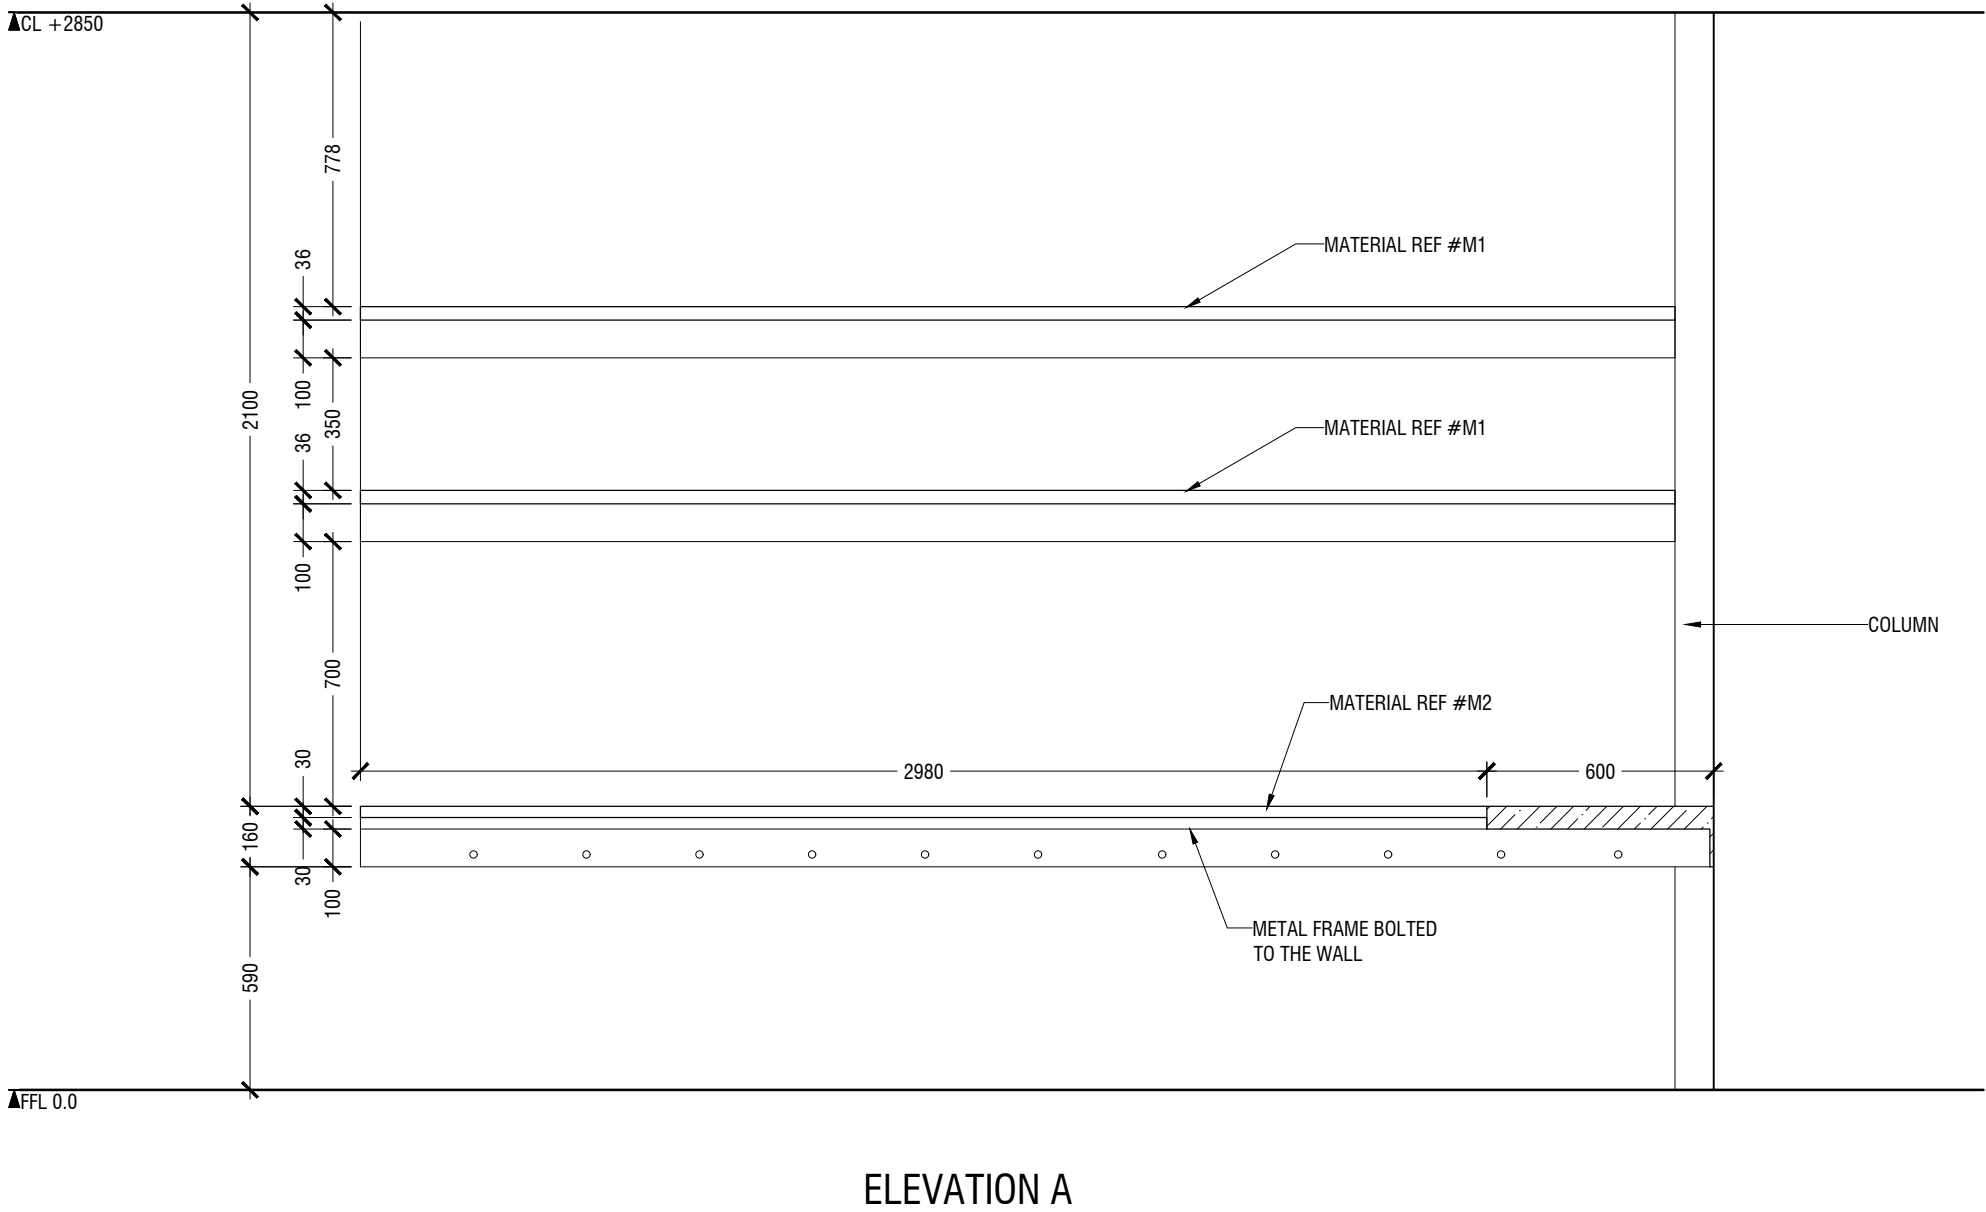

MACO
DESIGNS

Contact: 7989966, 7691671
Email: info@maco.mv

CLIENT:
IGMH

PROJECT:
IGMH CATH LAB
K. MALE

SCALE: AS GIVEN

DRWNG TITLE : AS GIVN

DATE: D015M07Y26

REVISION NO.: 00

FILE NAME:
\\DLINK-031BBD\Volume_1\MACO
PROJECTS\2026

WARNING:

- This drawing shall not be used for construction unless certified.
- Contractor to verify all dimensions of existing works on site before commencing any work or preparing shop drawings.
- Do not scale drawings, use written dimensions only.
- This drawing is to be read in conjunction with the specifications and conditions of contract.
- This drawing and design is copyright and no portion may be reproduced without the permission of the MACO architects



1.17 WORKSTATION
LOCATION "DOCTORS LOUNGE"
SCALE 1:20

ID31

- NOTE
- CL = CEILING LINE
 - DCL = DROP CEILING LINE
 - FFL = FLOOR FINISH LINE

*FINAL DIMENSIONS ARE SUBJECT TO CHANGE DEPENDING ON CONTRACTORS ADJUSTMENTS ON SITE

*SLANTED WALL ALIGNMENT TO BE CONFIRMED ON SITE

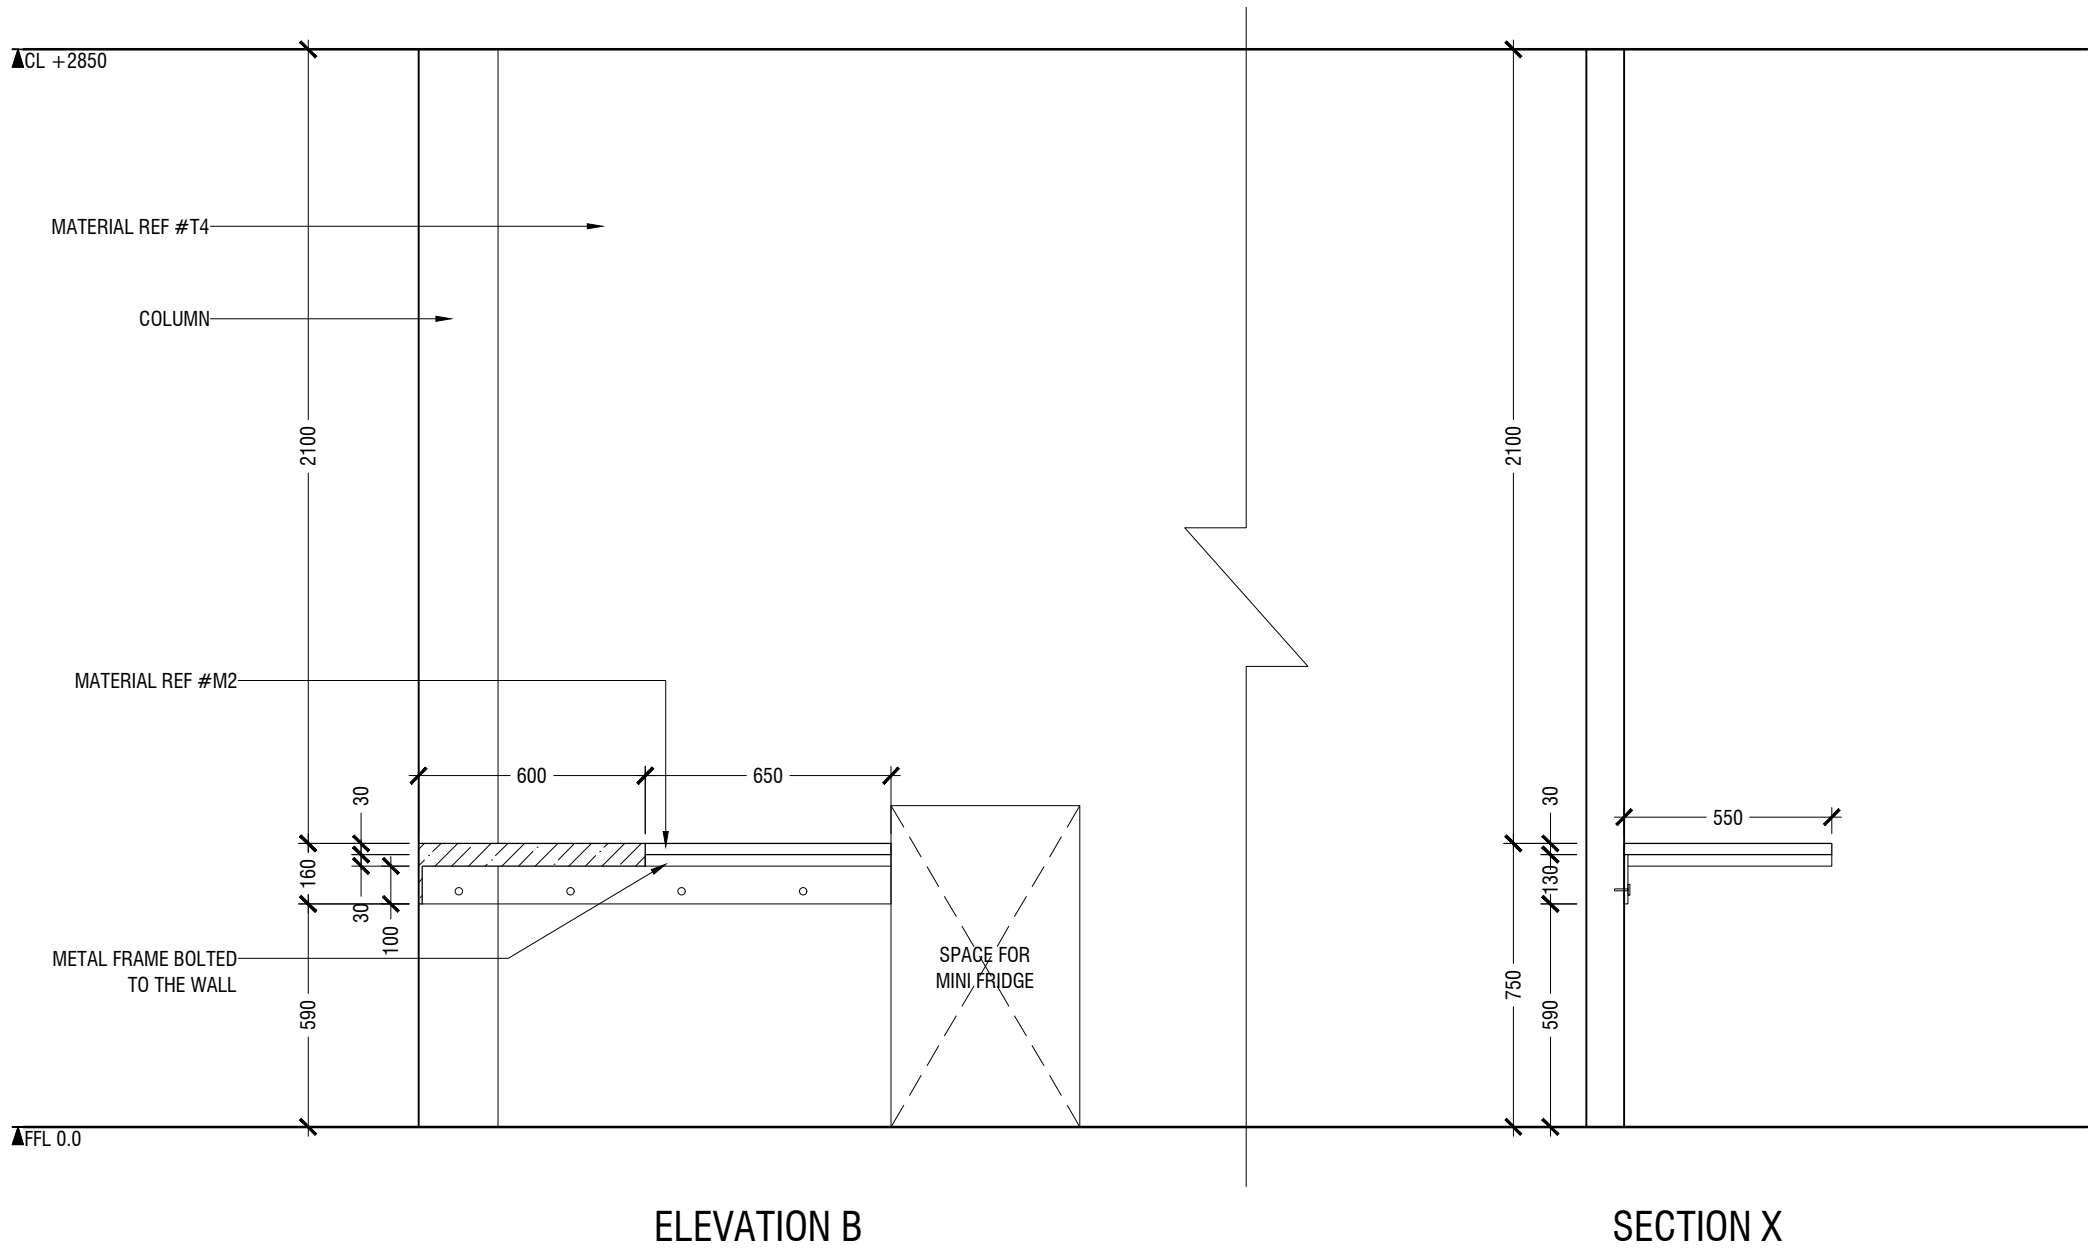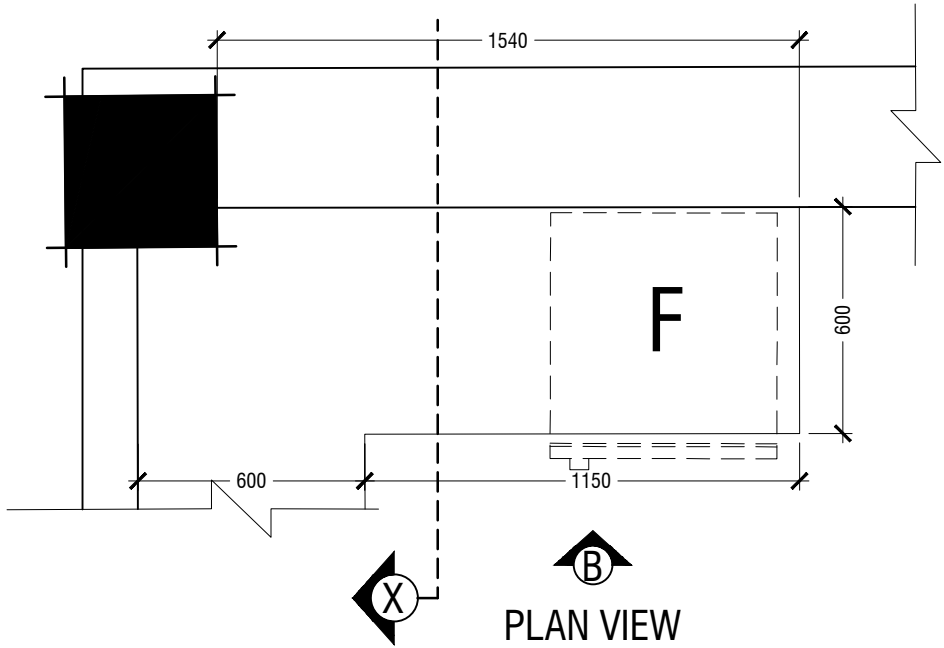

MACO
DESIGNS

Contact: 7989966, 7691671
Email: info@maco.mv

CLIENT:
IGMH

PROJECT:
IGMH CATH LAB
K. MALE

SCALE: AS GIVEN

DRWNG TITLE : AS GIVN

DATE: D015M07Y26

REVISION NO.: 00

FILE NAME:
\\DLINK-031BBD\Volume_1\MACO PROJECTS\2026

WARNING:

- This drawing shall not be used for construction unless certified.
- Contractor to verify all dimensions of existing works on site before commencing any work or preparing shop drawings.
- Do not scale drawings, use written dimensions only.
- This drawing is to be read in conjunction with the specifications and conditions of contract.
- This drawing and design is copyright and no portion may be reproduced without the permission of the MACO architects


1.17 WORKSTATION
LOCATION "DOCTORS LOUNGE"
SCALE 1:20

ID32

- NOTE
- CL = CEILING LINE
 - DCL = DROP CEILING LINE
 - FFL = FLOOR FINISH LINE

*FINAL DIMENSIONS ARE SUBJECT TO CHANGE DEPENDING ON CONTRACTORS ADJUSTMENTS ON SITE

*SLANTED WALL ALIGNMENT TO BE CONFIRMED ON SITE

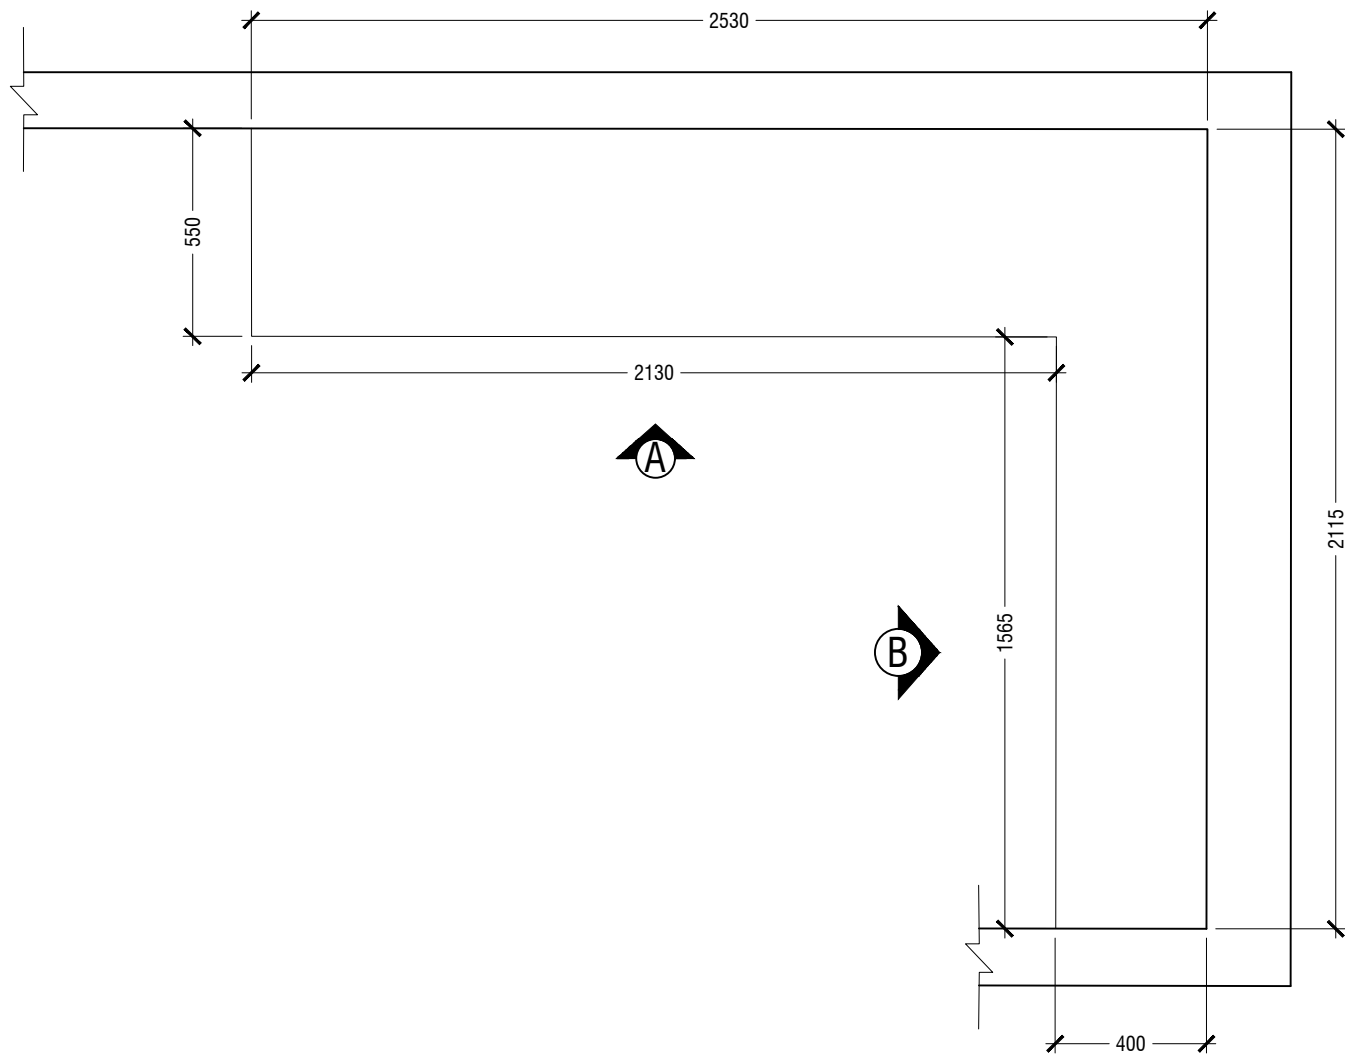

PLAN VIEW

1.18 WARDROBE TYPE STORAGE
LOCATION "FEMALE CHANGING ROOM"
SCALE 1:20

MACO

DESIGNS

Contact: 7989966, 7691671

Email: info@maco.mv

CLIENT:

IGMH

PROJECT:

IGMH CATH LAB

K. MALE

SCALE: AS GIVEN

DRWNG TITLE : AS GIVN

DATE: D015M07Y26

REVISION NO.: 00

FILE NAME:


\\DLINK-031BBD\Volume_1\MACO PROJECTS\2026

WARNING:

- This drawing shall not be used for construction unless certified.
- Contractor to verify all dimensions of existing works on site before commencing any work or preparing shop drawings.
- Do not scale drawings, use written dimensions only.
- This drawing is to be read in conjunction with the specifications and conditions of contract.
- This drawing and design is copyright and no portion may be reproduced without the permission of the MACO architects

ID33

- NOTE
- CL = CEILING LINE
 - DCL = DROP CEILING LINE
 - FFL = FLOOR FINISH LINE

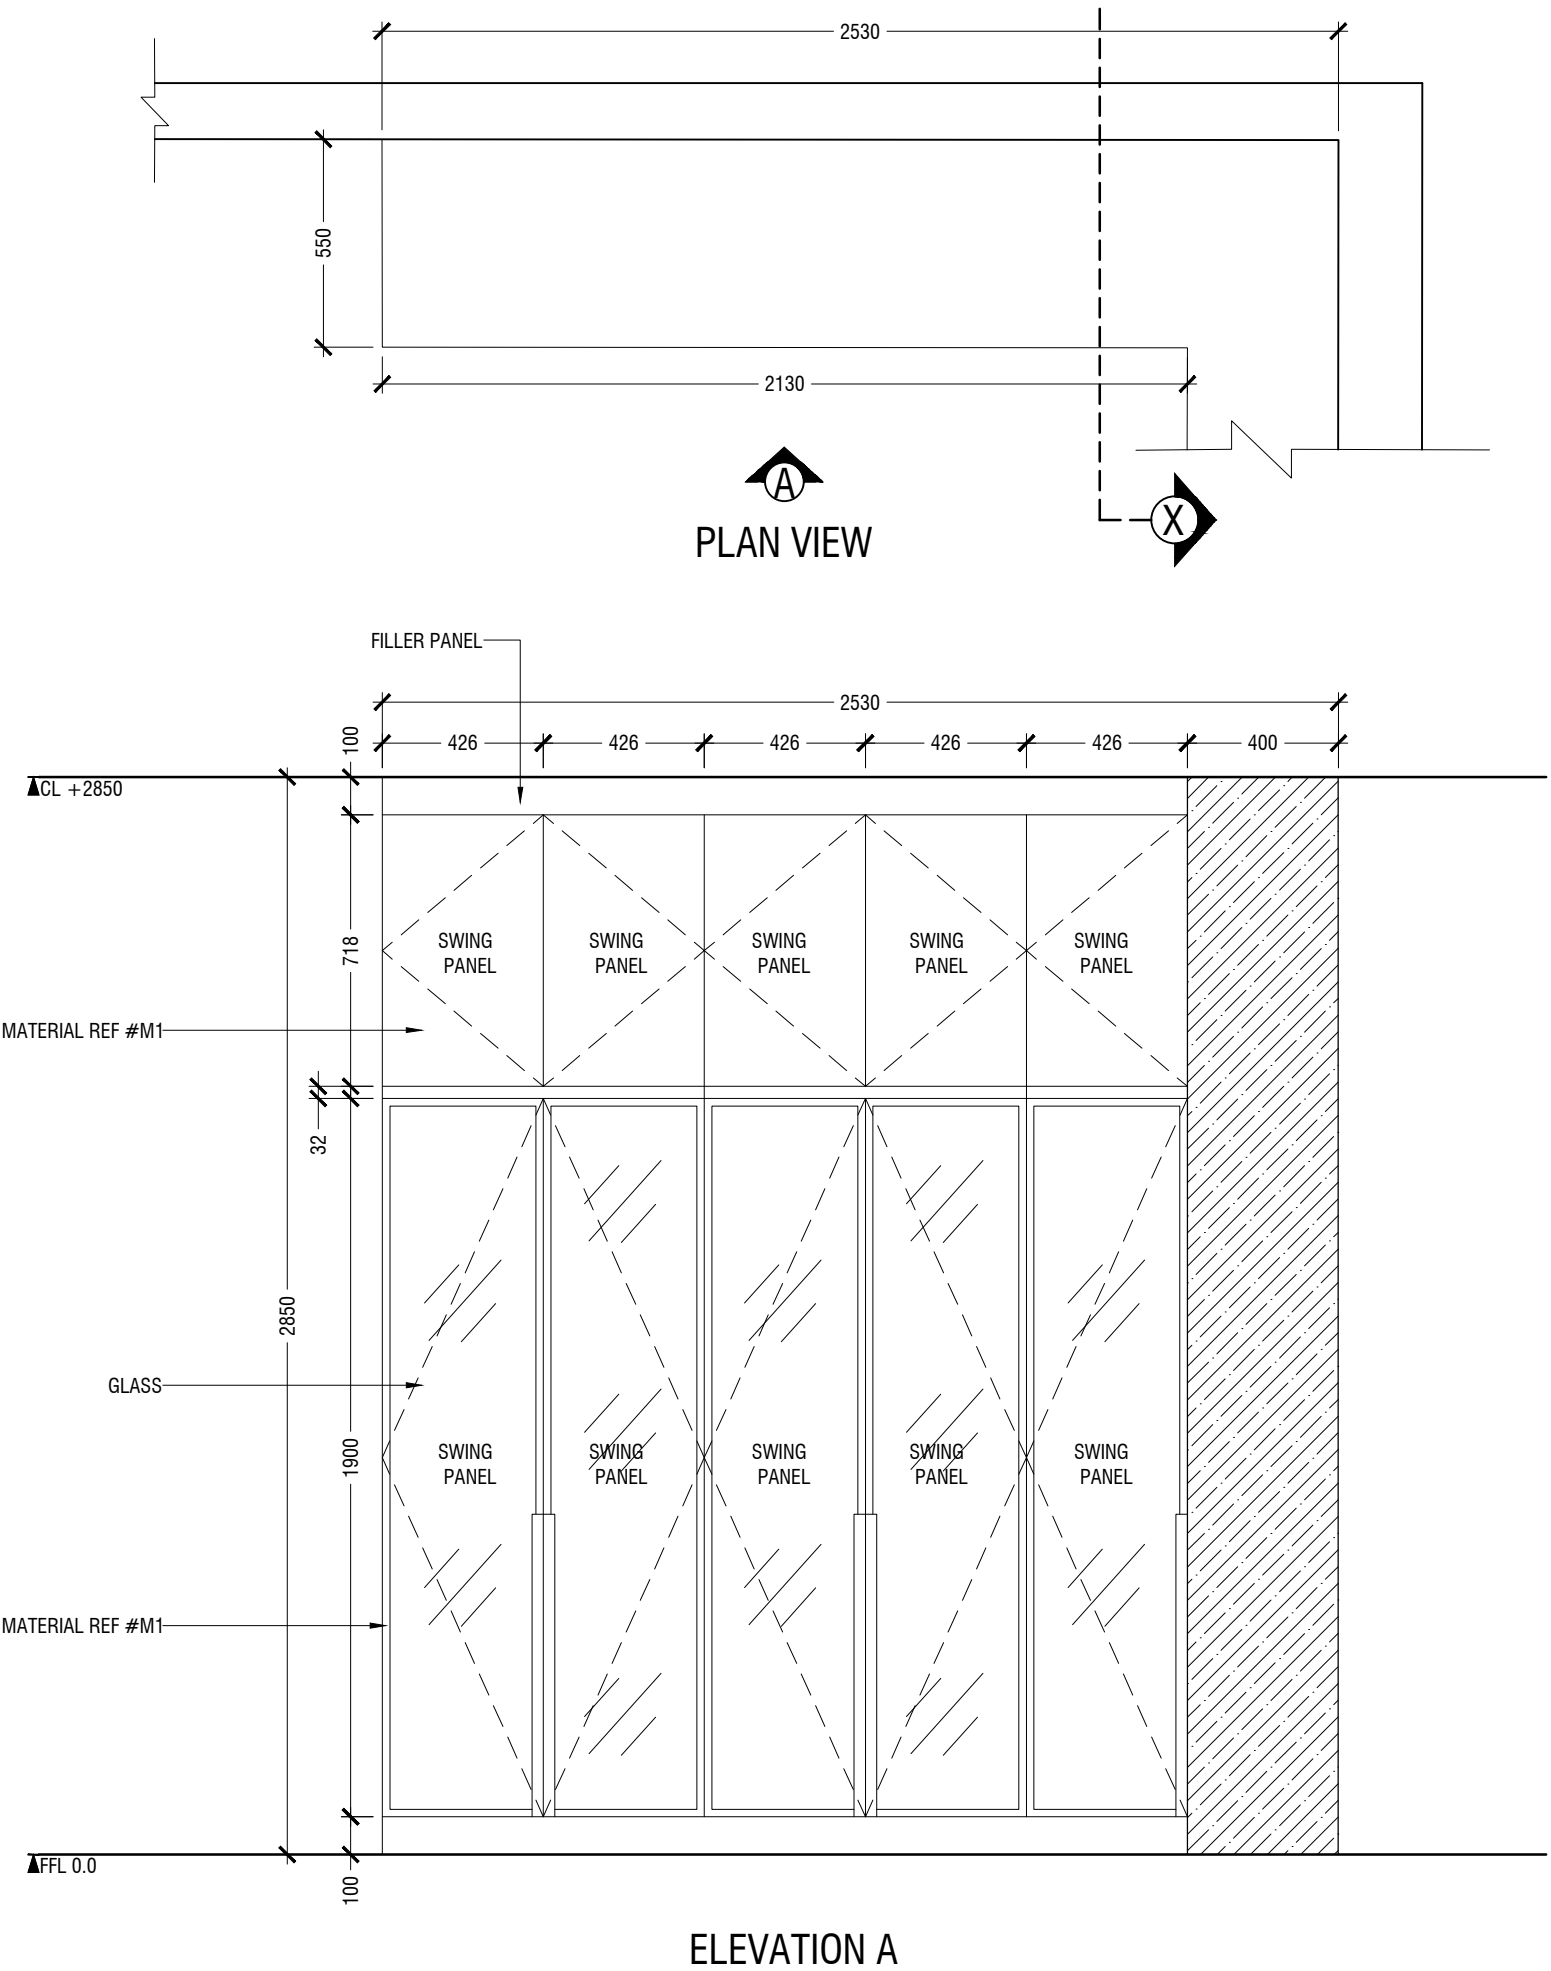

*FINAL DIMENSIONS ARE SUBJECT TO CHANGE DEPENDING ON CONTRACTORS ADJUSTMENTS ON SITE

*SLANTED WALL ALIGNMENT TO BE CONFIRMED ON SITE

MACO
DESIGNS

Contact: 7989966, 7691671

Email: info@maco.mv

CLIENT:

IGMH

PROJECT:

IGMH CATH LAB

K. MALE

SCALE: AS GIVEN

DRWNG TITLE : AS GIVN

DATE: D015M07Y26

REVISION NO.: 00

FILE NAME:

\\DLINK-031BBD\Volume_1\MACO
PROJECTS\2026

WARNING:

- This drawing shall not be used for construction unless certified.
- Contractor to verify all dimensions of existing works on site before commencing any work or preparing shop drawings.
- Do not scale drawings, use written dimensions only.
- This drawing is to be read in conjunction with the specifications and conditions of contract.
- This drawing and design is copyright and no portion may be reproduced without the permission of the MACO architects



ID34

1.18 WARDROBE TYPE STORAGE
LOCATION "FEMALE CHANGING ROOM"
SCALE 1:20

- NOTE
- CL = CEILING LINE
 - DCL = DROP CEILING LINE
 - FFL = FLOOR FINISH LINE

*FINAL DIMENSIONS ARE SUBJECT TO CHANGE DEPENDING ON CONTRACTORS ADJUSTMENTS ON SITE

*SLANTED WALL ALIGNMENT TO BE CONFIRMED ON SITE

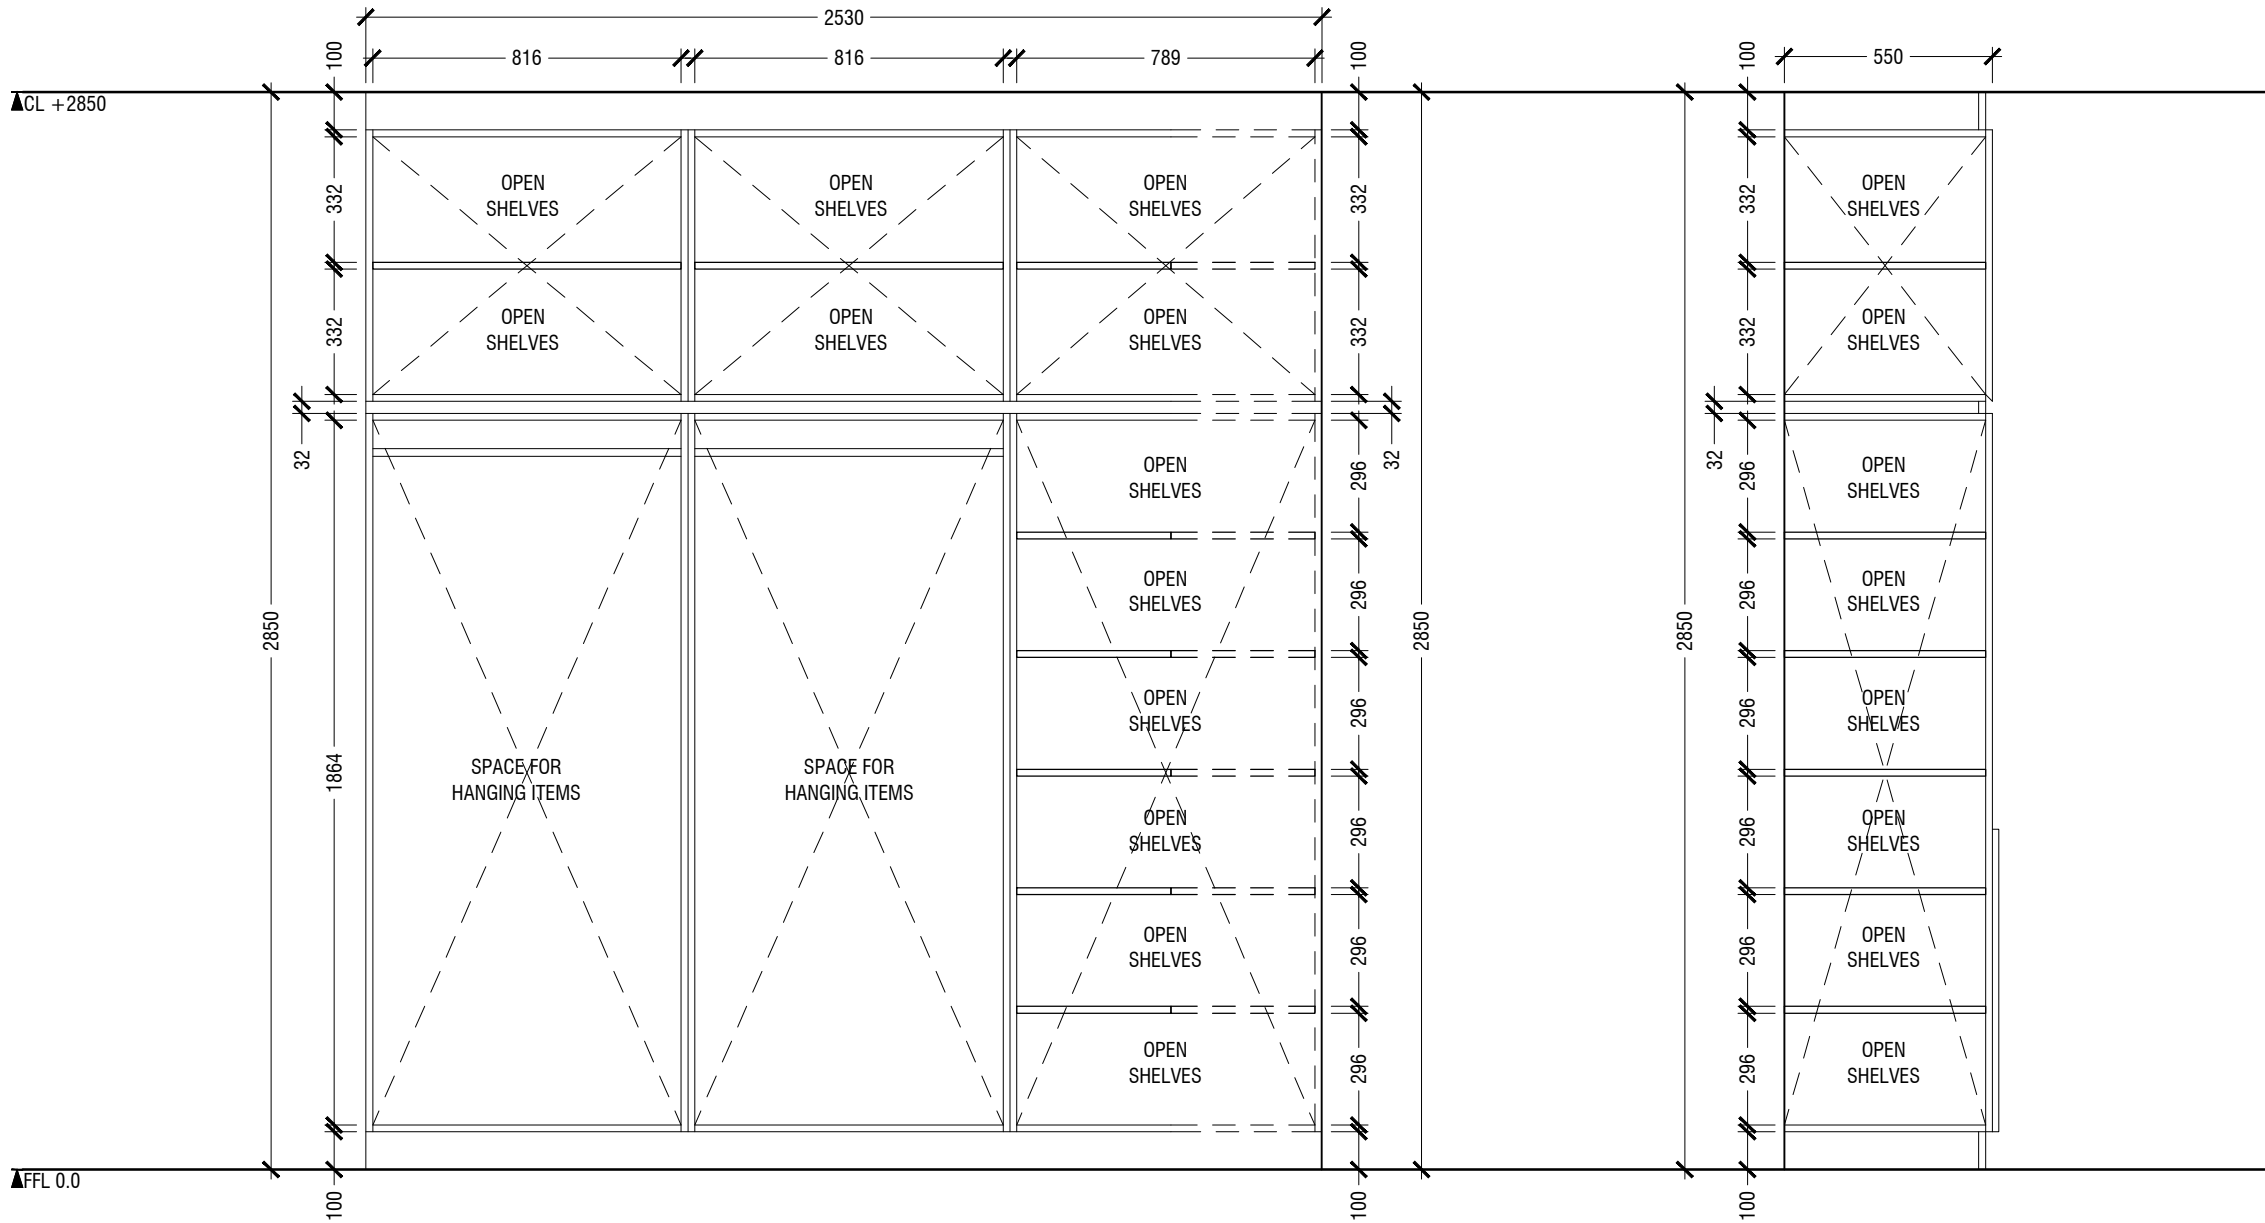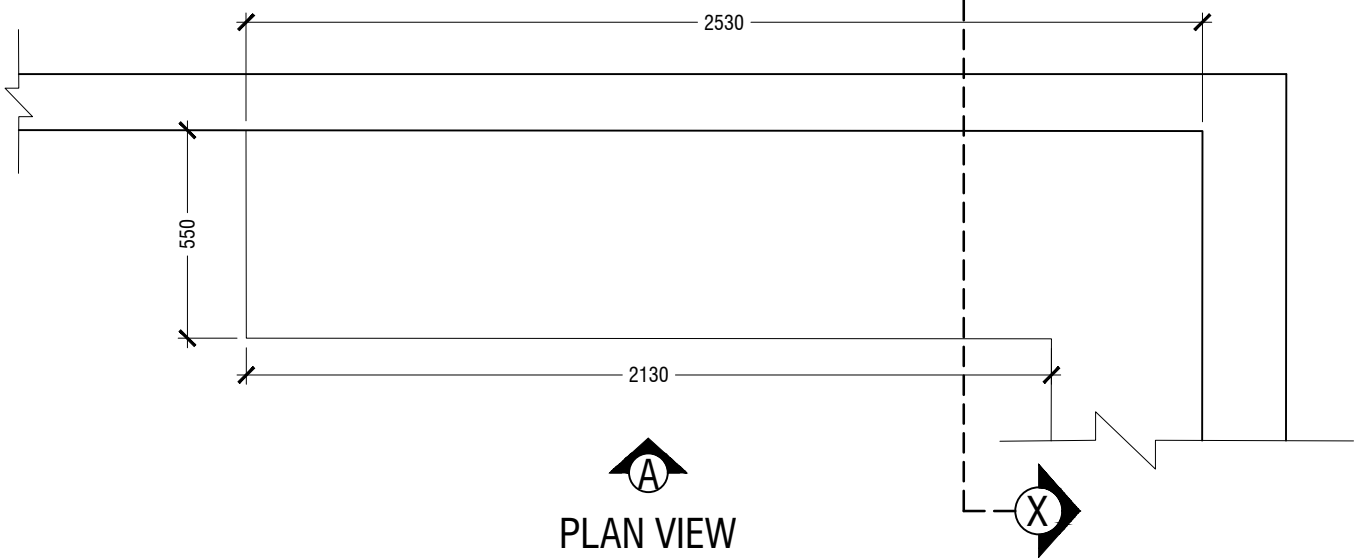

MACO
DESIGNS
Contact: 7989966, 7691671
Email: info@maco.mv

CLIENT:
IGMH

PROJECT:
IGMH CATH LAB
K. MALE

SCALE: AS GIVEN

DRWNG TITLE : AS GIVN

DATE: D015M07Y26

REVISION NO.: 00

FILE NAME:
\\DLINK-031BBD\Volume_1\MACO
PROJECTS\2026

WARNING:
- This drawing shall not be used for construction unless certified.
- Contractor to verify all dimensions of existing works on site before commencing any work or preparing shop drawings.
- Do not scale drawings, use written dimensions only.
- This drawing is to be read in conjunction with the specifications and conditions of contract.
- This drawing and design is copyright and no portion may be reproduced without the permission of the MACO architects

ID35


1.18 **WARDROBE TYPE STORAGE**
LOCATION "FEMALE CHANGING ROOM"
SCALE 1:20

NOTE


- CL = CEILING LINE
- DCL = DROP CEILING LINE
- FFL = FLOOR FINISH LINE

*FINAL DIMENSIONS ARE SUBJECT TO CHANGE DEPENDING ON CONTRACTORS ADJUSTMENTS ON SITE

*SLANTED WALL ALIGNMENT TO BE CONFIRMED ON SITE

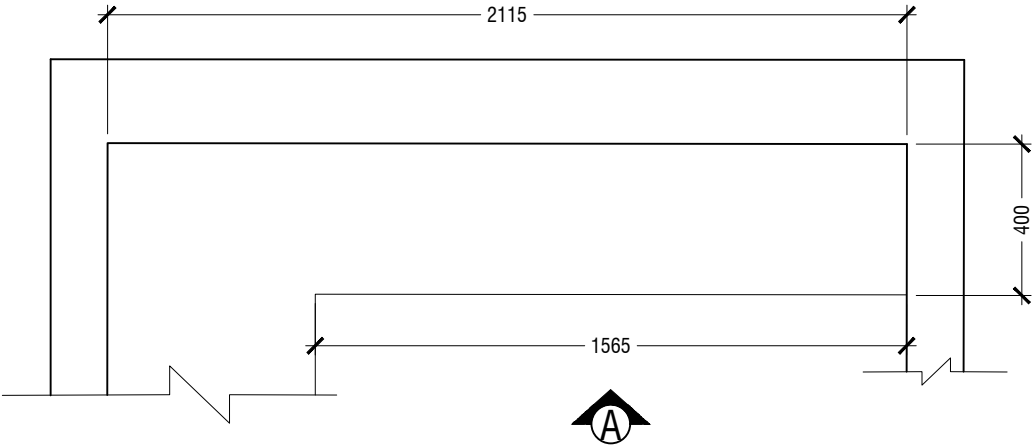

PLAN VIEW

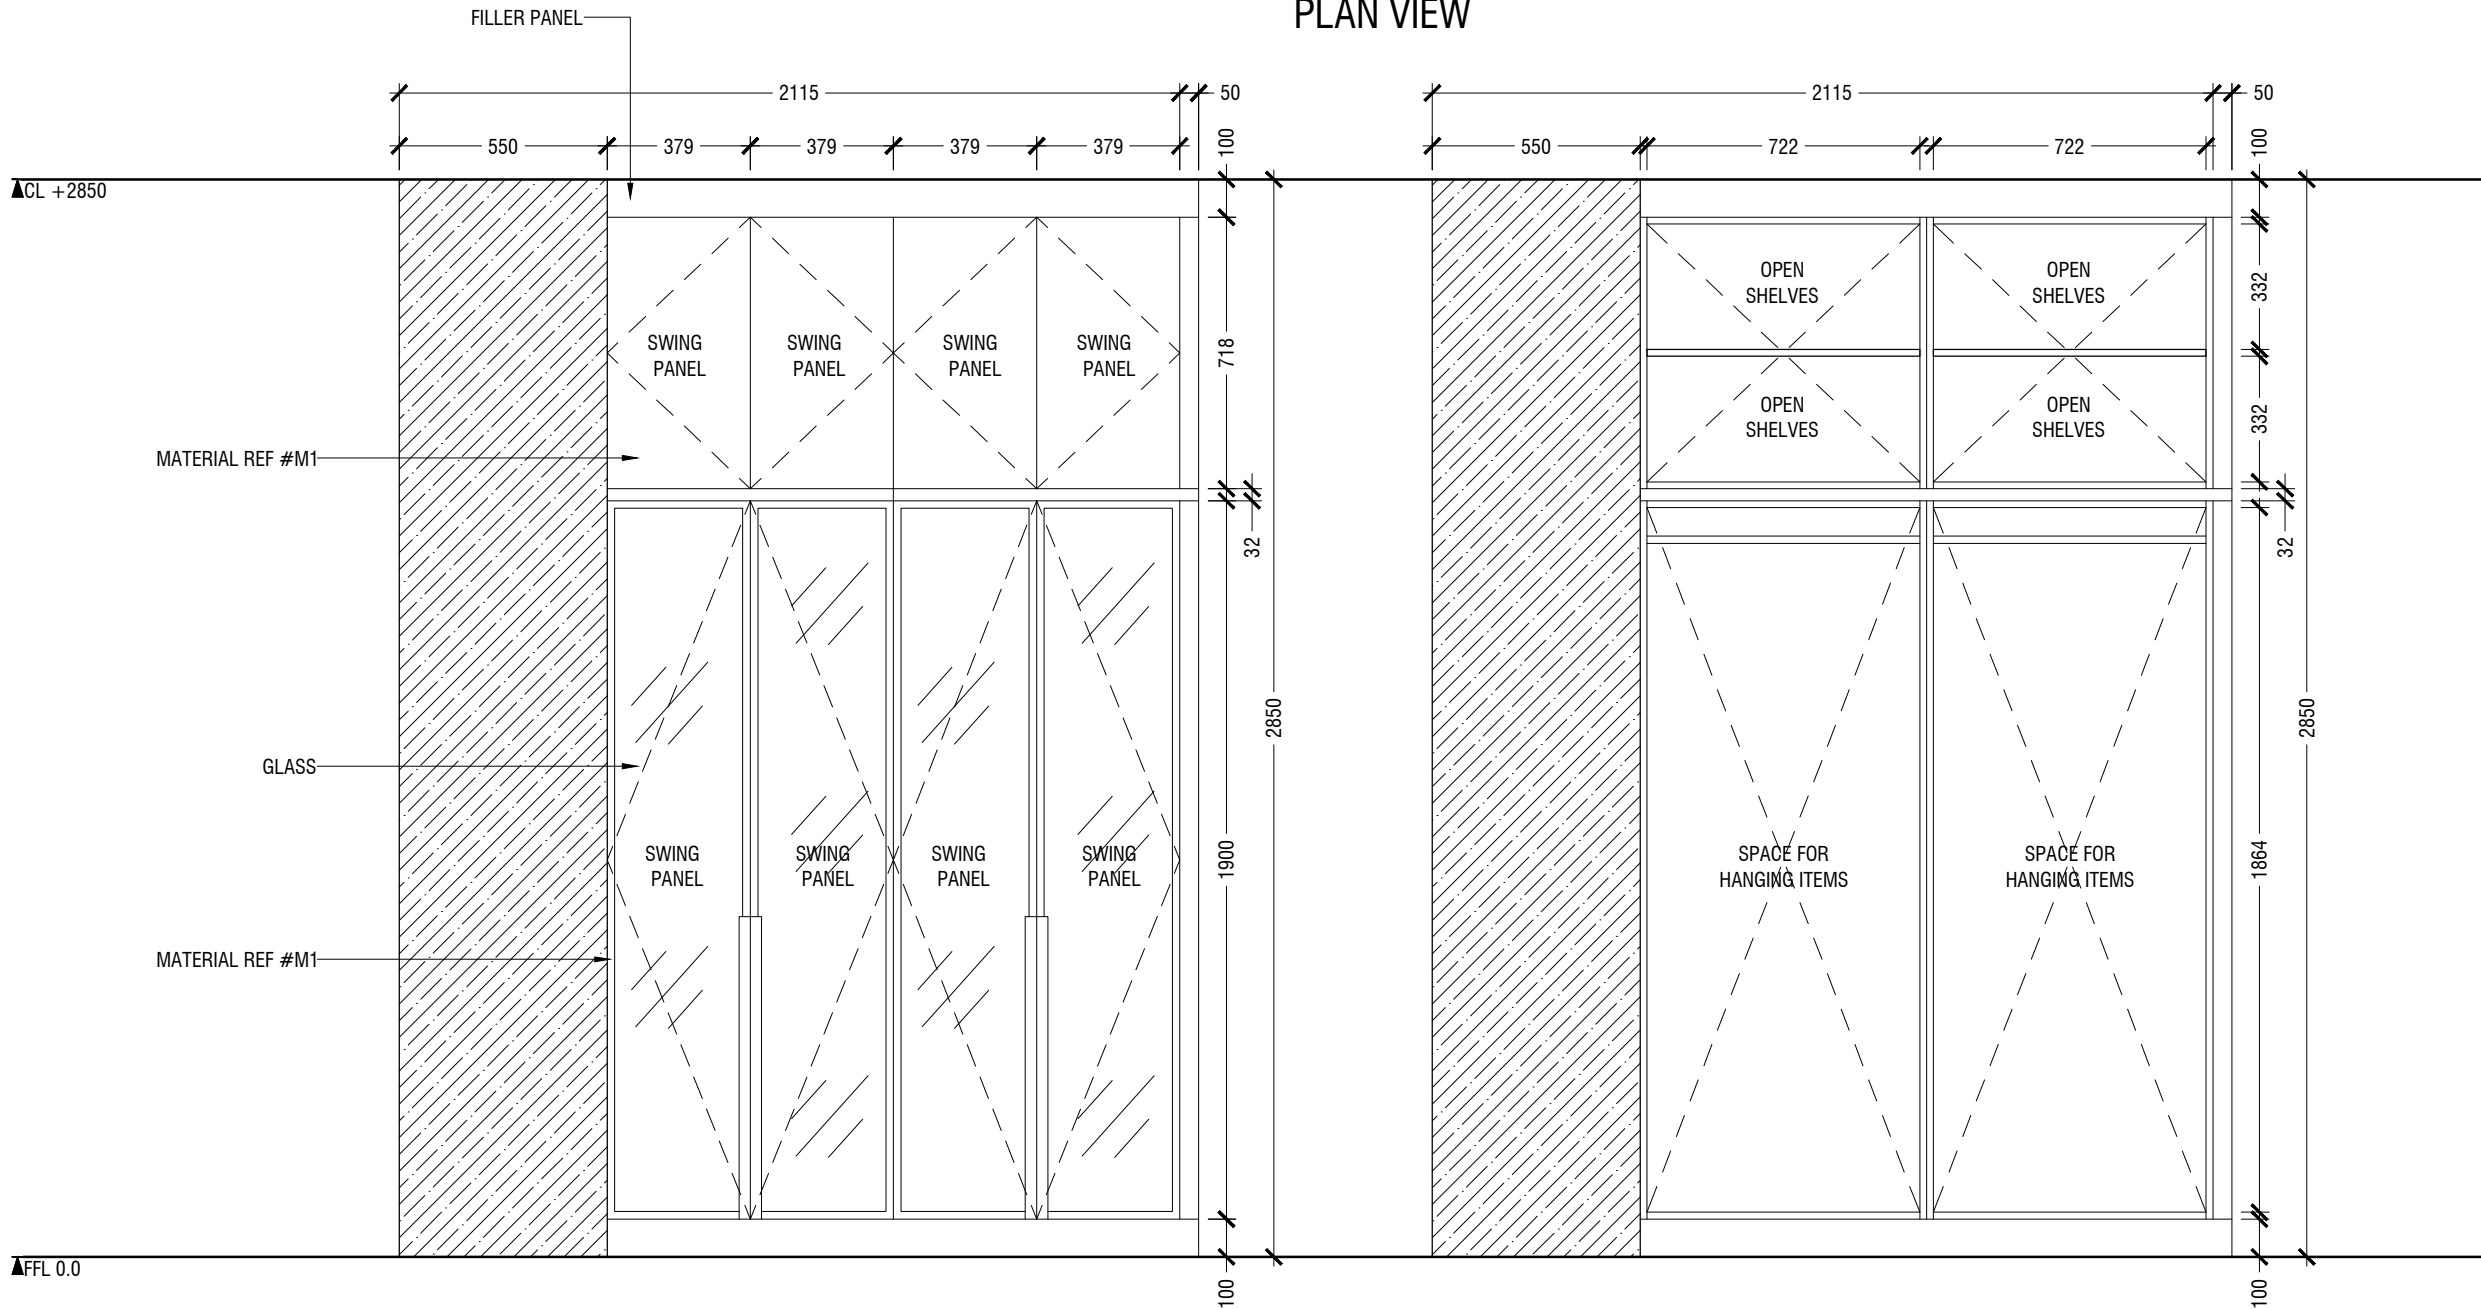

ELEVATION B

OPEN ELEVATION B

MACO

DESIGNS

Contact: 7989966, 7691671

Email: info@maco.mv

CLIENT:

IGMH

PROJECT:

IGMH CATH LAB

K. MALE

SCALE: AS GIVEN

DRWNG TITLE : AS GIVN

DATE: D015M07Y26

REVISION NO.: 00

FILE NAME:

\\DLINK-031BBD\Volume_1\MACO
PROJECTS\2026

WARNING:

- This drawing shall not be used for construction unless certified.
- Contractor to verify all dimensions of existing works on site before commencing any work or preparing shop drawings.
- Do not scale drawings, use written dimensions only.
- This drawing is to be read in conjunction with the specifications and conditions of contract.
- This drawing and design is copyright and no portion may be reproduced without the permission of the MACO architects


ID36

1.18

WARDROBE TYPE STORAGE
LOCATION "FEMALE CHANGING ROOM"
SCALE 1:20

- CL = CEILING LINE
- DCL = DROP CEILING LINE
- FFL = FLOOR FINISH LINE

*SLANTED WALL ALIGNMENT TO BE CONFIRMED ON SITE

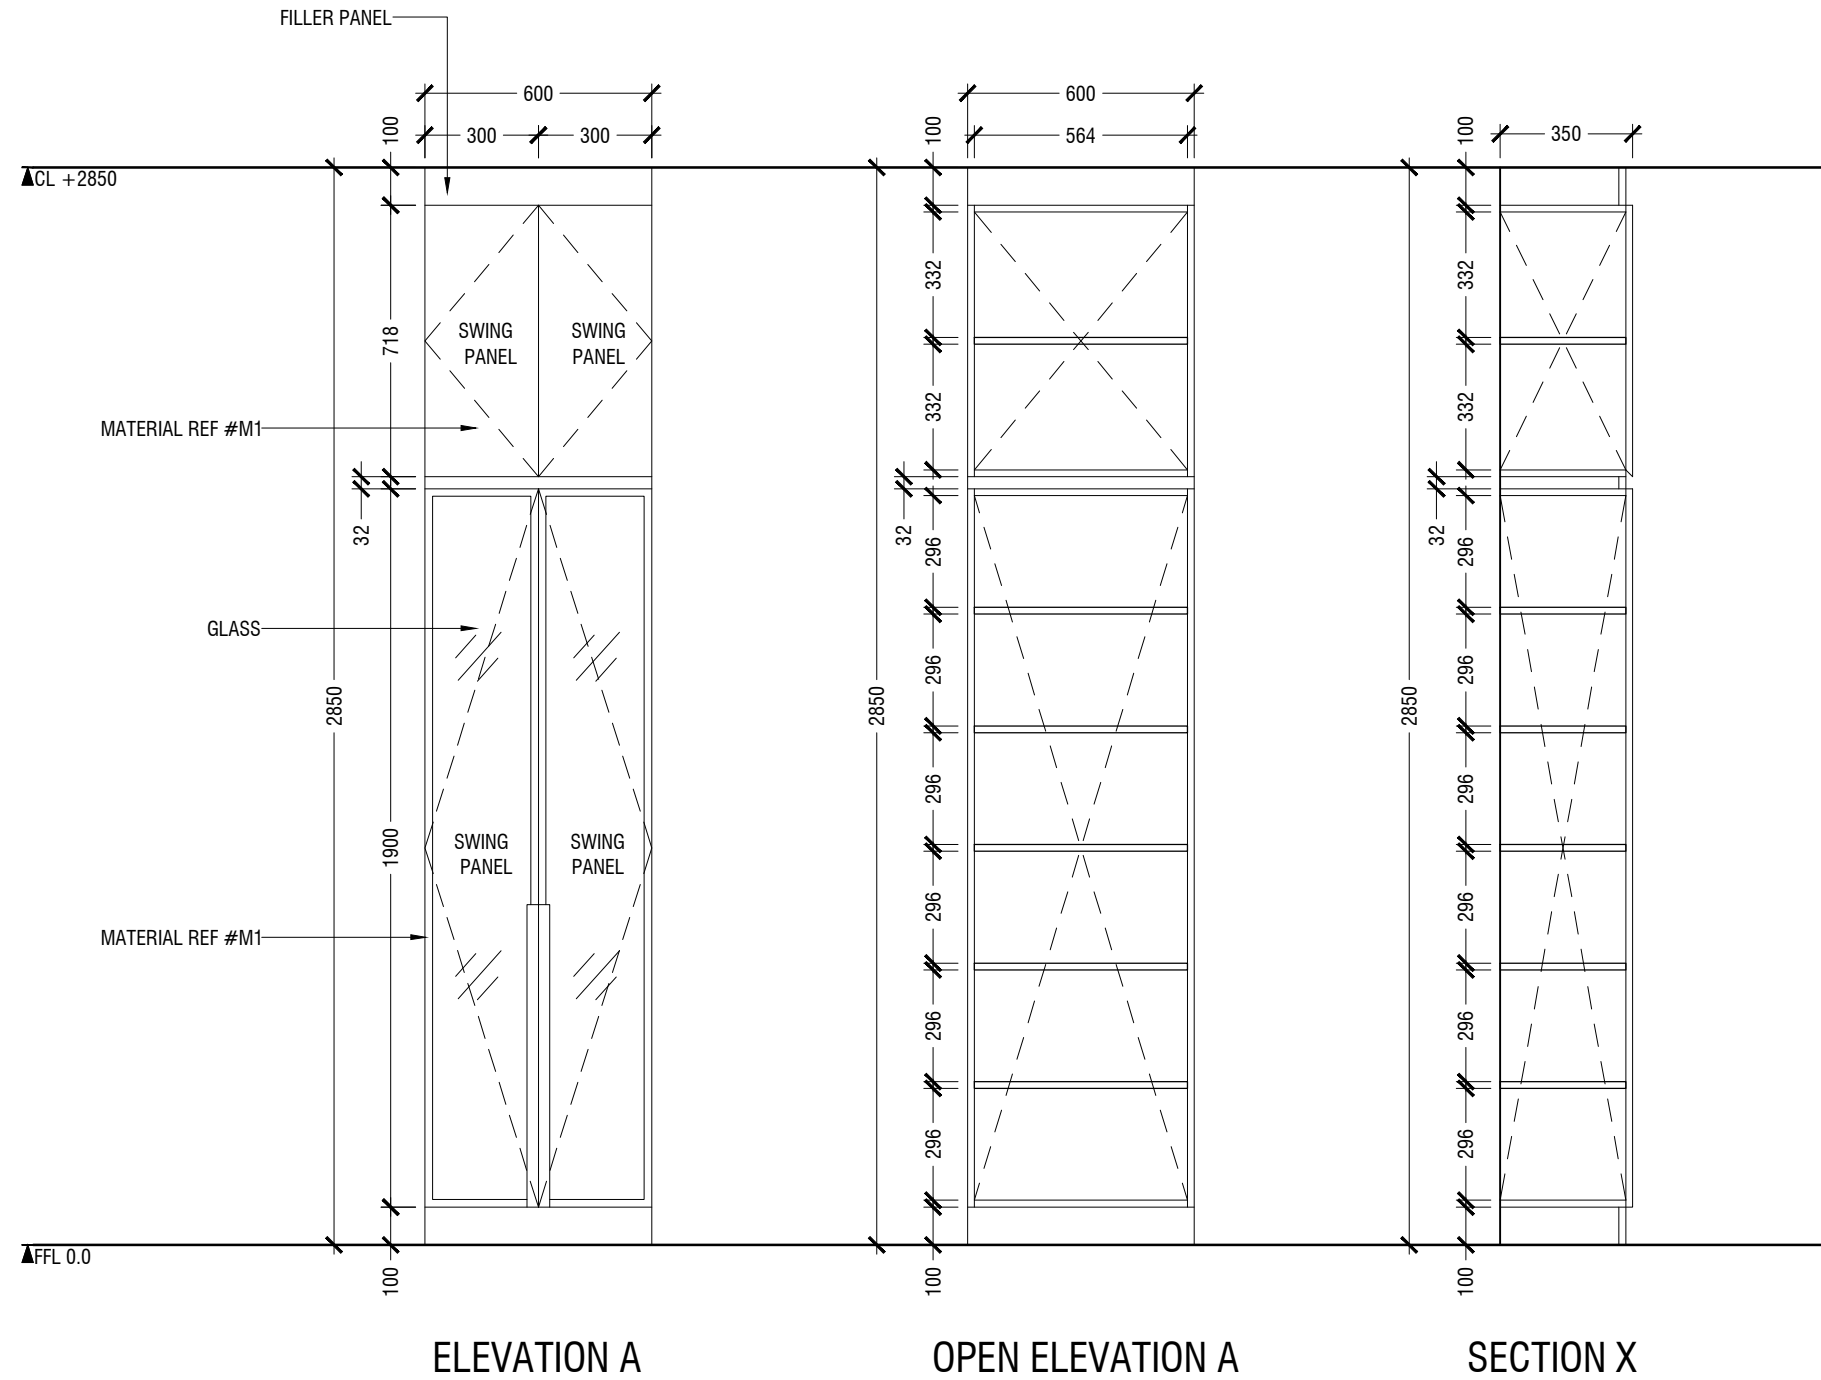

- This drawing shall not be used for construction unless certified.
- Contractor to verify all dimensions of existing works on site before commencing any work or preparing shop drawings.
- Do not scale drawings, use written dimensions only.
- This drawing is to be read in conjunction with the specifications and conditions of contract.
- This drawing and design is copyright and no portion may be reproduced without the permission of the MACO architects


ID37

(1.19)

FULL HEIGHT STORAGE
LOCATION "FEMALE CHANGING ROOM"
SCALE 1:20

- CL = CEILING LINE
- DCL = DROP CEILING LINE
- FFL = FLOOR FINISH LINE

*SLANTED WALL ALIGNMENT TO BE CONFIRMED ON SITE

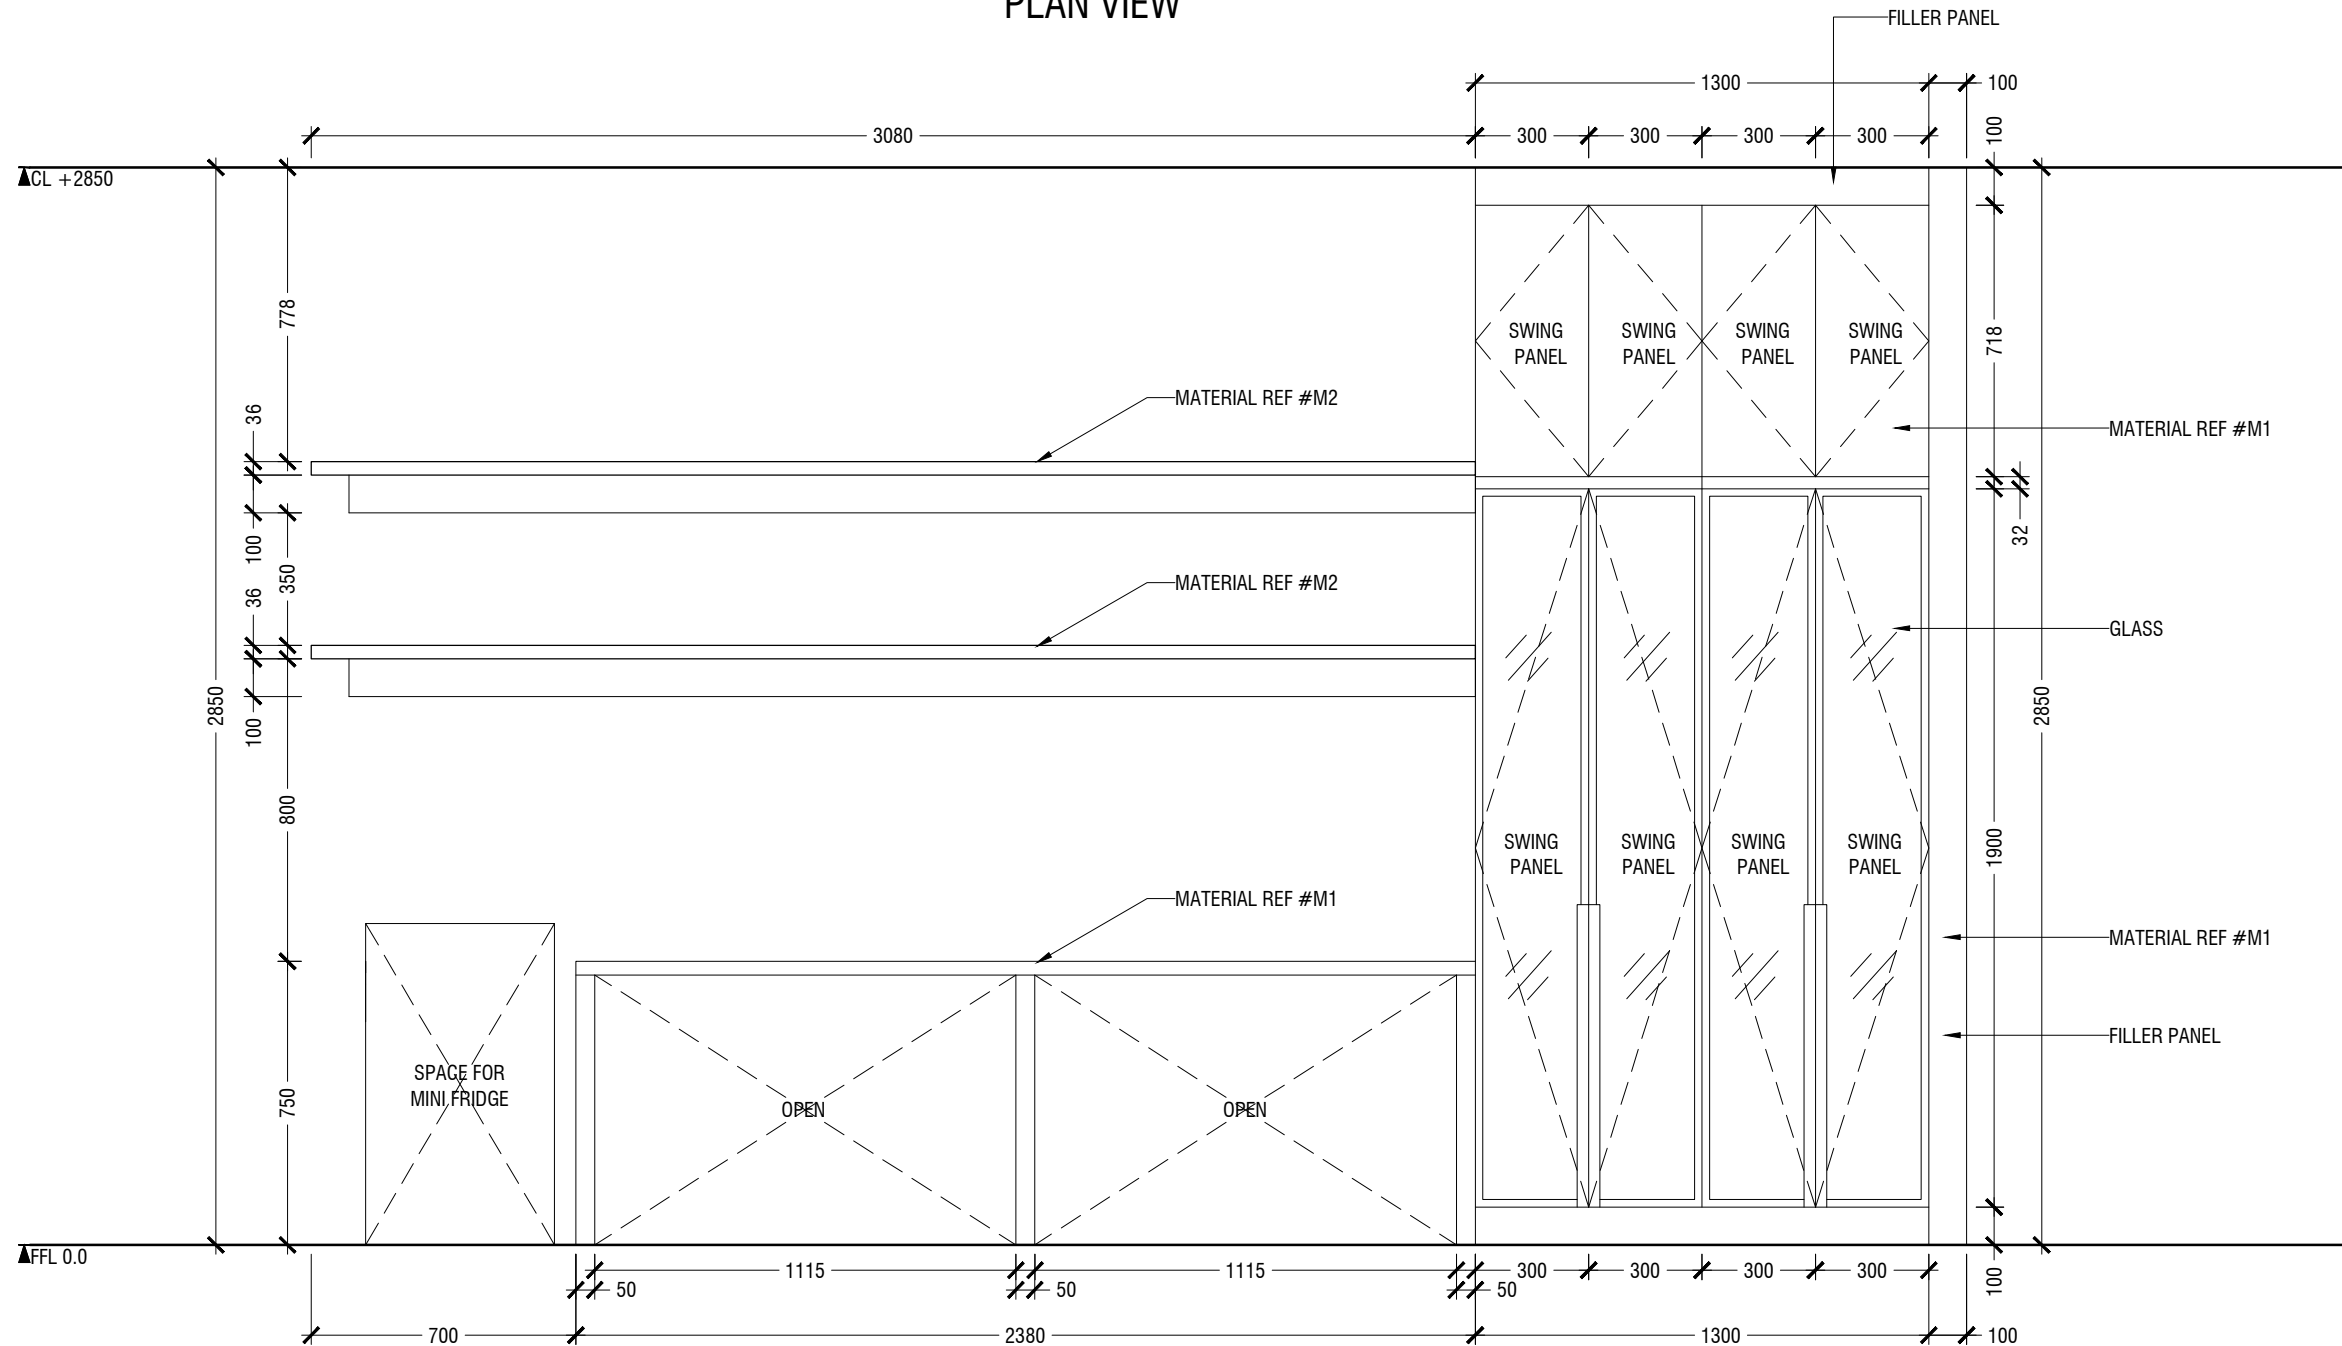

- This drawing shall not be used for construction unless certified.
- Contractor to verify all dimensions of existing works on site before commencing any work or preparing shop drawings.
- Do not scale drawings, use written dimensions only.
- This drawing is to be read in conjunction with the specifications and conditions of contract.
- This drawing and design is copyright and no portion may be reproduced without the permission of the MACO architects

ID38



SCALE 1:20

ELEVATION A

- NOTE
- CL = CEILING LINE
 - DCL = DROP CEILING LINE
 - FFL = FLOOR FINISH LINE

*FINAL DIMENSIONS ARE SUBJECT TO CHANGE DEPENDING ON CONTRACTORS ADJUSTMENTS ON SITE

*SLANTED WALL ALIGNMENT TO BE CONFIRMED ON SITE

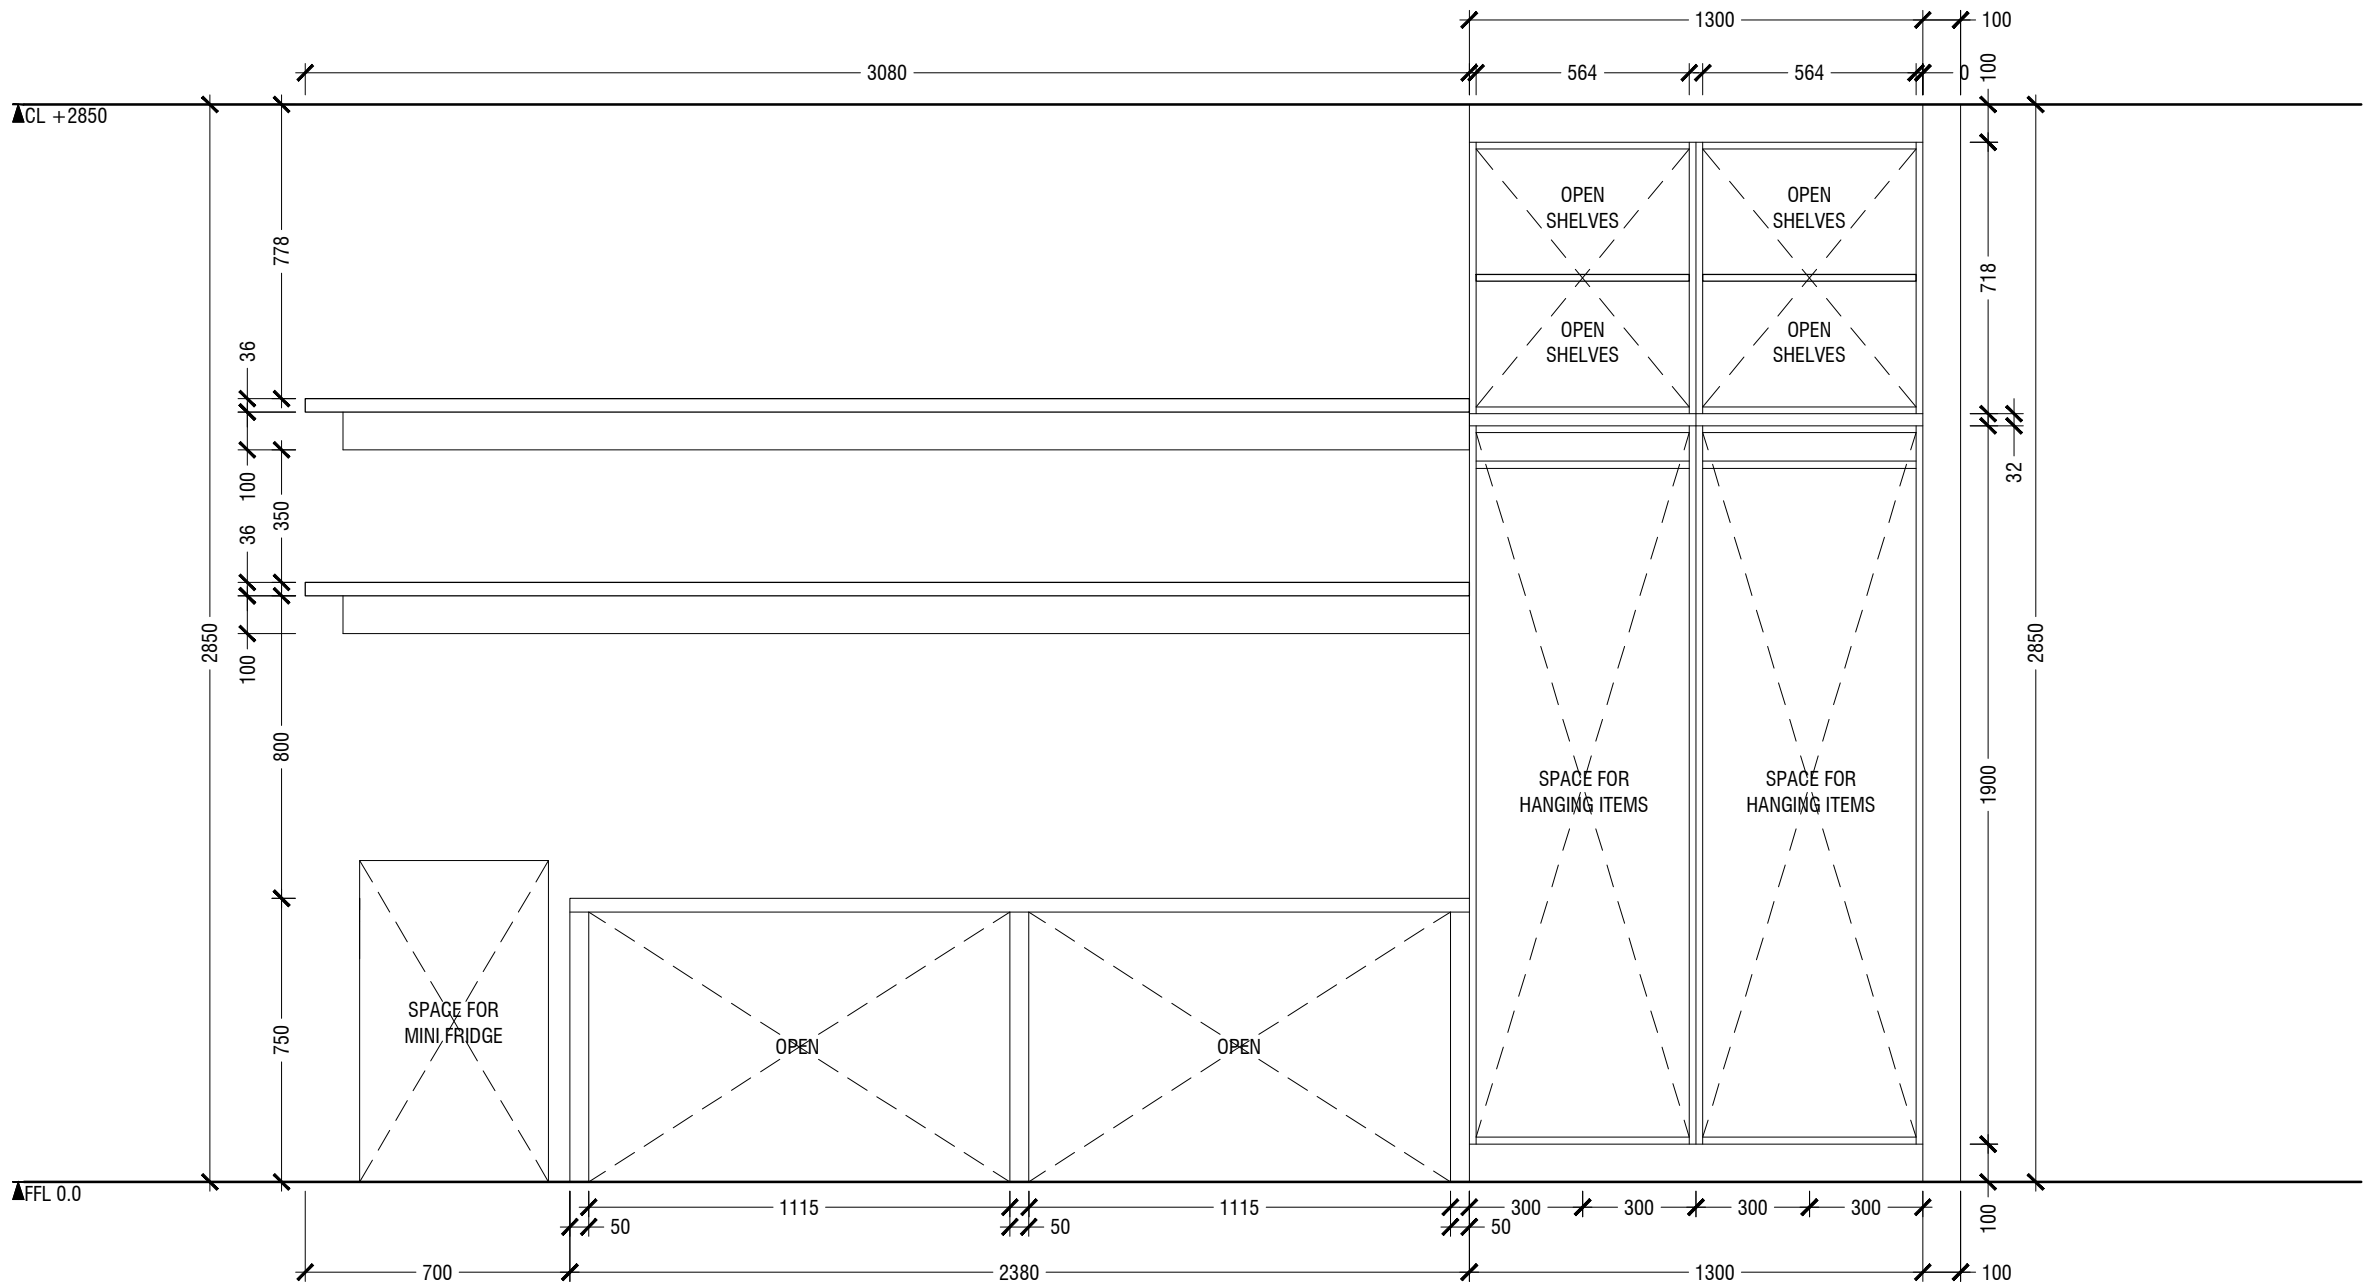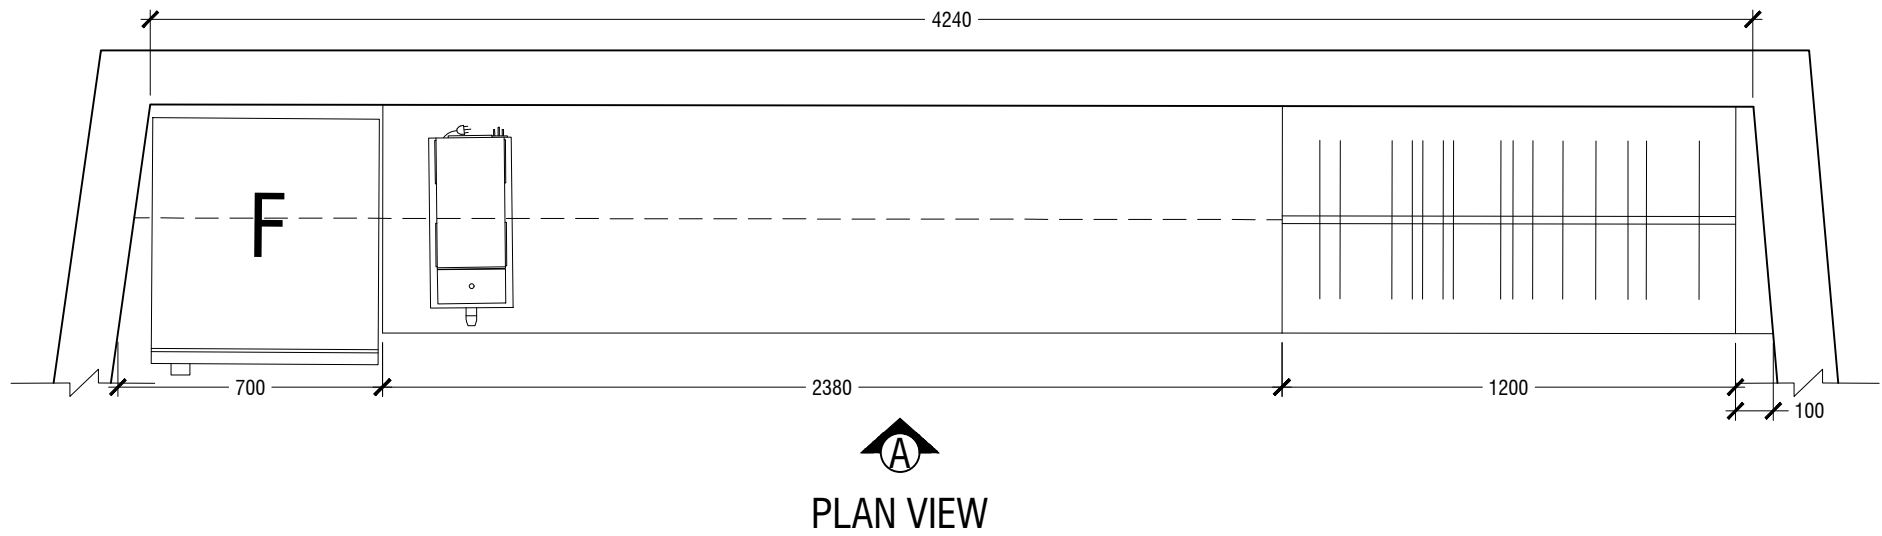

MACO
DESIGNS
Contact: 7989966, 7691671
Email: info@maco.mv

CLIENT:
IGMH

PROJECT:
IGMH CATH LAB
K. MALE

SCALE: AS GIVEN

DRWNG TITLE : AS GIVN

DATE: D015M07Y26

REVISION NO.: 00

FILE NAME:
\\DLINK-031BBD\Volume_1\MACO
PROJECTS\2026

WARNING:
- This drawing shall not be used for construction unless certified.
- Contractor to verify all dimensions of existing works on site before commencing any work or preparing shop drawings.
- Do not scale drawings, use written dimensions only.
- This drawing is to be read in conjunction with the specifications and conditions of contract.
- This drawing and design is copyright and no portion may be reproduced without the permission of the MACO architects

ID39

1.20 WORK DESK + STORAGE
LOCATION "CONSULTANT ROOM"
SCALE 1:20

- CL = CEILING LINE
- DCL = DROP CEILING LINE
- FFL = FLOOR FINISH LINE

*SLANTED WALL ALIGNMENT TO BE CONFIRMED ON SITE





WARNING:

- This drawing shall not be used for construction unless certified.
- Contractor to verify all dimensions of existing works on site before commencing any work or preparing shop drawings.
- Do not scale drawings, use written dimensions only.
- This drawing is to be read in conjunction with the specifications and conditions of contract.
- This drawing and design is copyright and no portion may be reproduced without the permission of the MACO architects

ID40

1.21 STORAGE CABINET
LOCATION "CATHETER WASH"
SCALE 1:20

- NOTE
- CL = CEILING LINE
 - DCL = DROP CEILING LINE
 - FFL = FLOOR FINISH LINE

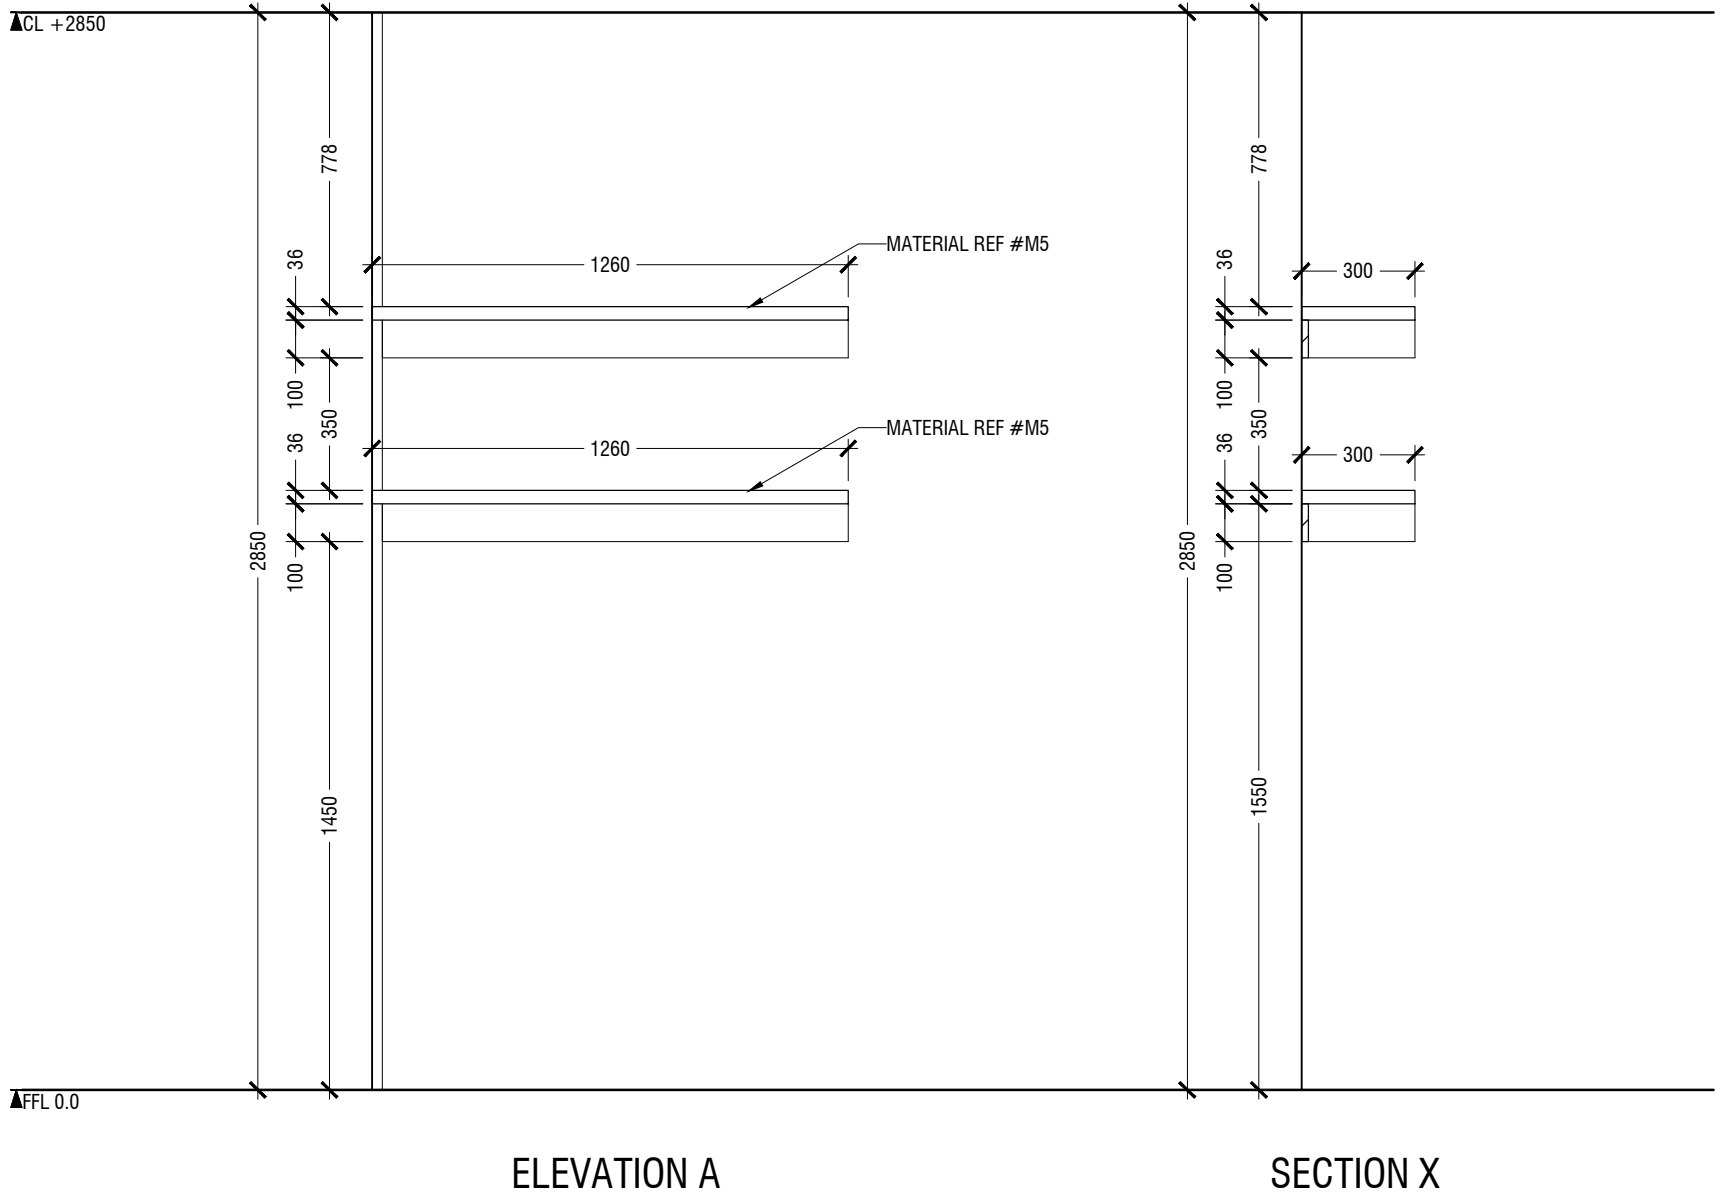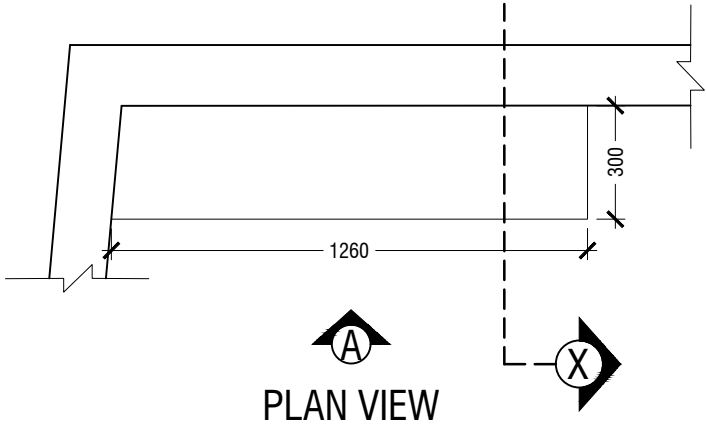

*FINAL DIMENSIONS ARE SUBJECT TO CHANGE DEPENDING ON CONTRACTORS ADJUSTMENTS ON SITE

*SLANTED WALL ALIGNMENT TO BE CONFIRMED ON SITE

MACO
DESIGNS

Contact: 7989966, 7691671

Email: info@maco.mv

CLIENT:

IGMH

PROJECT:

IGMH CATH LAB

K. MALE

SCALE: AS GIVEN

DRWNG TITLE : AS GIVN

DATE: D015M07Y26

REVISION NO.: 00

FILE NAME:

\\DLINK-031BBD\Volume_1\MACO PROJECTS\2026

WARNING:

- This drawing shall not be used for construction unless certified.
- Contractor to verify all dimensions of existing works on site before commencing any work or preparing shop drawings.
- Do not scale drawings, use written dimensions only.
- This drawing is to be read in conjunction with the specifications and conditions of contract.
- This drawing and design is copyright and no portion may be reproduced without the permission of the MACO architects

1.22 WALL MOUNTED SHELVES

LOCATION "CATHETER WASH"

SCALE 1:20



ID41

NOTE

- CL = CEILING LINE
- DCL = DROP CEILING LINE
- FFL = FLOOR FINISH LINE

*FINAL DIMENSIONS ARE SUBJECT TO CHANGE DEPENDING ON CONTRACTORS ADJUSTMENTS ON SITE

*SLANTED WALL ALIGNMENT TO BE CONFIRMED ON SITE

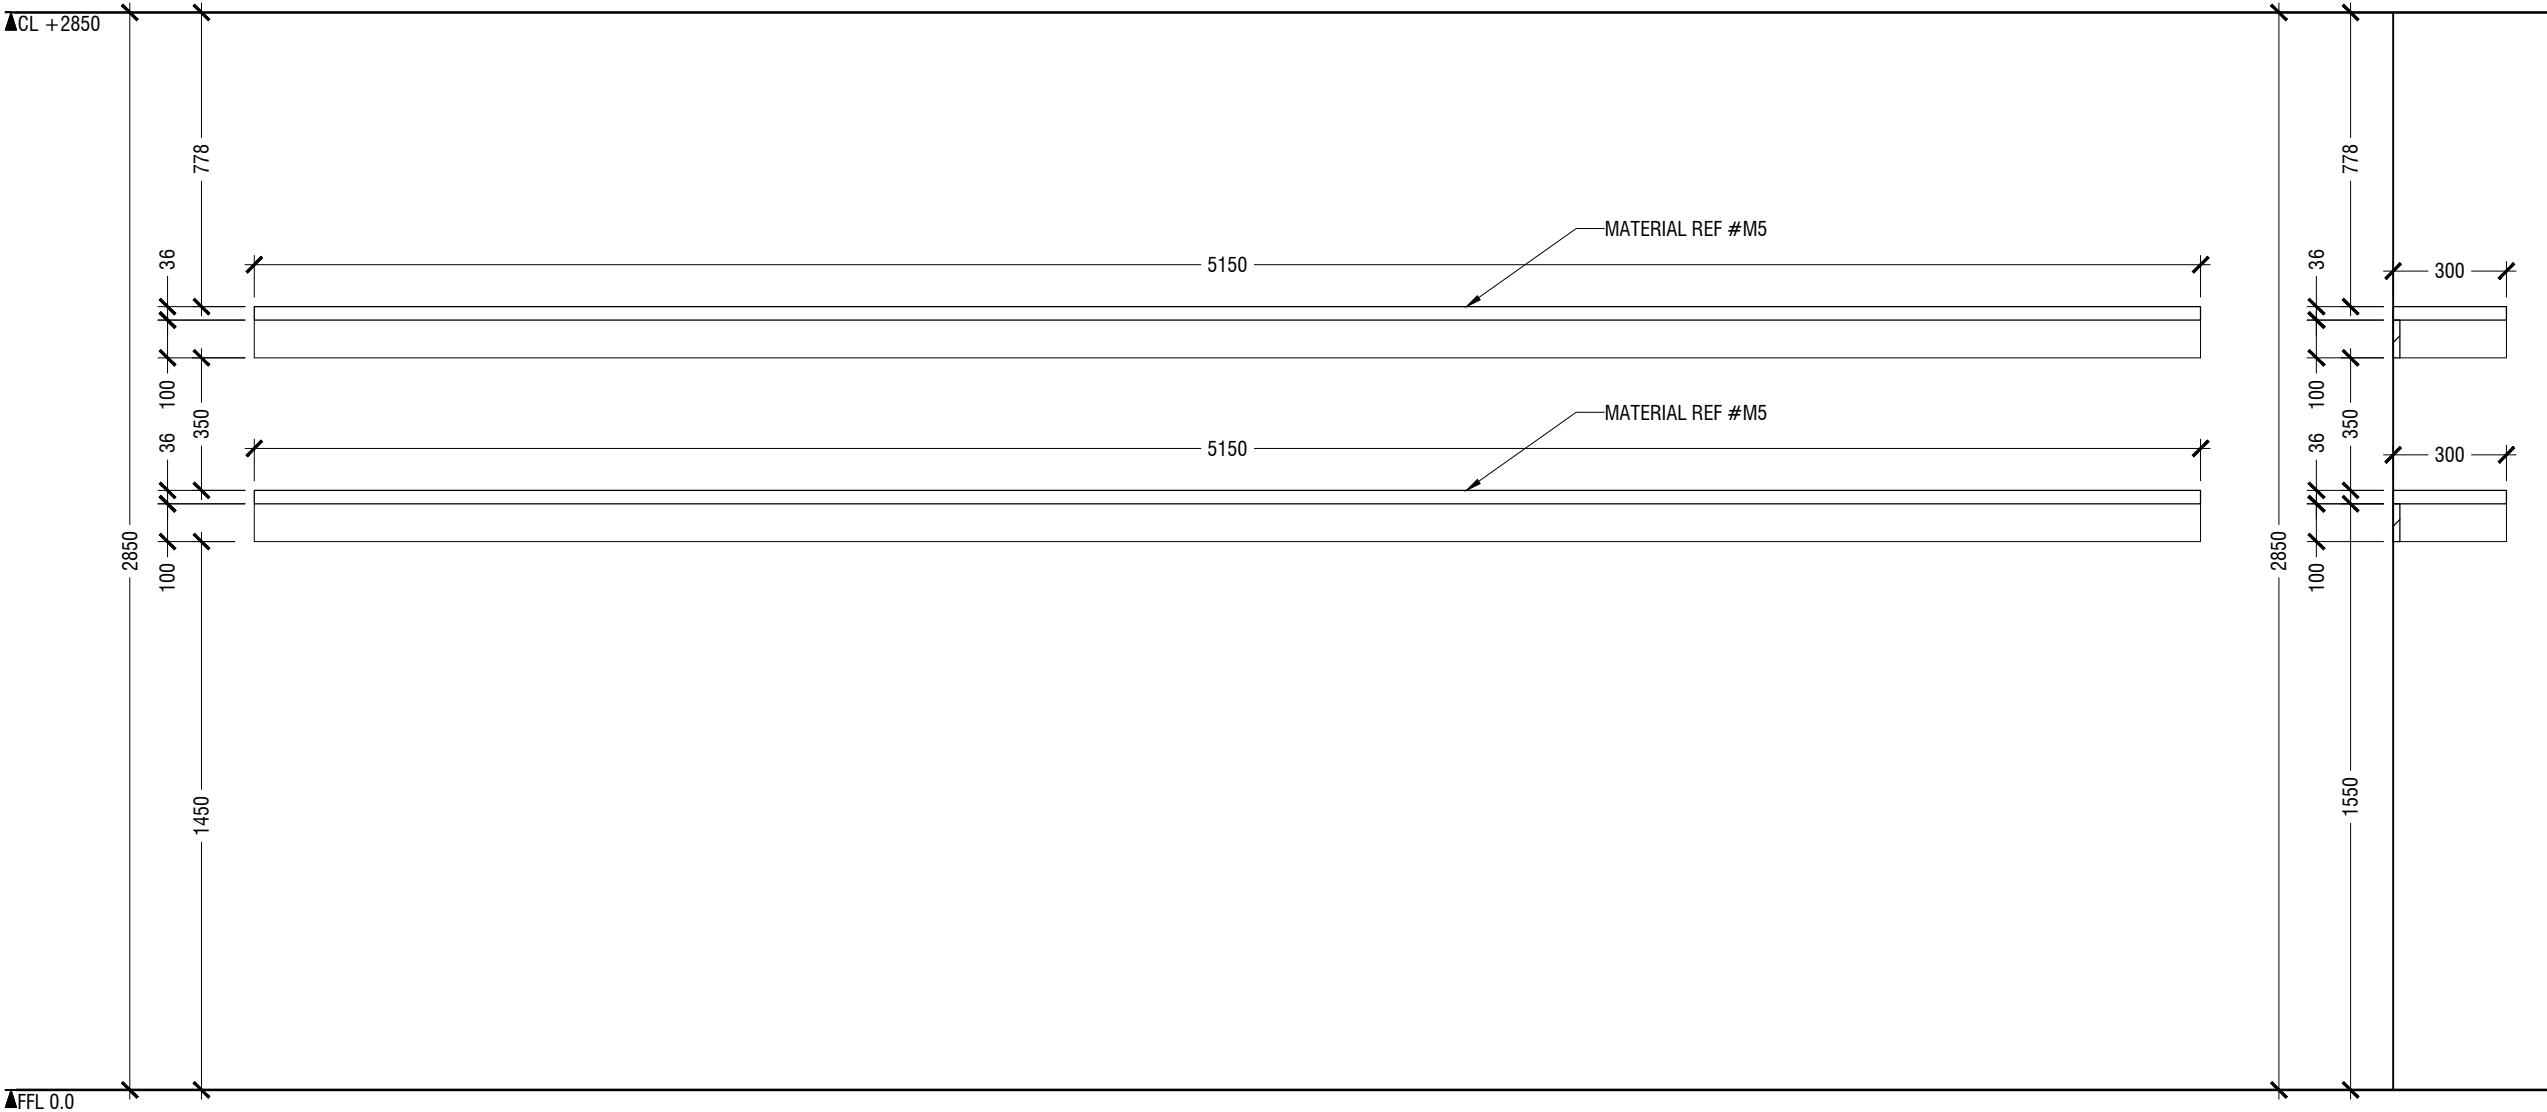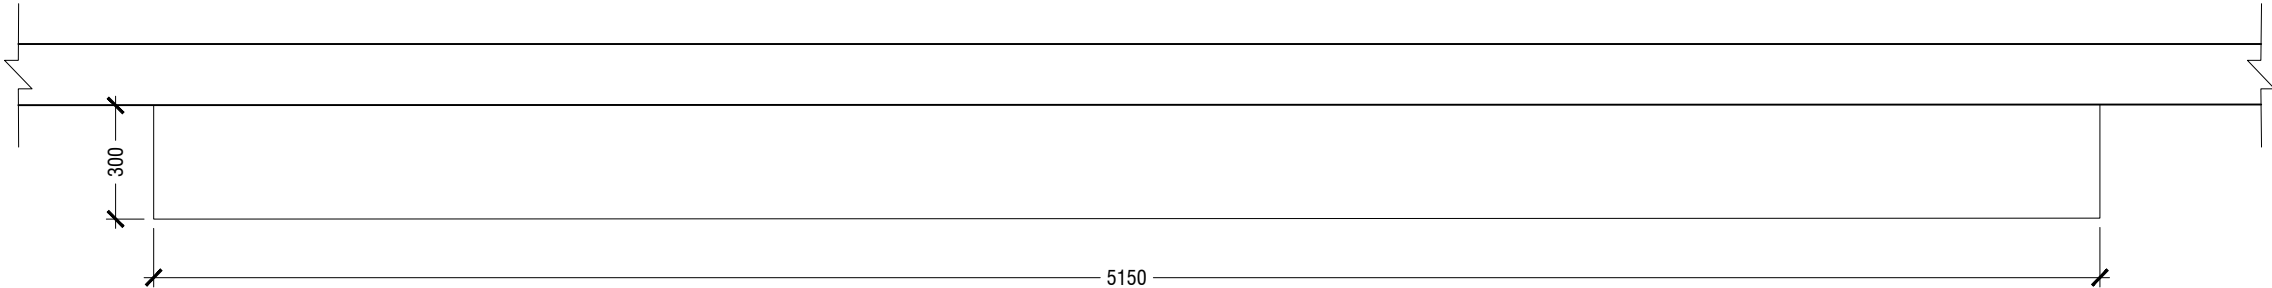

ELEVATION A

SECTION X



Contact: 7989966, 7691671

Email: info@maco.mv

CLIENT:

IGMH

PROJECT:

IGMH CATH LAB

K. MALE

SCALE: AS GIVEN

DRWNG TITLE : AS GIVN

DATE: D015M07Y26

REVISION NO.: 00

FILE NAME:

\\DLINK-031BBD\Volume_1\MACO PROJECTS\2026

WARNING:

- This drawing shall not be used for construction unless certified.
- Contractor to verify all dimensions of existing works on site before commencing any work or preparing shop drawings.
- Do not scale drawings, use written dimensions only.
- This drawing is to be read in conjunction with the specifications and conditions of contract.
- This drawing and design is copyright and no portion may be reproduced without the permission of the MACO architects



1.23 WALL MOUNTED SHELVES
LOCATION "CATH LAB STORE"
SCALE 1:20

ID42

- NOTE
- CL = CEILING LINE
 - DCL = DROP CEILING LINE
 - FFL = FLOOR FINISH LINE

*FINAL DIMENSIONS ARE SUBJECT TO CHANGE DEPENDING ON CONTRACTORS ADJUSTMENTS ON SITE

*SLANTED WALL ALIGNMENT TO BE CONFIRMED ON SITE

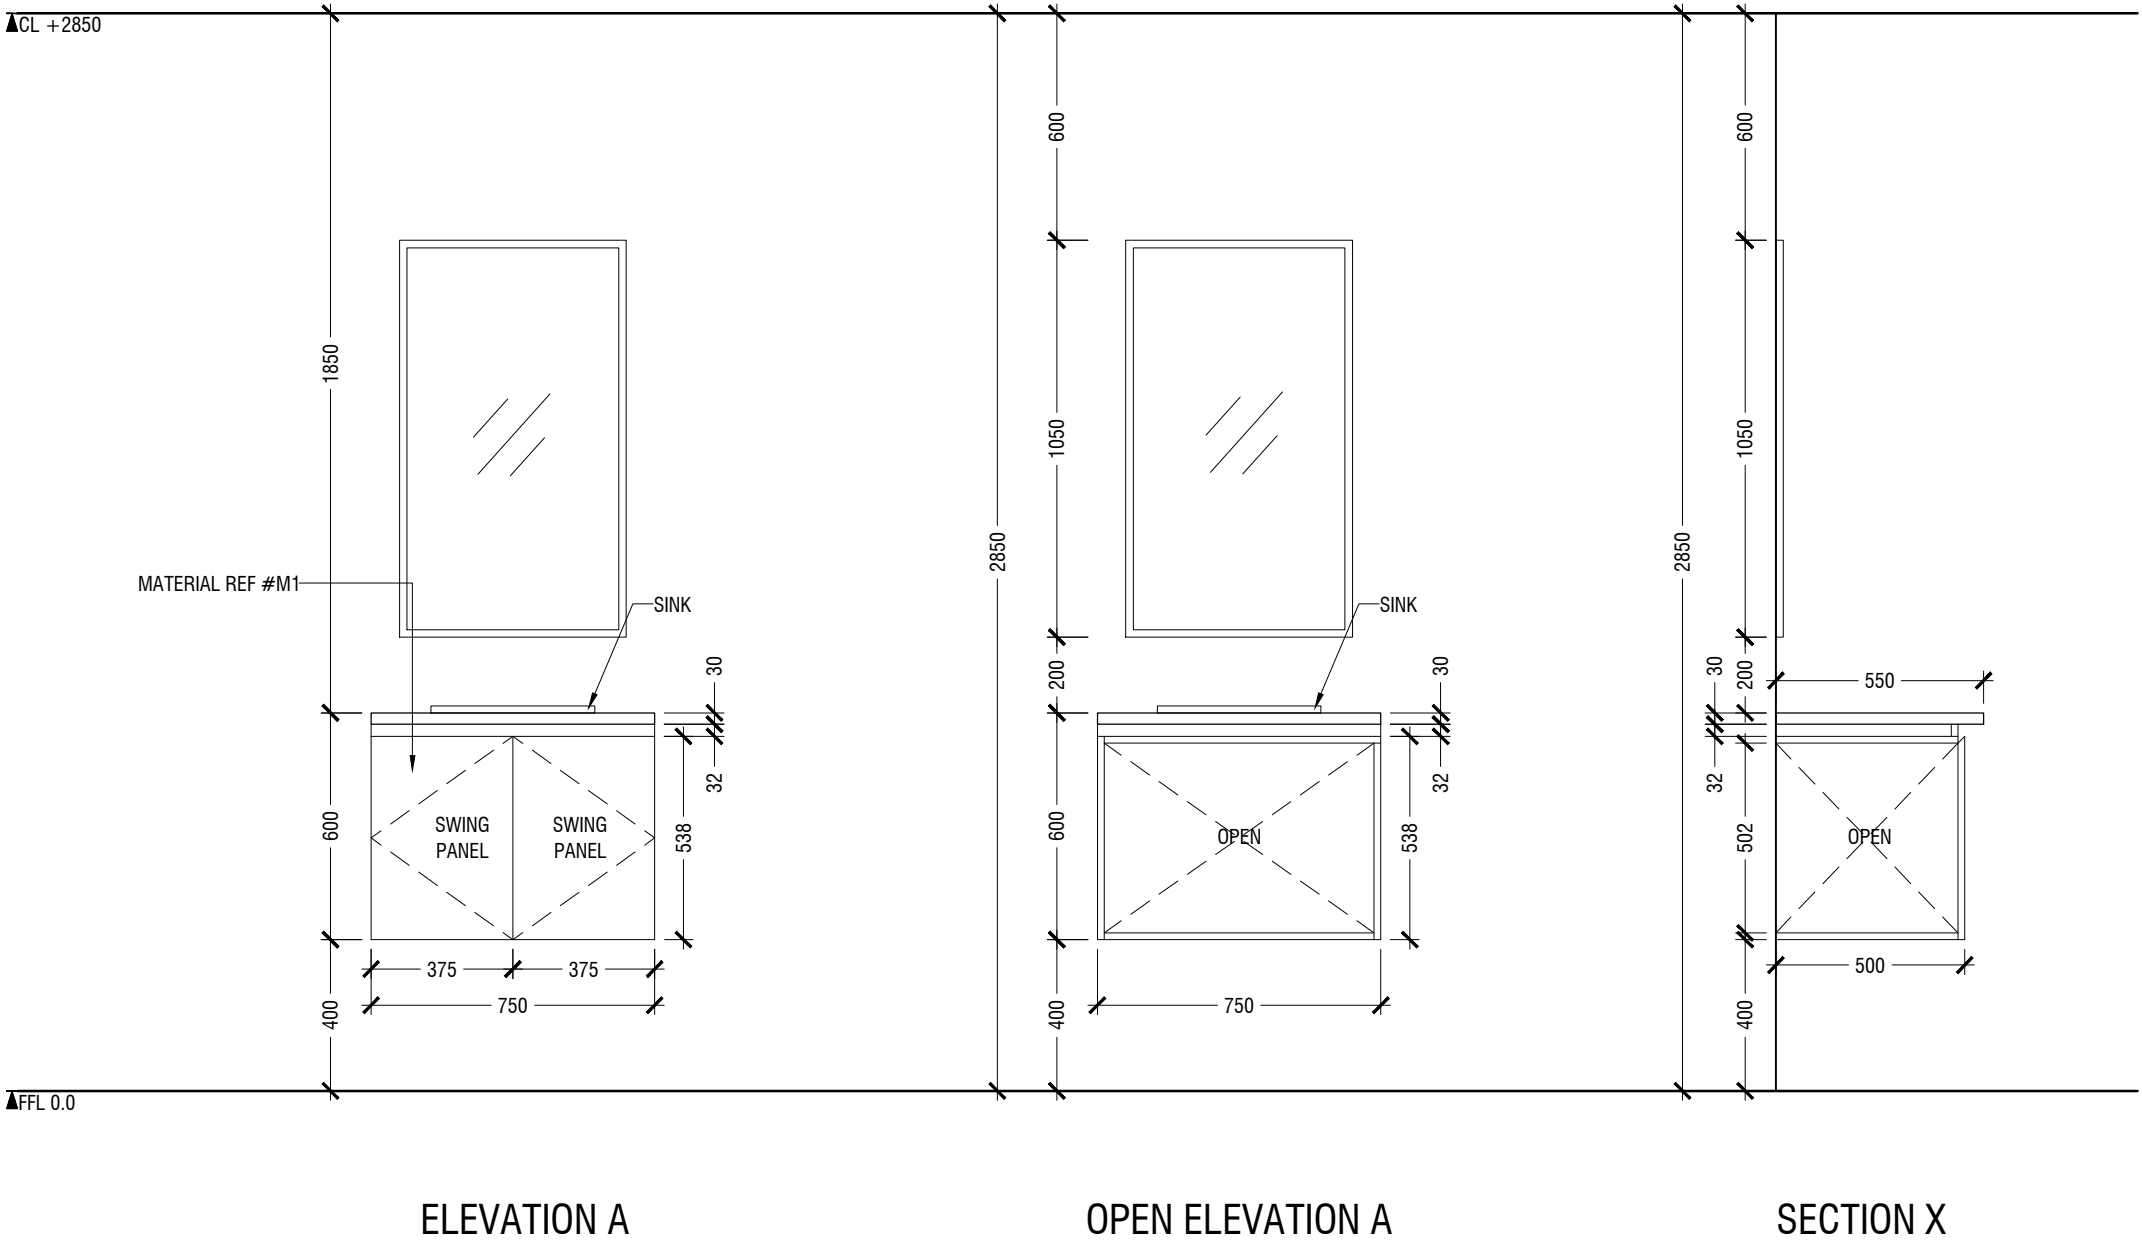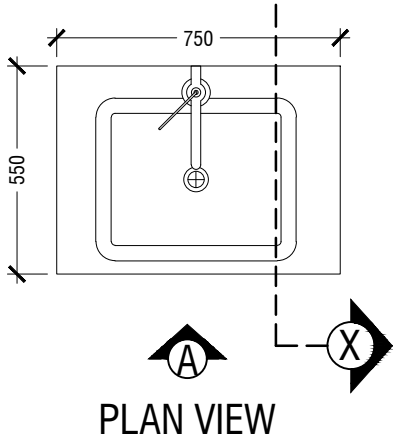

MACO
DESIGNS

Contact: 7989966, 7691671

Email: info@maco.mv

CLIENT:

IGMH

PROJECT:

IGMH CATH LAB

K. MALE

SCALE: AS GIVEN

DRWNG TITLE : AS GIVN

DATE: D015M07Y26

REVISION NO.: 00

FILE NAME:

\\DLINK-031BBD\Volume_1\MACO
PROJECTS\2026

WARNING:

- This drawing shall not be used for construction unless certified.
- Contractor to verify all dimensions of existing works on site before commencing any work or preparing shop drawings.
- Do not scale drawings, use written dimensions only.
- This drawing is to be read in conjunction with the specifications and conditions of contract.
- This drawing and design is copyright and no portion may be reproduced without the permission of the MACO architects



1.24 VANITY AREA
LOCATION "TOILET"
SCALE 1:20

ID43

- NOTE
- CL = CEILING LINE
 - DCL = DROP CEILING LINE
 - FFL = FLOOR FINISH LINE

*FINAL DIMENSIONS ARE SUBJECT TO CHANGE DEPENDING ON CONTRACTORS ADJUSTMENTS ON SITE

*SLANTED WALL ALIGNMENT TO BE CONFIRMED ON SITE

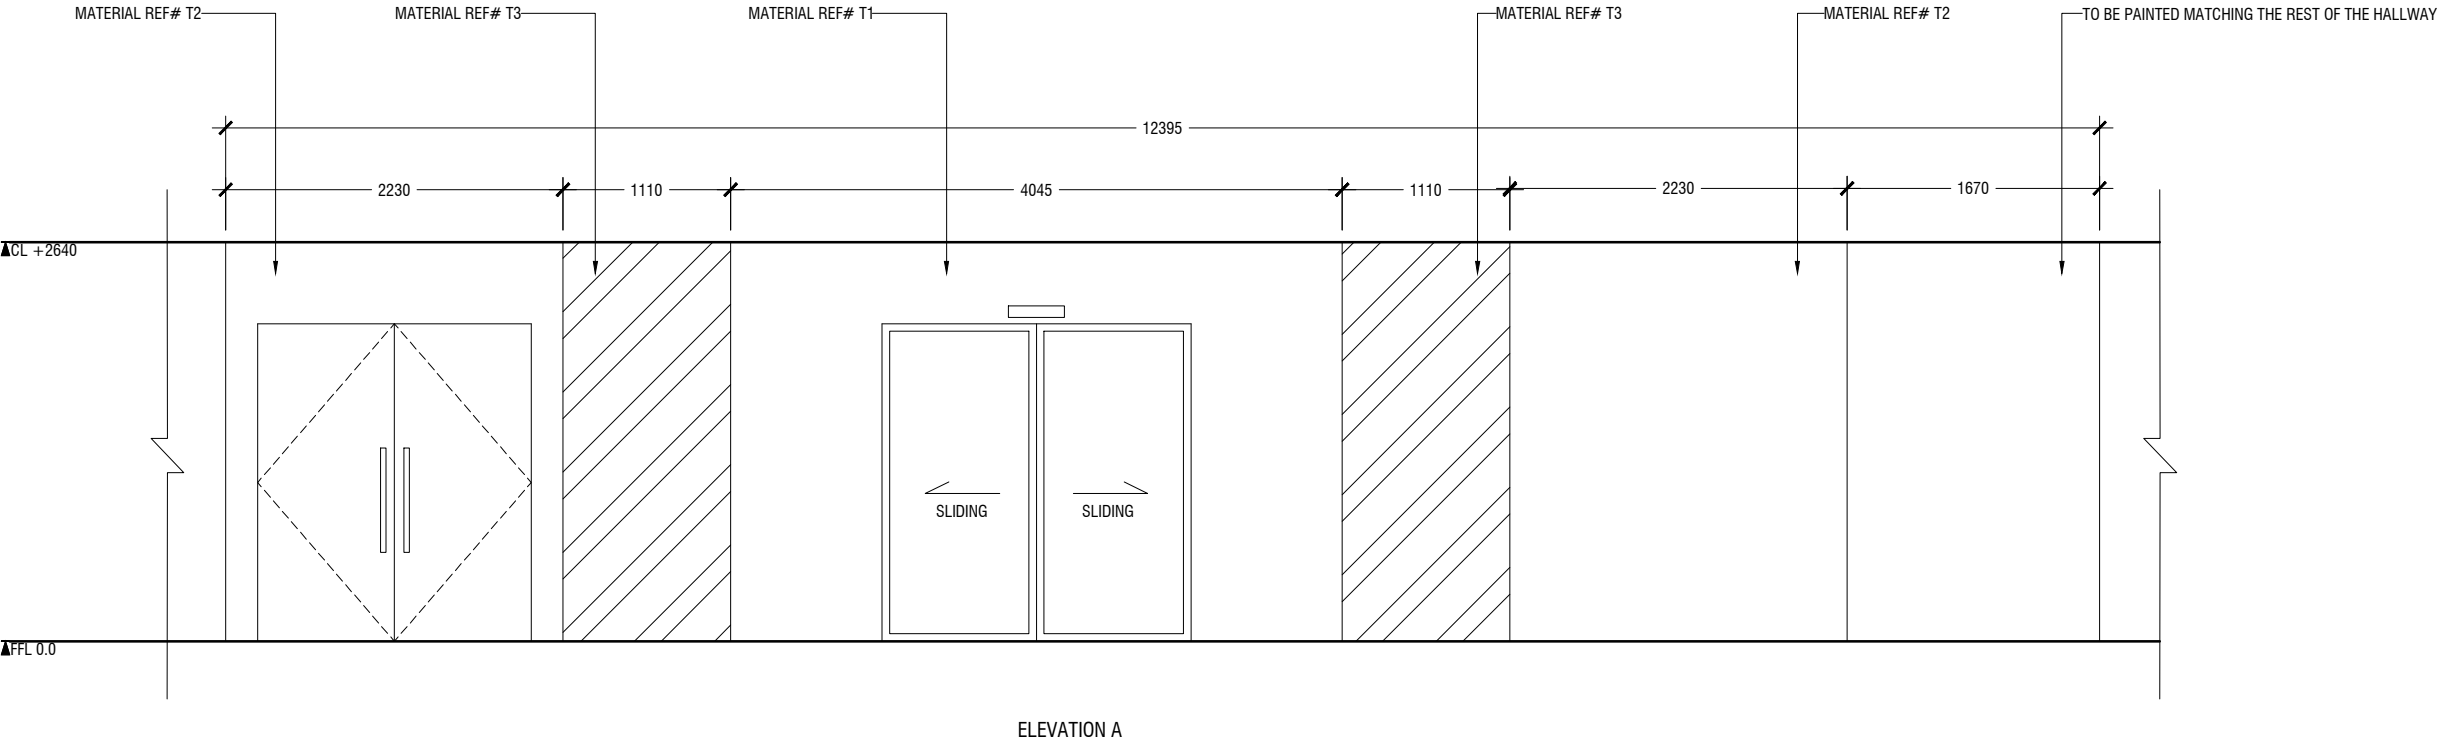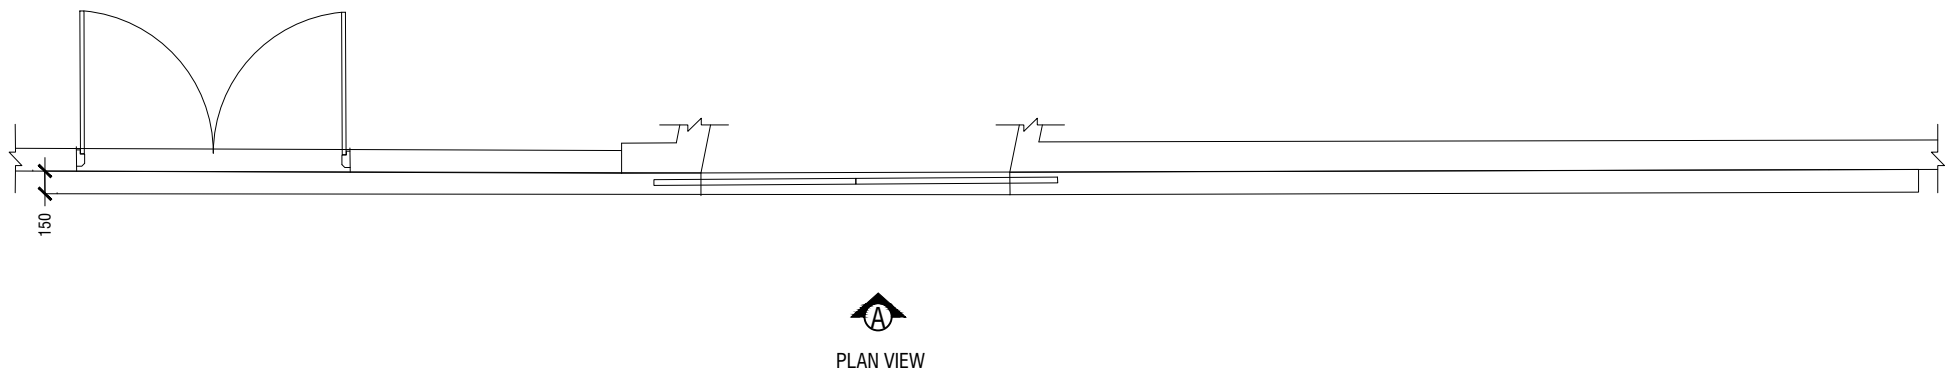

MACO
DESIGNS

Contact: 7989966, 7691671
Email: info@maco.mv

CLIENT:
IGMH

PROJECT:
IGMH CATH LAB
K. MALE

SCALE: AS GIVEN

DRWNG TITLE : AS GIVN

DATE: D015M07Y26

REVISION NO.: 00

FILE NAME:
\\DLINK-031BBD\\Volume_1\\MACO
PROJECTS\\2026

WARNING:

- This drawing shall not be used for construction unless certified.
- Contractor to verify all dimensions of existing works on site before commencing any work or preparing shop drawings.
- Do not scale drawings, use written dimensions only.
- This drawing is to be read in conjunction with the specifications and conditions of contract.
- This drawing and design is copyright and no portion may be reproduced without the permission of the MACO architects