



PROJECT:

**PROPOSED  
CENTRE FOR MENTAL HEALTH  
(PHASE - 2)  
@ IGMH MALE'**

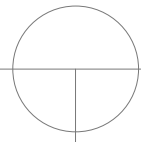



## PROPOSED FLOOR PLAN

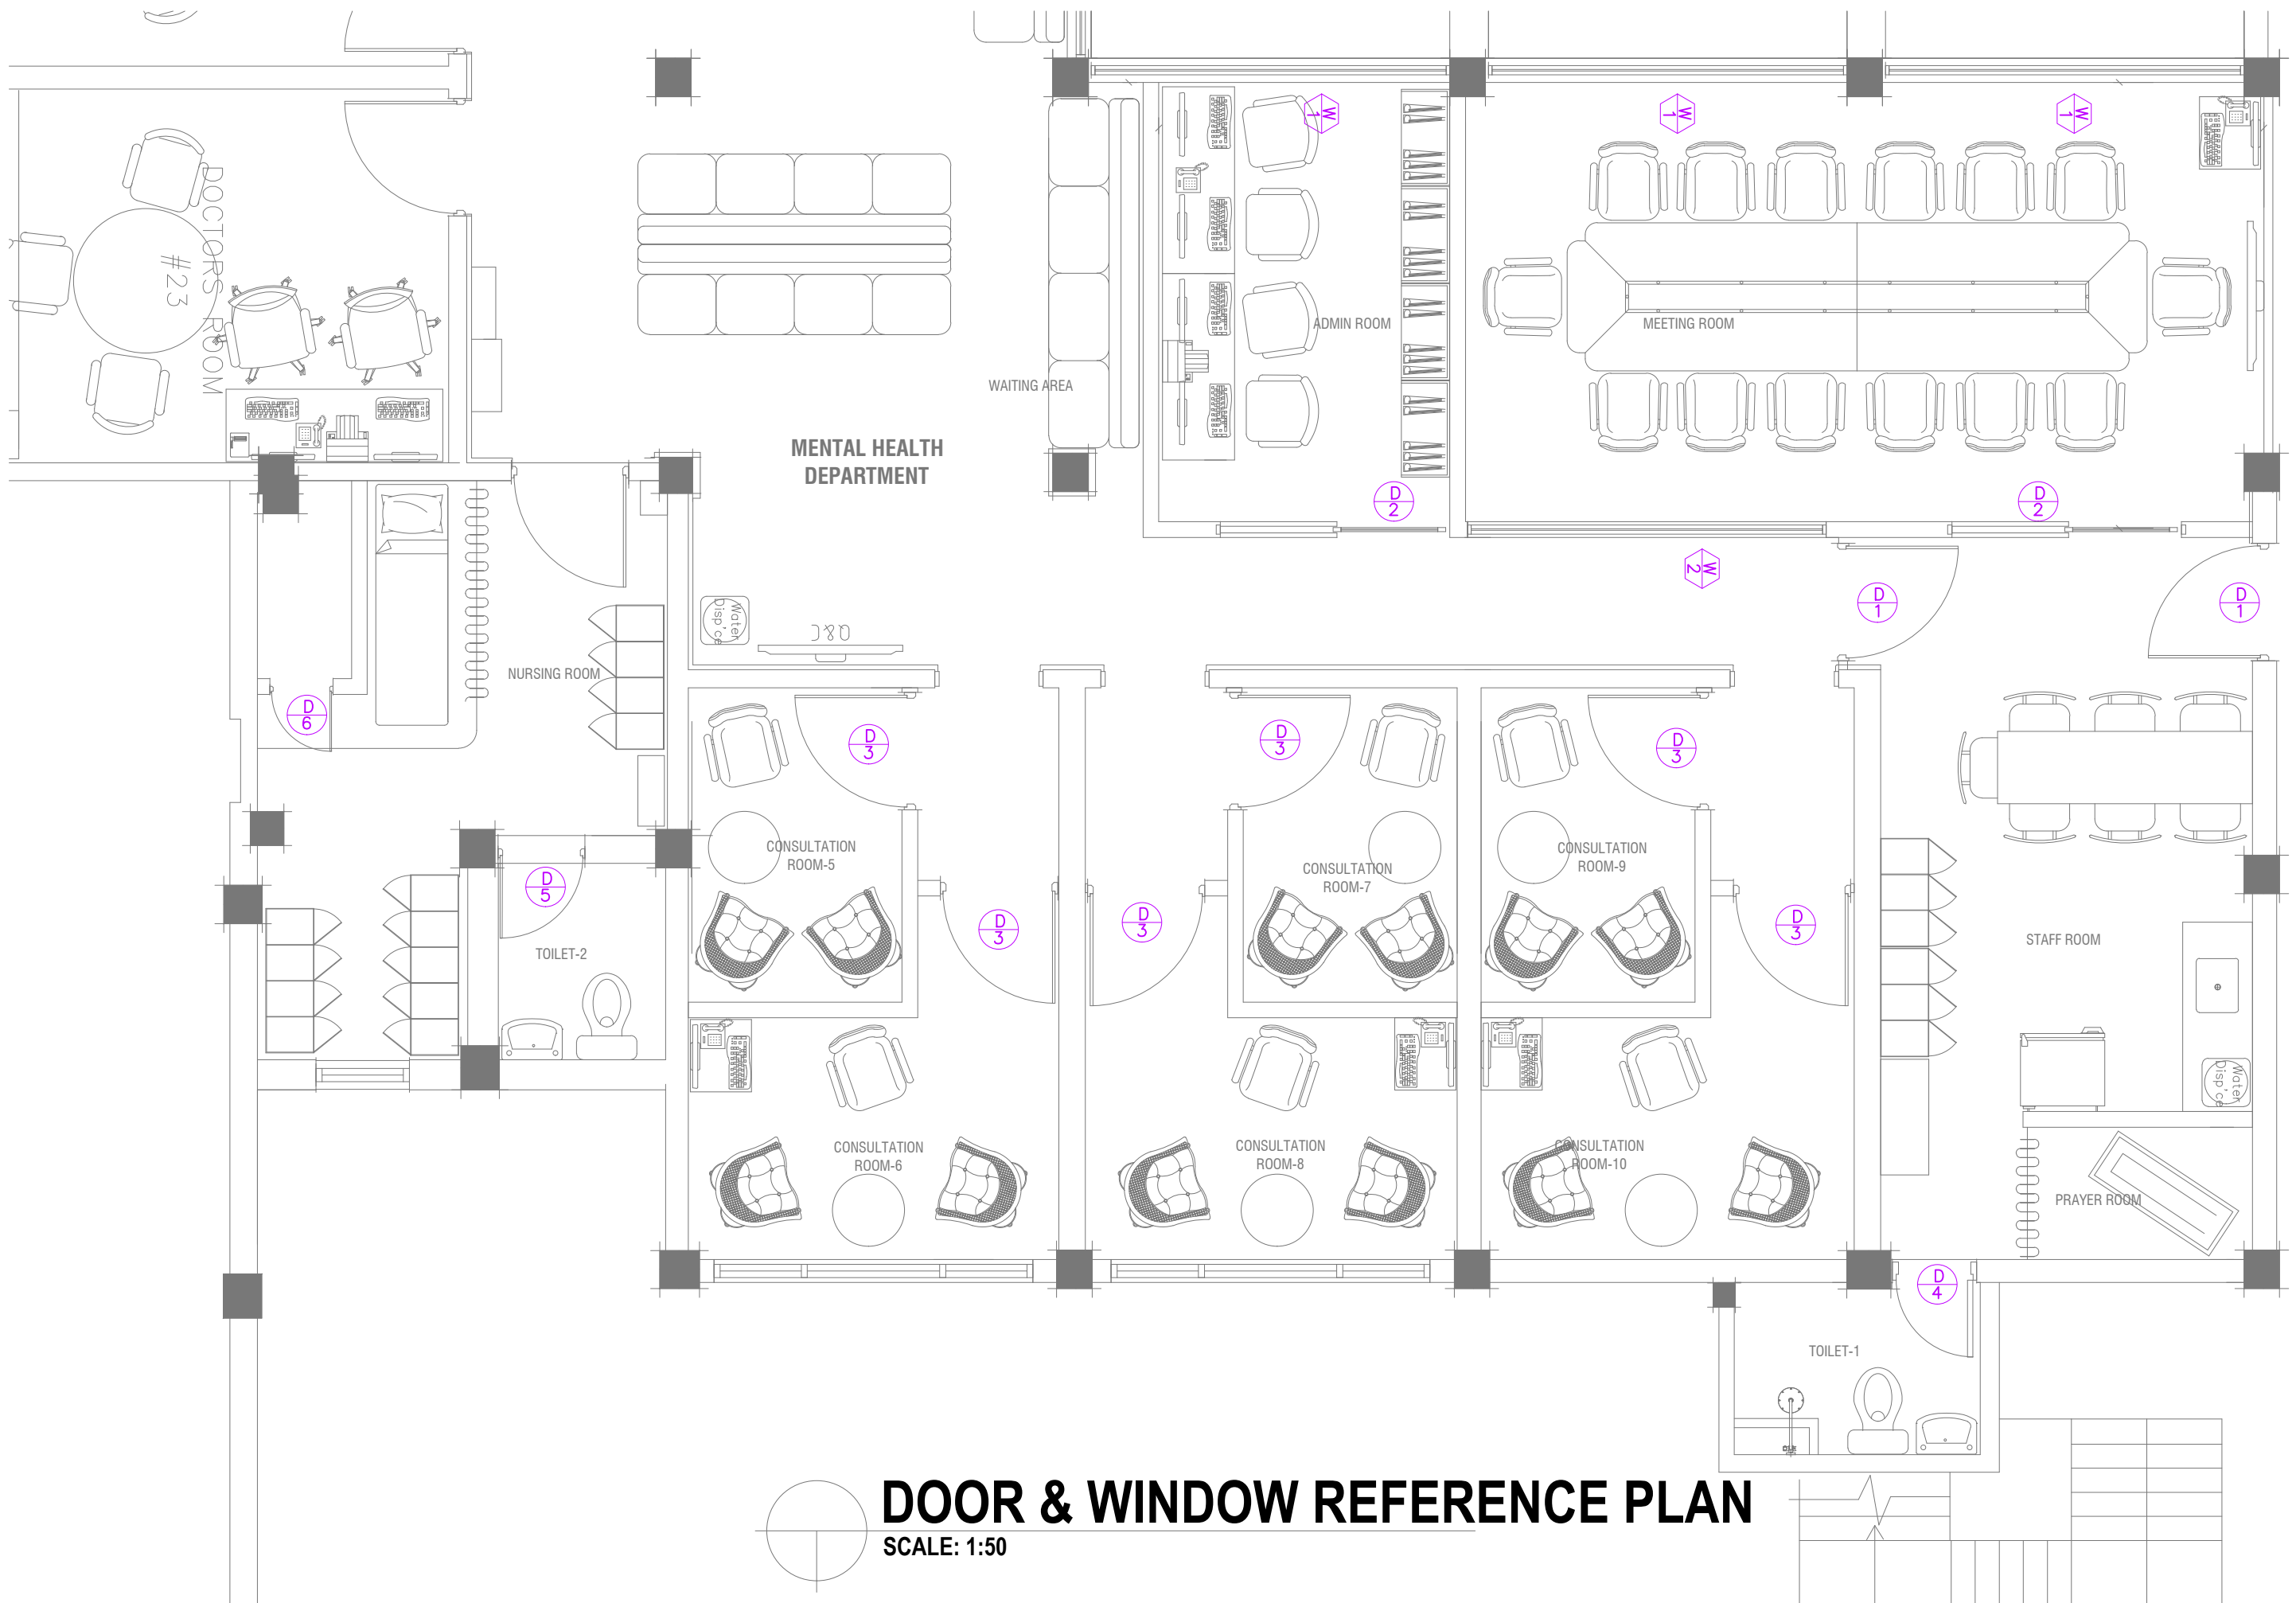

PROJECT :  
**PROPOSED CENTRE FOR MENTAL HEALTH (PHASE -2)**

TITLE: **AS MENTIONED**

Drawn : *Nausbad*  
Checked :  
SCALE: AS GIVEN  
Location: IGMH / GROUND FLOOR (MENTAL HEALTH)

REVISIONS	
Revised	15-02-2021
DATE :	07.01.2021

REMARKS :

APPROVED :


Projects Management Unit  
IGM Hospital / Kaibaa Aisarani Hingun  
Malé 20402 / Republic of Maldives

The contractors must check all dimensions on site prior to the commencement of any work.







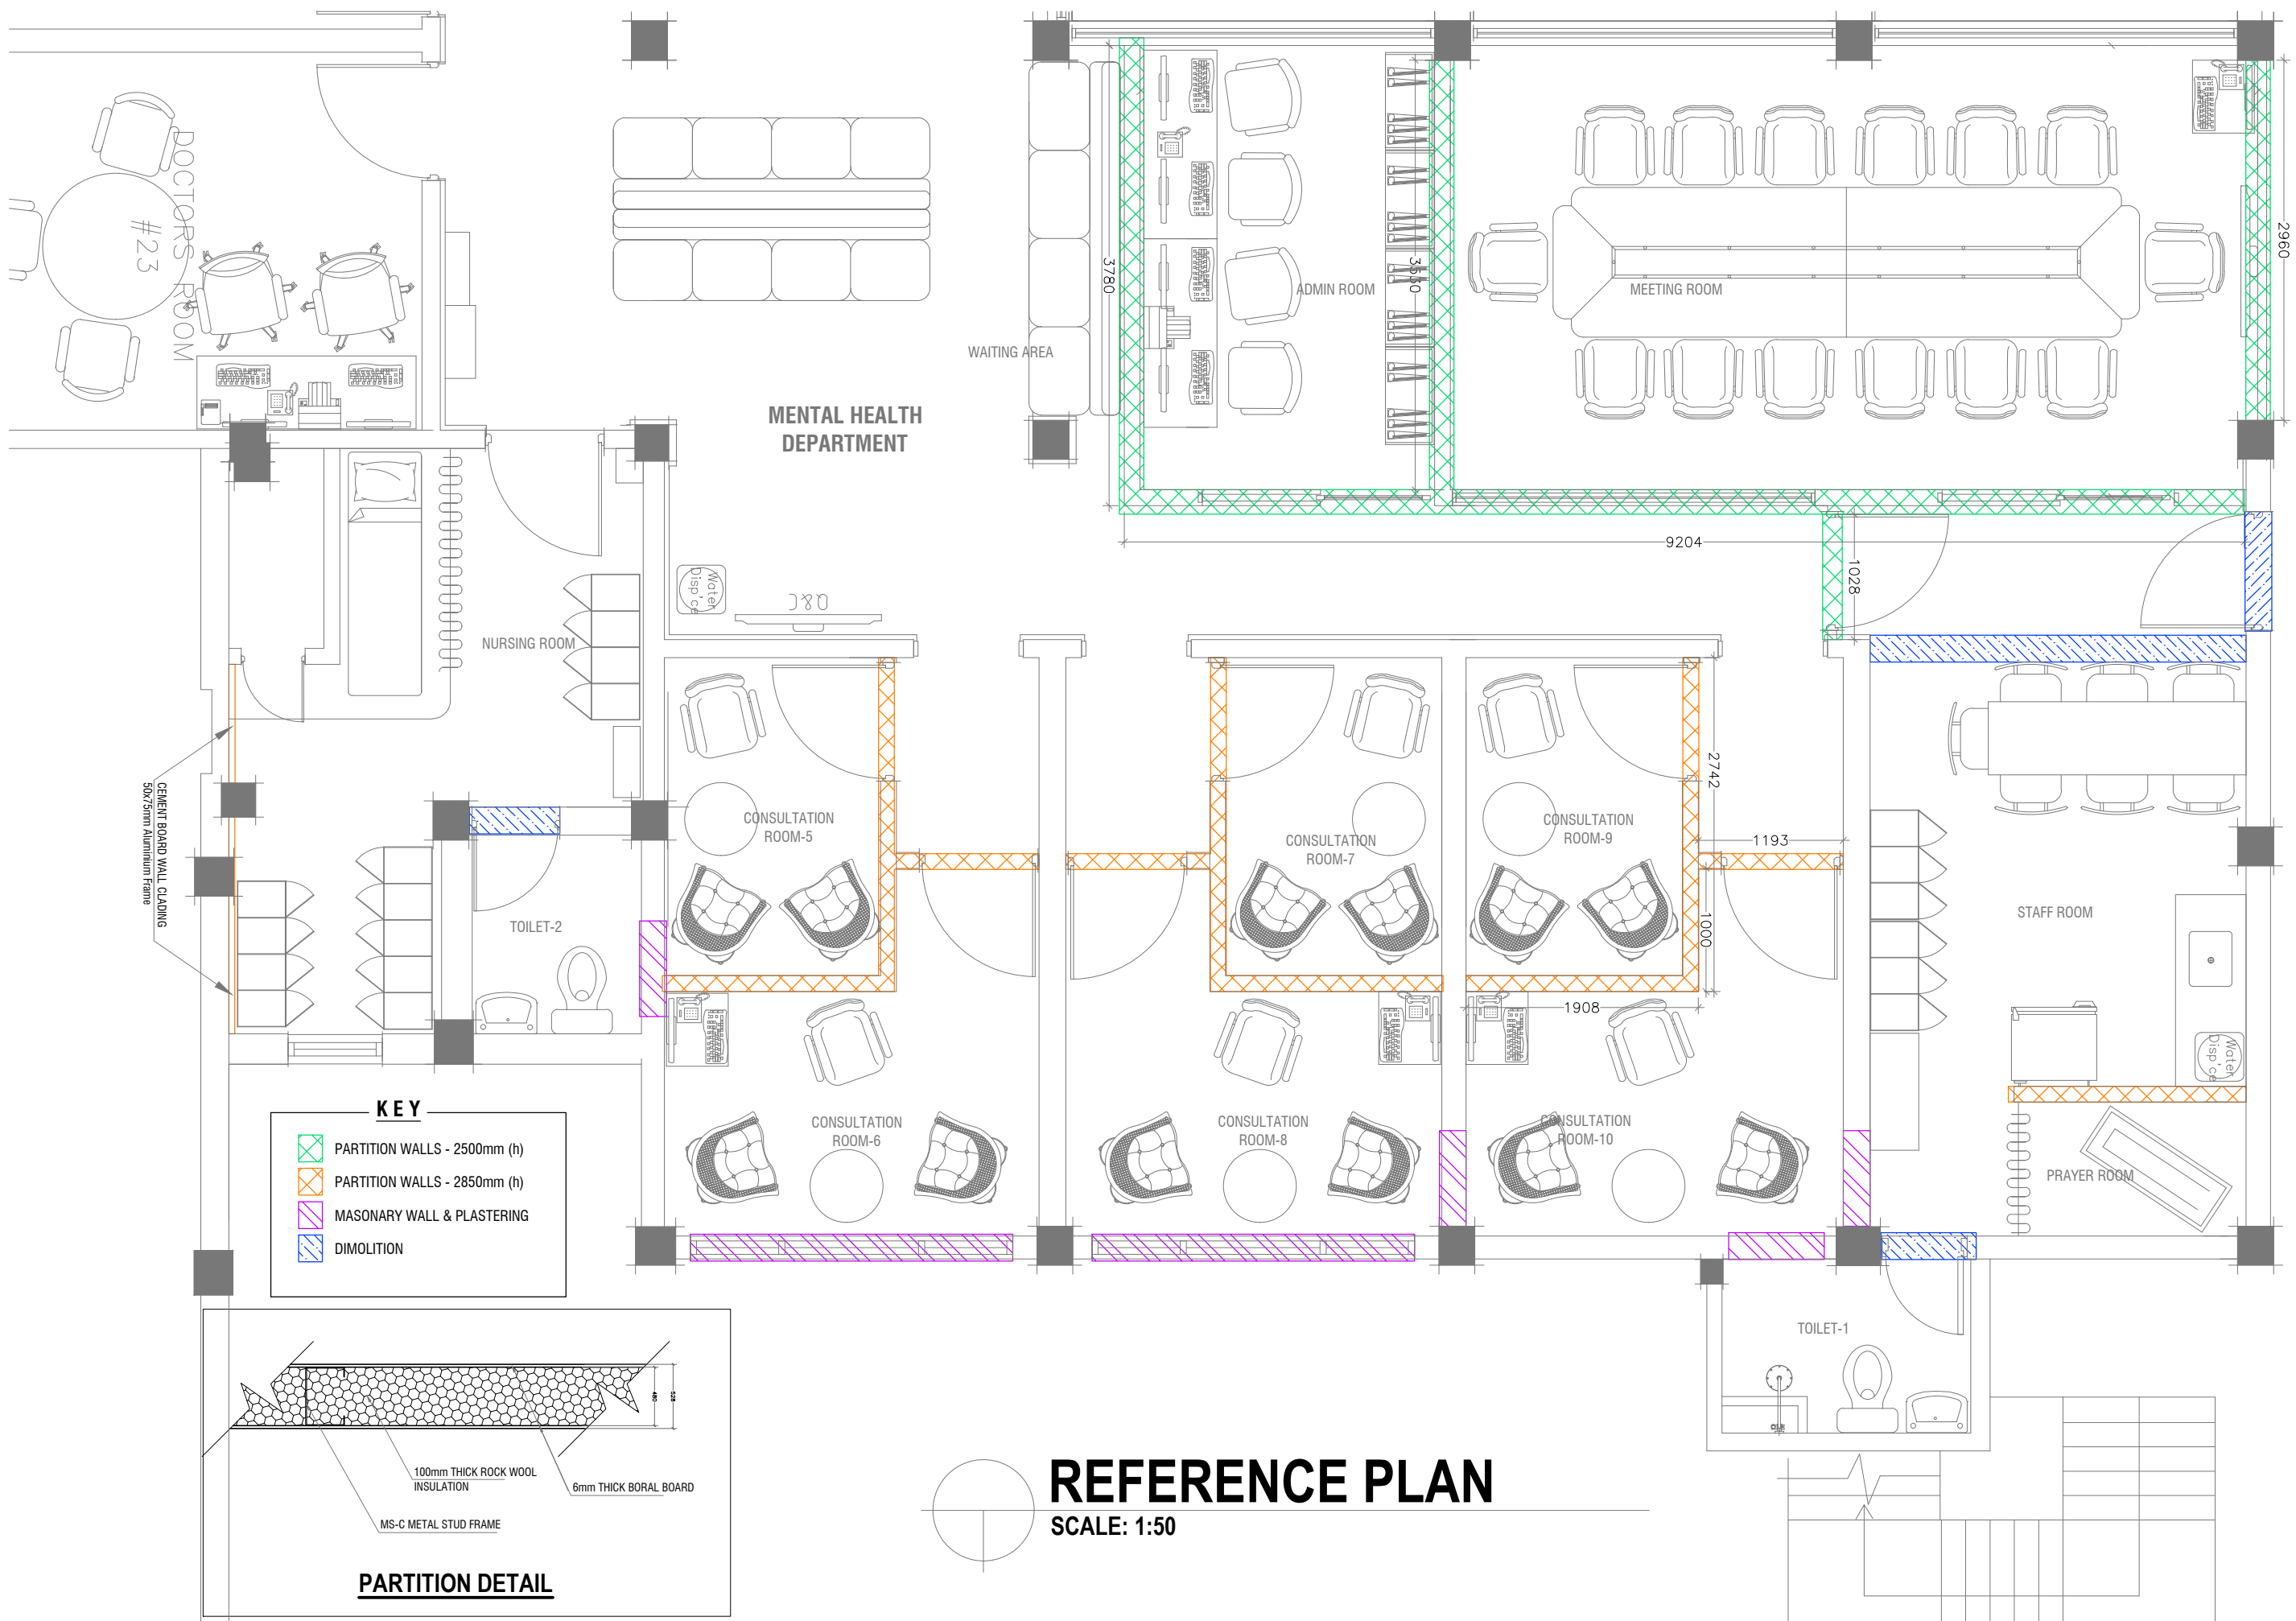

PROJECT :  
**PROPOSED CENTRE FOR MENTAL HEALTH (PHASE -2)**

TITLE: **AS MENTIONED**

Drawn : *Naushad*  
Checked :  
SCALE: AS GIVEN

REVISIONS

Revised	15-02-2021
DATE :	07.01.2021

Location: IGMH / GROUND FLOOR (MENTAL HEALTH)


REMARKS :

APPROVED :

Projects Management Unit  
IGM Hospital / Kaibaa Aisarani Hingun  
Malé 20402 / Republic of Maldives

The contractors must check all dimensions on site prior to the commencement of any work.



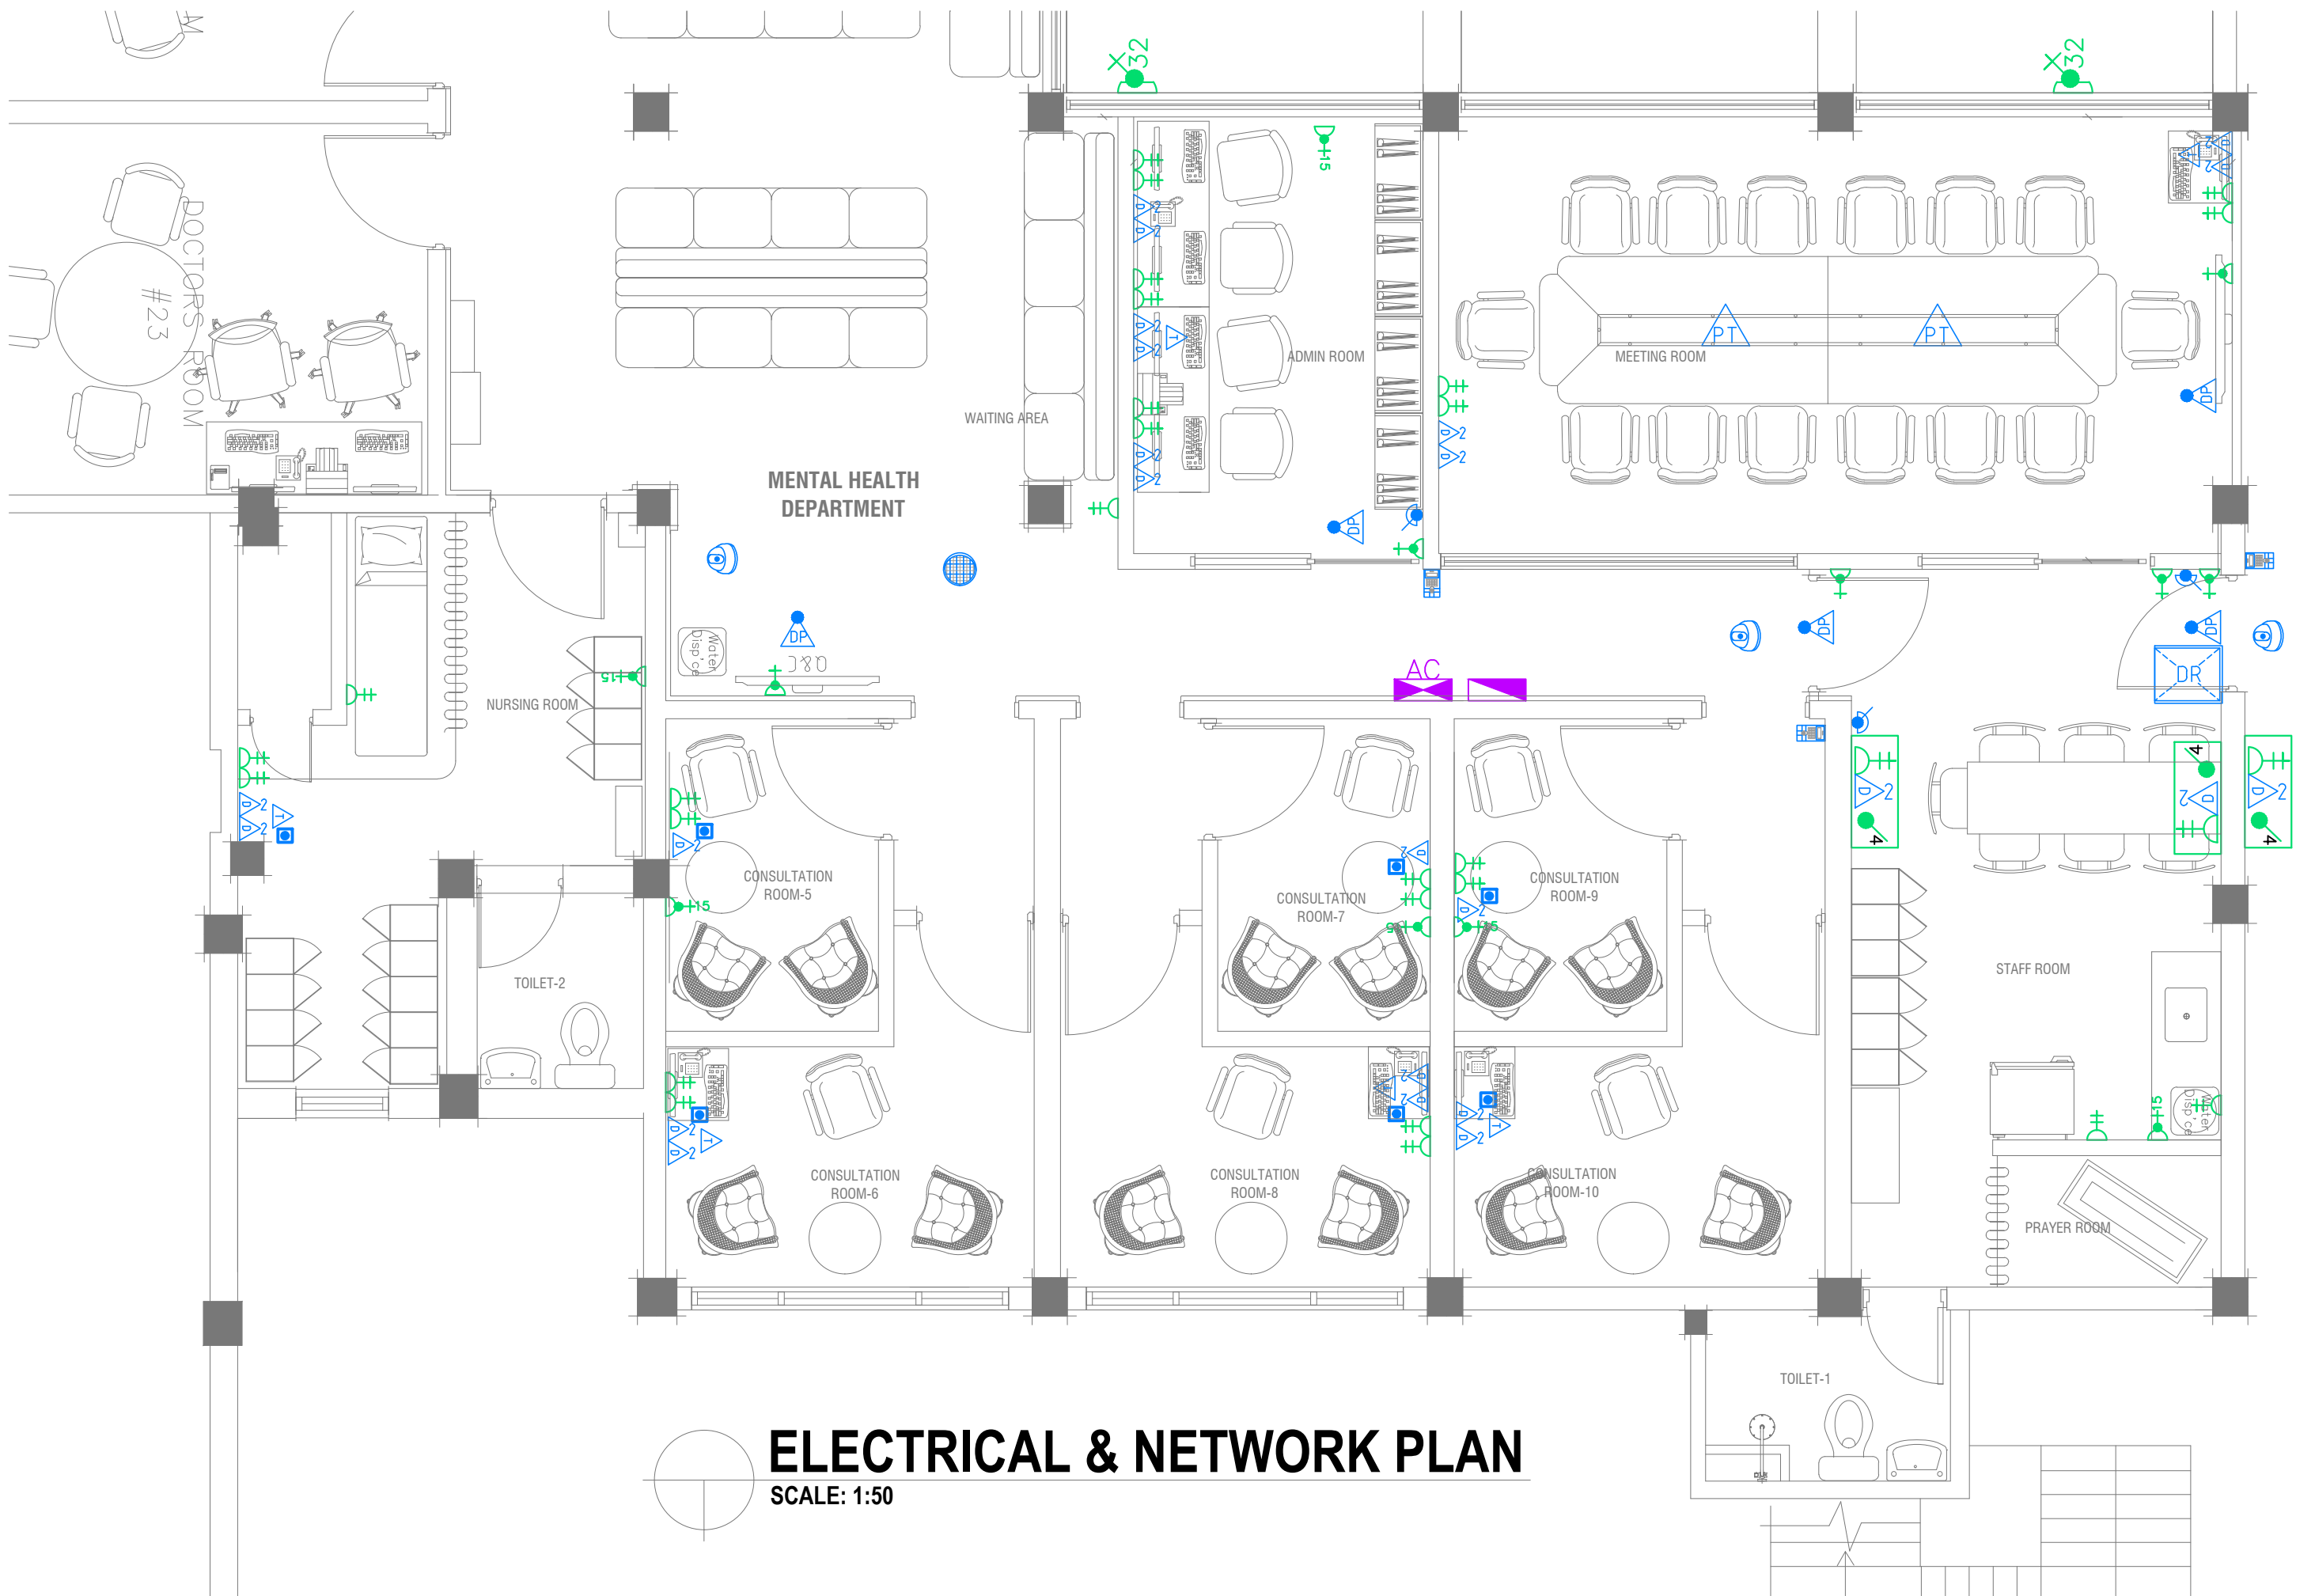

PROJECT :  
**PROPOSED CENTRE FOR MENTAL HEALTH (PHASE -2)**

TITLE: **AS MENTIONED**

Drawn : *Naushad*  
Checked :  
SCALE: AS GIVEN

REVISIONS

Revised	DATE
15-02-2021	07.01.2021

Location: IGMH / GROUND FLOOR (MENTAL HEALTH)


REMARKS :

APPROVED :

Projects Management Unit  
IGM Hospital / Kaibaa Aisarani Hingun  
Malé 20402 / Republic of Maldives

The contractors must check all dimensions on site prior to the commencement of any work.



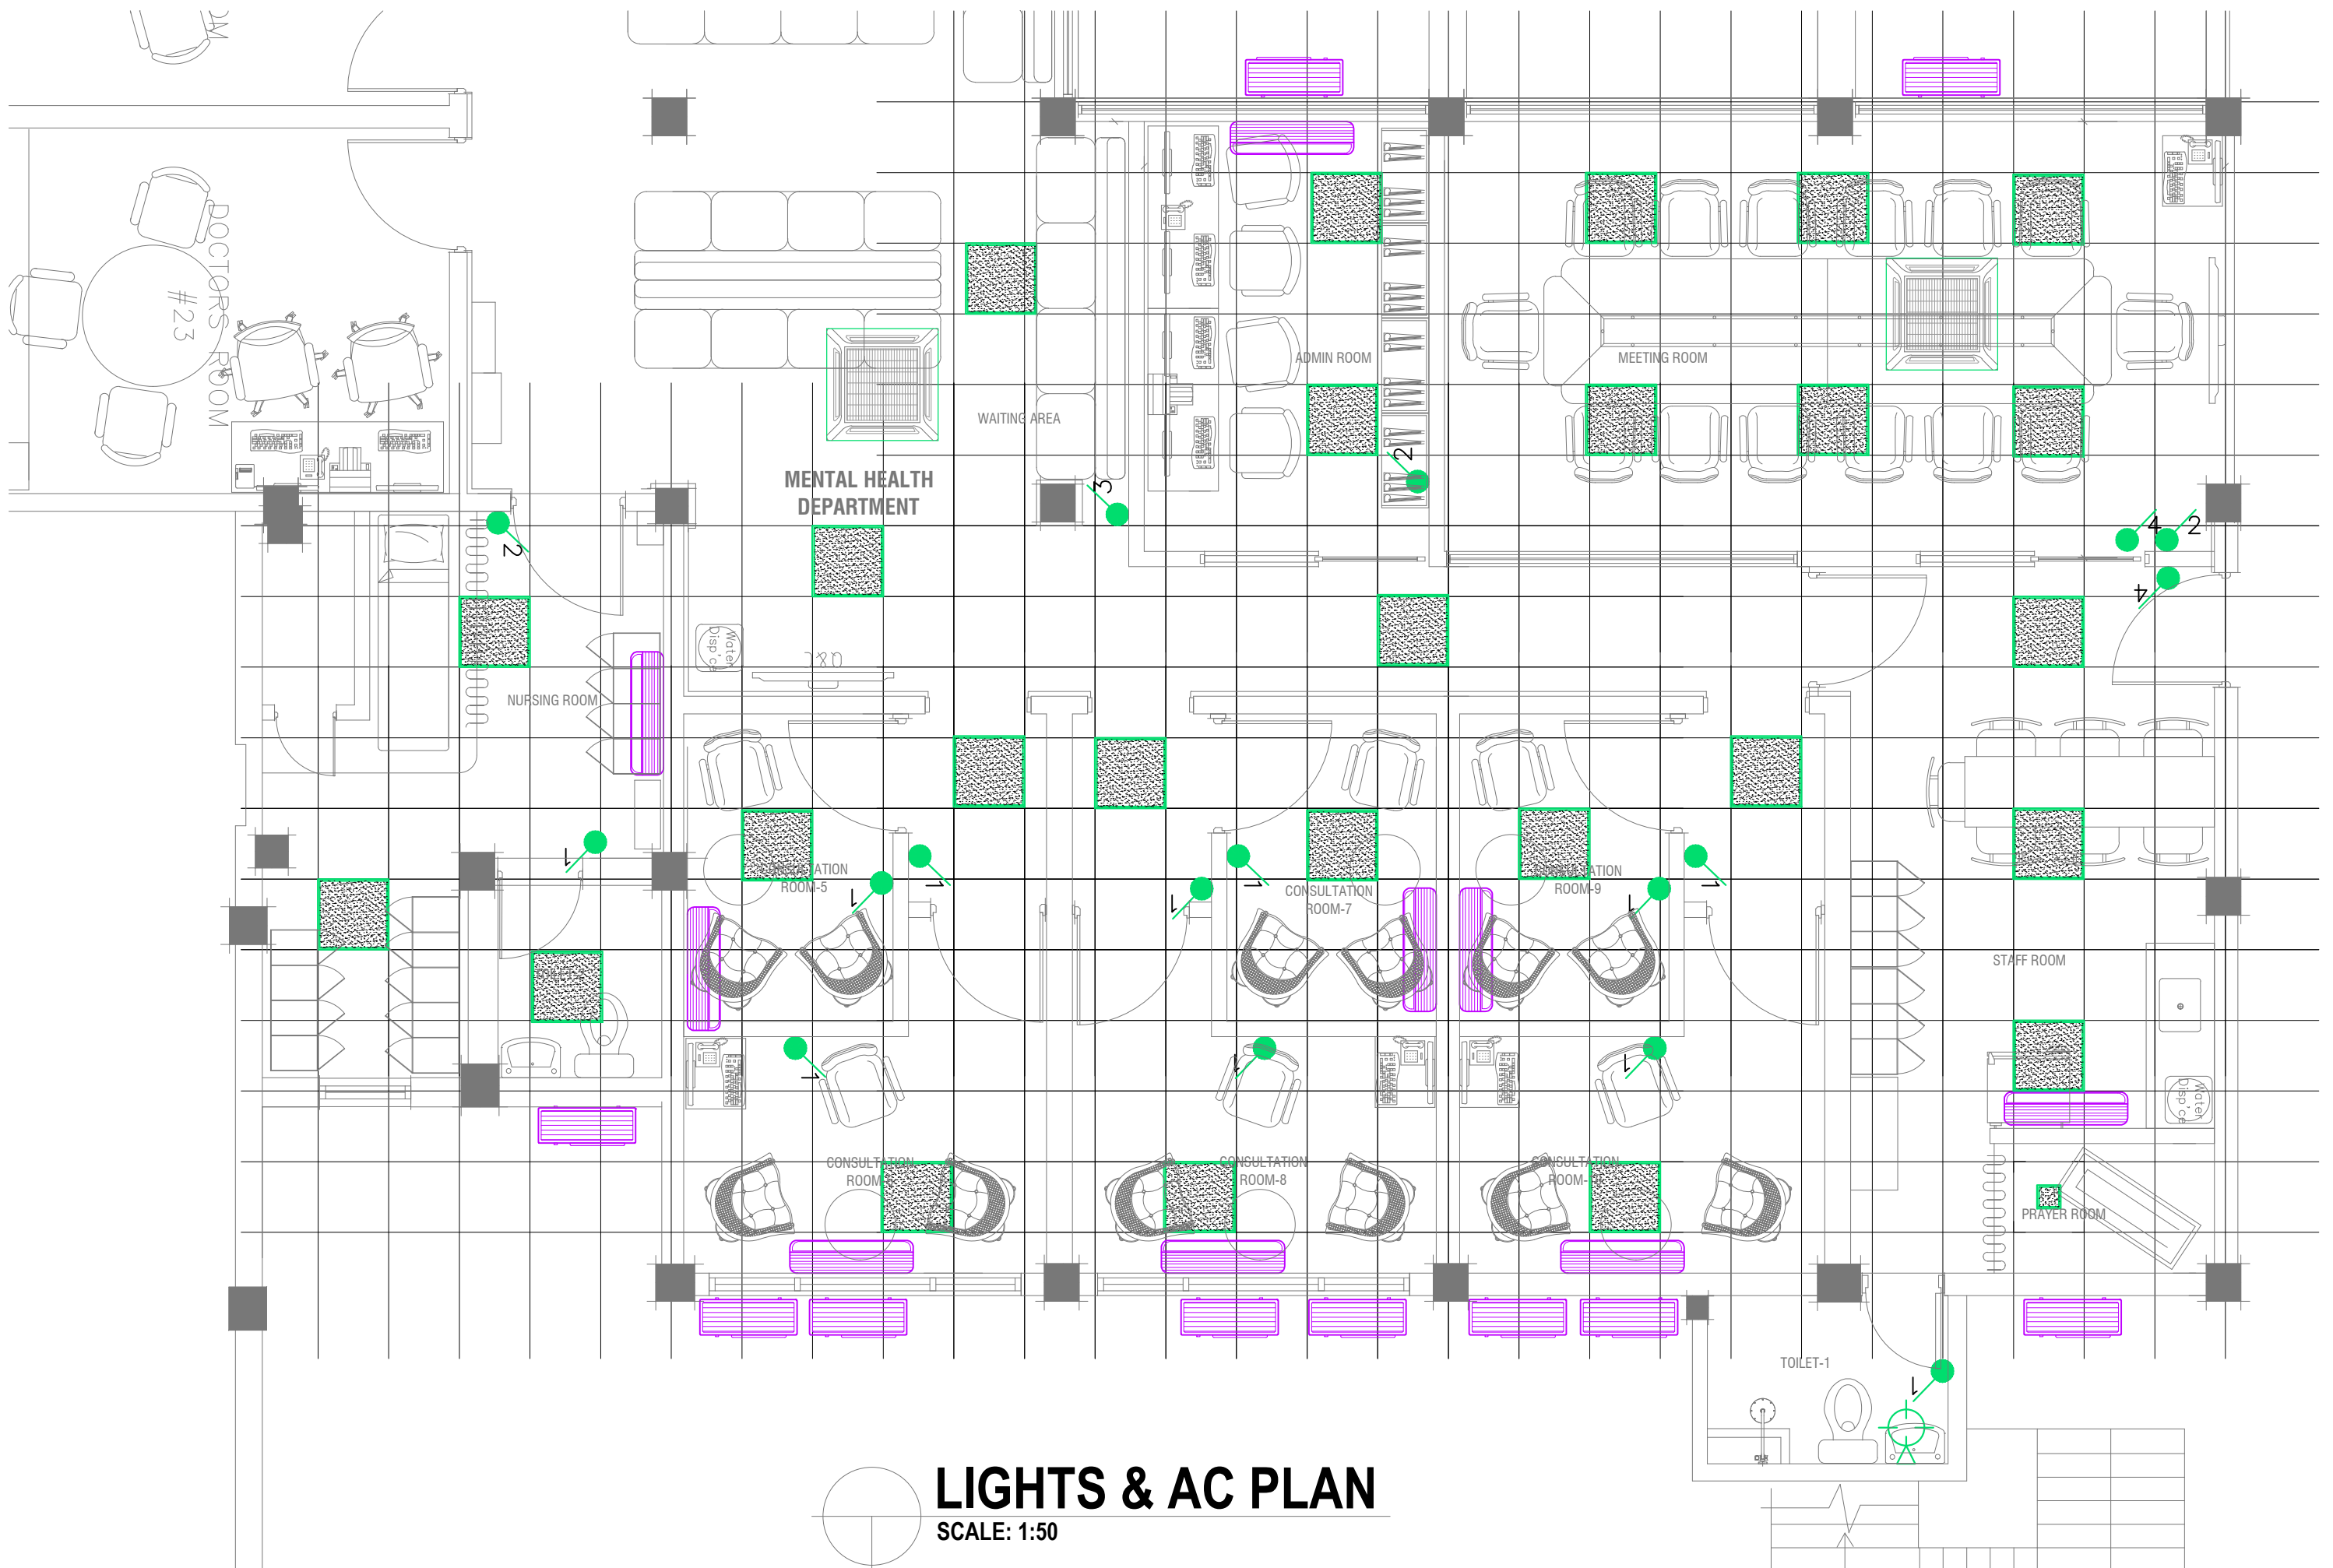

PROJECT :  
**PROPOSED CENTRE FOR MENTAL HEALTH (PHASE -2)**

TITLE: AS MENTIONED

Drawn : *Naushad*  
Checked :  
SCALE: AS GIVEN  
Location: IGMH / GROUND FLOOR (MENTAL HEALTH)

REVISIONS	
Revised	15-02-2021
DATE	07.01.2021

REMARKS :

APPROVED :










Projects Management Unit  
IGM Hospital / Kaibaa Aisarani Hingun  
Malé 20402 / Republic of Maldives

The contractors must check all dimensions on site prior to the commencement of any work.

 












 




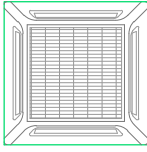



# DATA & NETWORK LEGEND

SYMBOL	DESCRIPTION
	1x2 DATA – OUTLET
	TELEPHONE – OUTLET
	POKE THROUGH SOCKET
	CCTV CAMERA (DOME)
	Q–TV /CABLE–TV Data Point
	ACCESS CONTROLLER (SECURITY ENTRY SYSTEM)
	EXIT SWITCH
	DETA POINT (@ CEILING LEVEL)
	SWITCH RACK

# ELECTRICAL LEGEND

SYMBOL	DESCRIPTION
	CEILING RESIST LED LIGHT 600x600mm (36 watts)
	ONE WAY SWITCH
	TWO GANG SWITCH
	THREE GANG SWITCH
	FOUR GANG SWITCH
	AC INDOOR UNIT
	AC OUTDOOR UNIT
	POWER & LIGHTING DISTRIBUTION BOARD
	Air cone–DISTRIBUTION BOARD
	Emergency Call Button
	Emergency Call System (to reception)
	2x13 amp Socket Outlet (Live)
	2x13 amp Socket Outlet (Live) (@ Ceiling Level)
	1x13 amp Socket Outlet (Live) (@ Ceiling Level)
	1x15 amp Socket Outlet (Live) (@ Ceiling Level)
	1x32 amp Isolator (@ Ceiling Level)
	Ceiling Resist Speaker Indication light
	RELOCATION OF EXISTING SWITCH, SOCKETS & DATA POINTS

PROJECT :  
PROPOSED CENTRE FOR MENTAL HEALTH (PHASE -2)

TITLE: AS MENTIONED

Drawn : Nausbad

Checked :

SCALE: AS GIVEN

Location: IGMH / GROUND FLOOR (MENTAL HEALTH)

REVISIONS

Revised

15-02-2021

DATE : 07.01.2021


REMARKS :

APPROVED :


Projects Management Unit  
IGM Hospital / Kaibaa Aisarani Hingun  
Malé 20402 / Republic of Maldives

The contractors must check all dimensions on  
site prior to the commencement of any work.



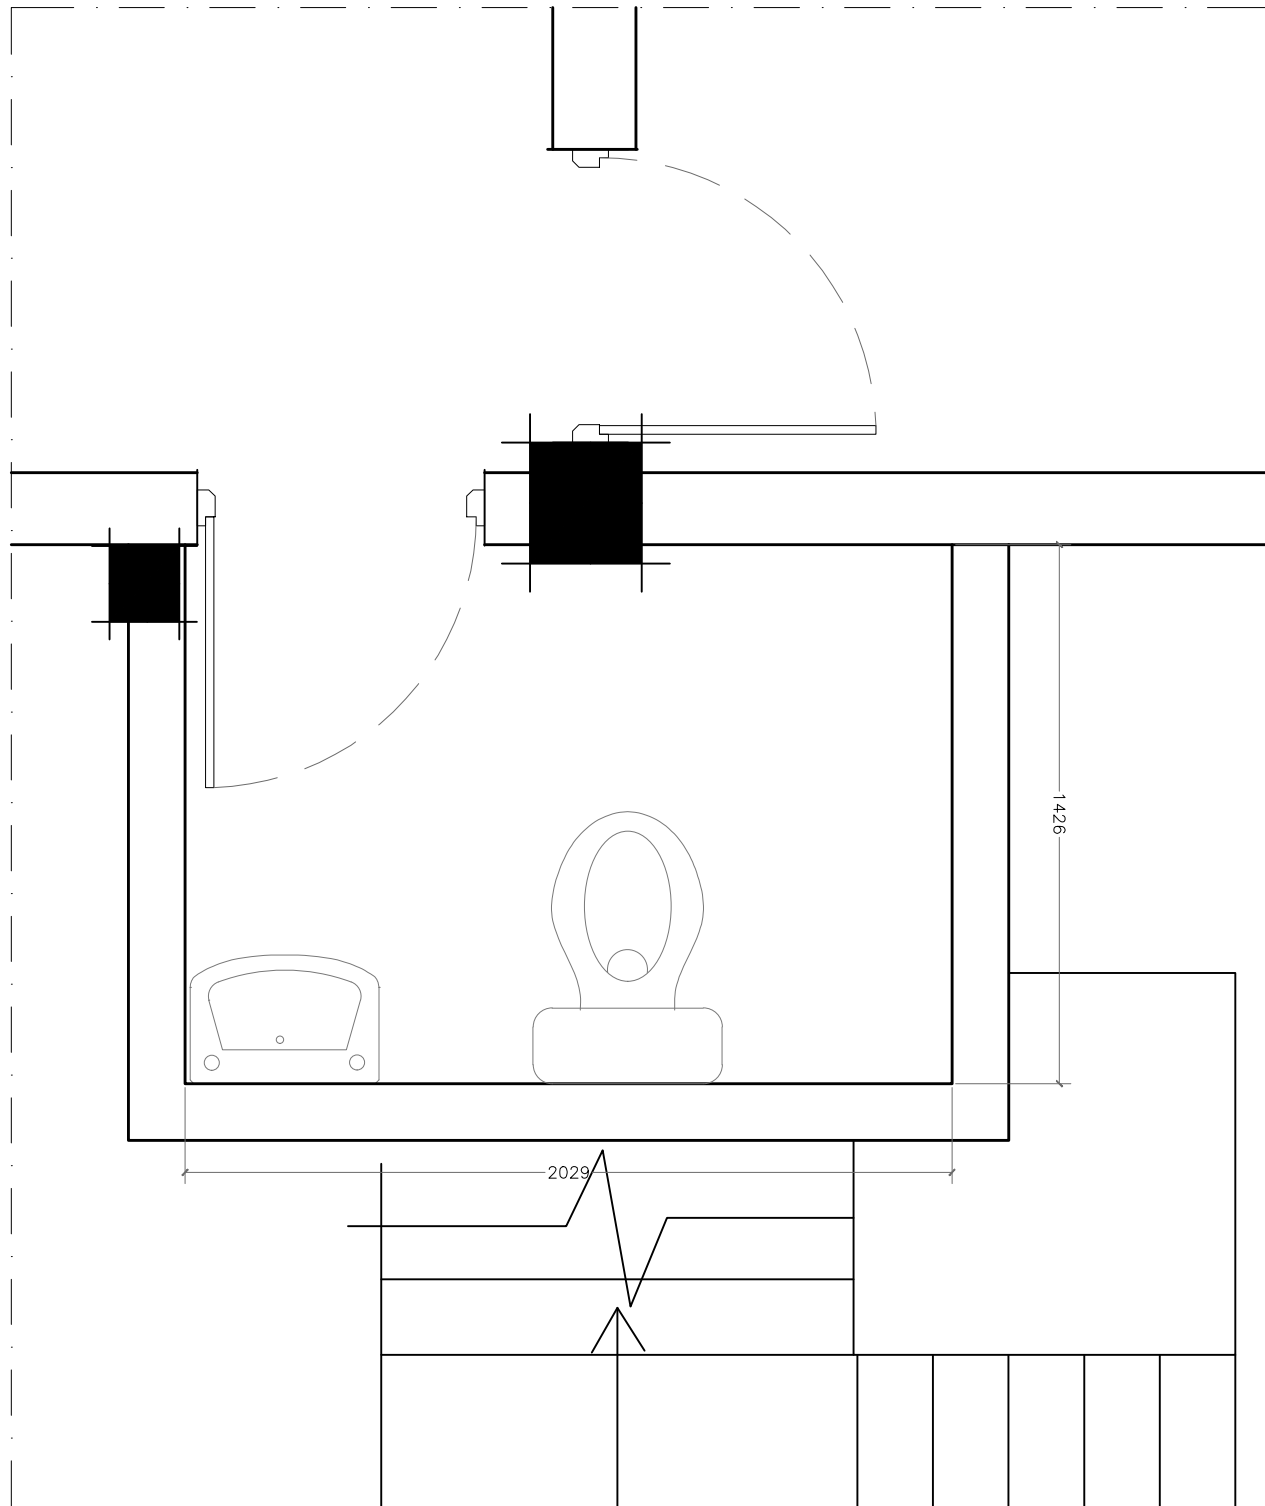


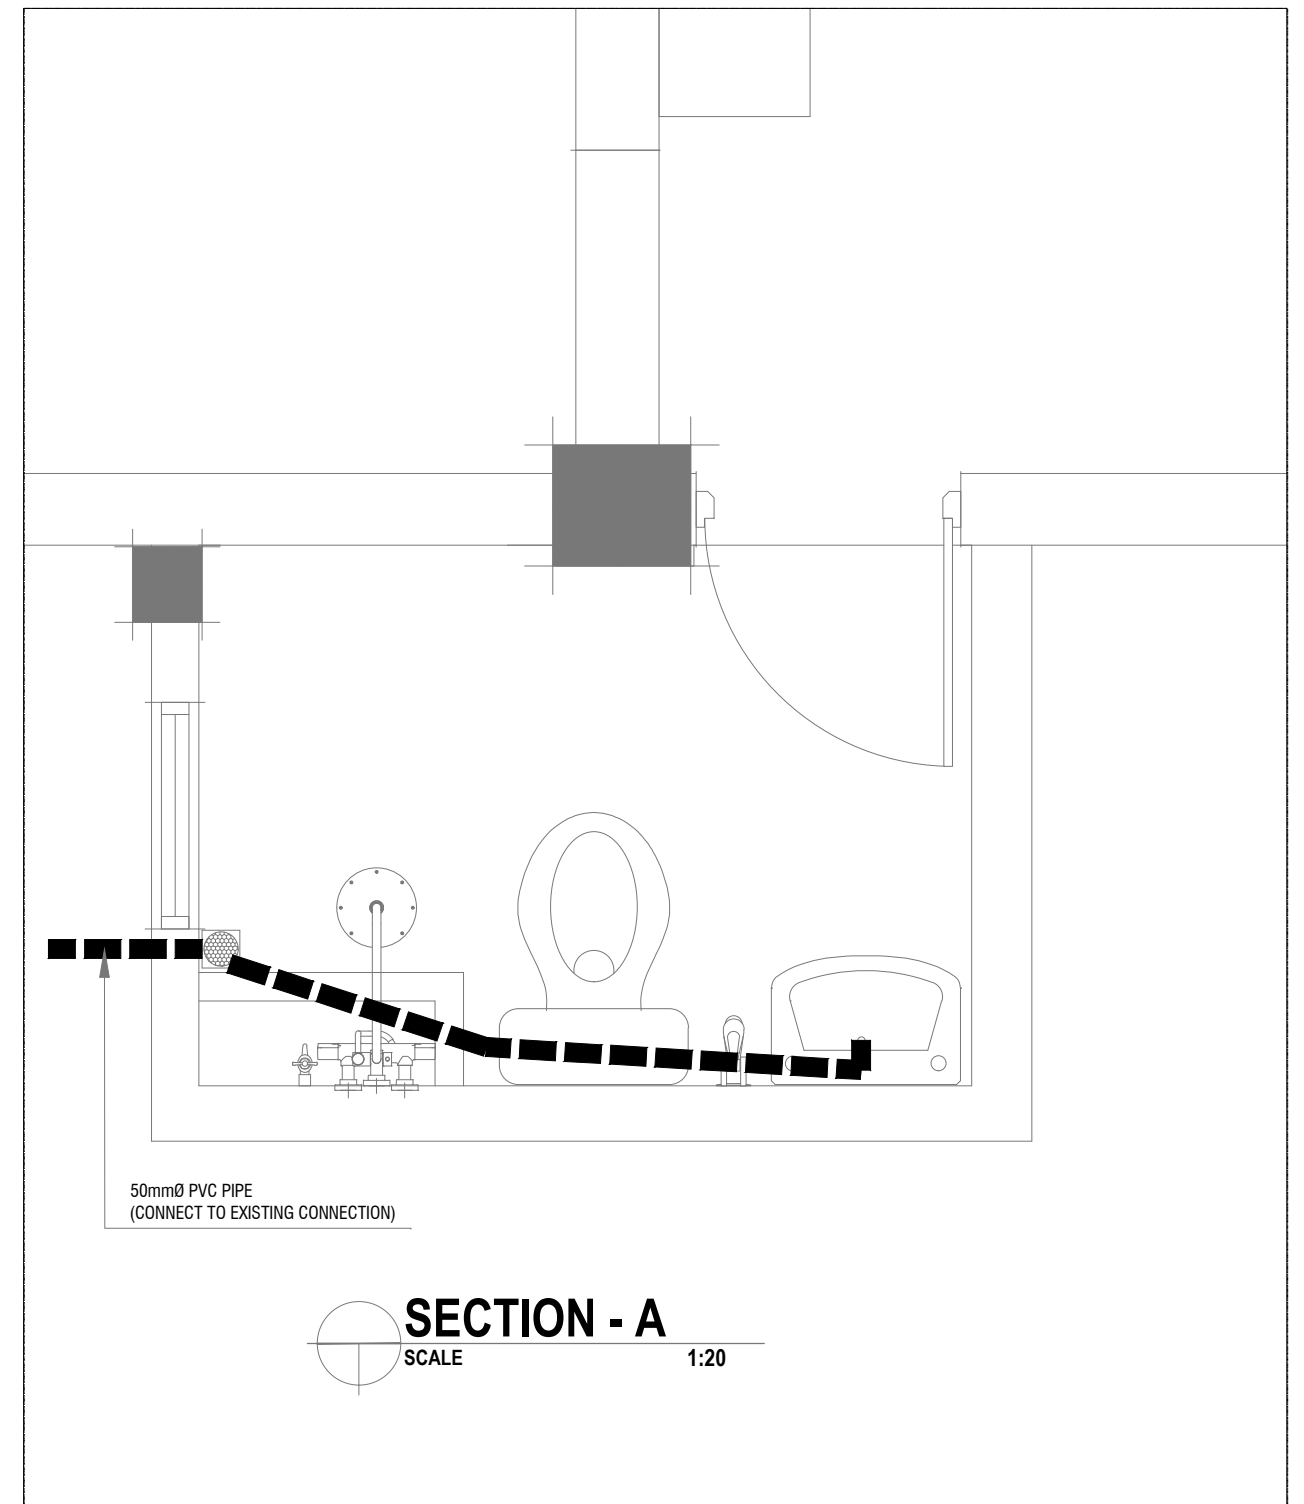
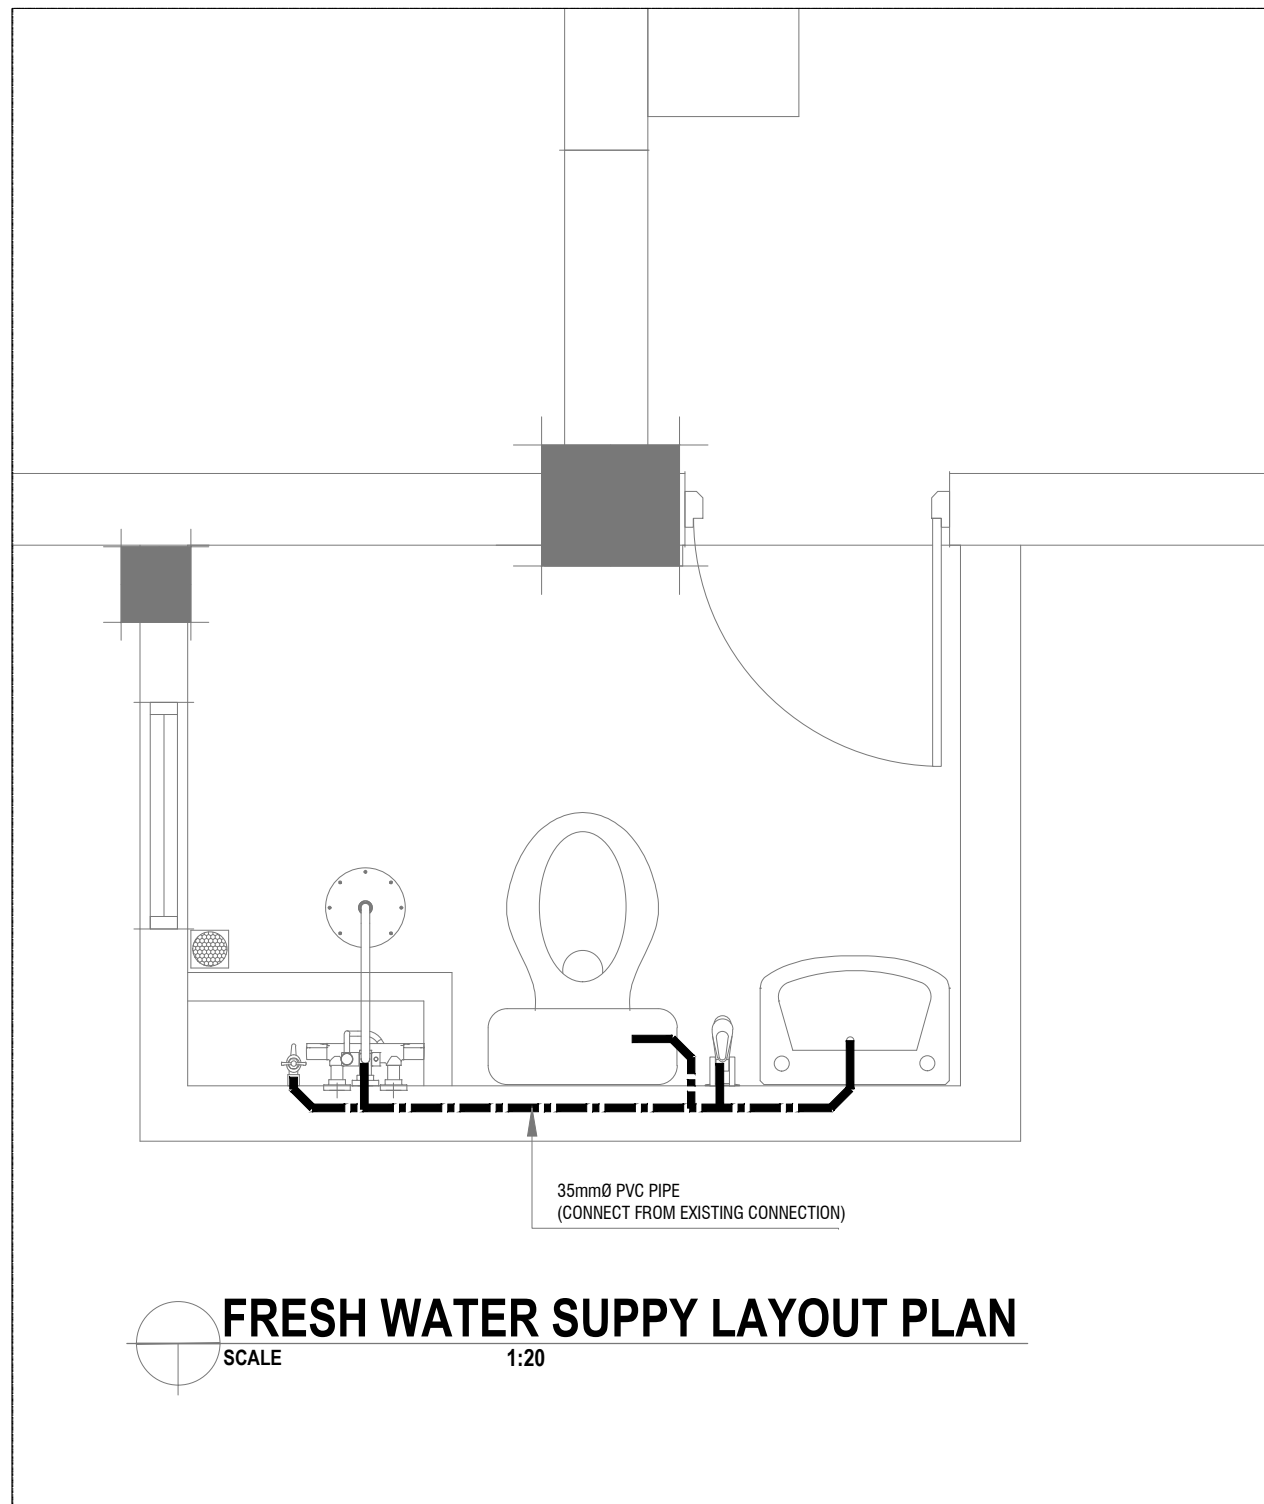

**EXISTING TOILET**  
 SCALE 1:20

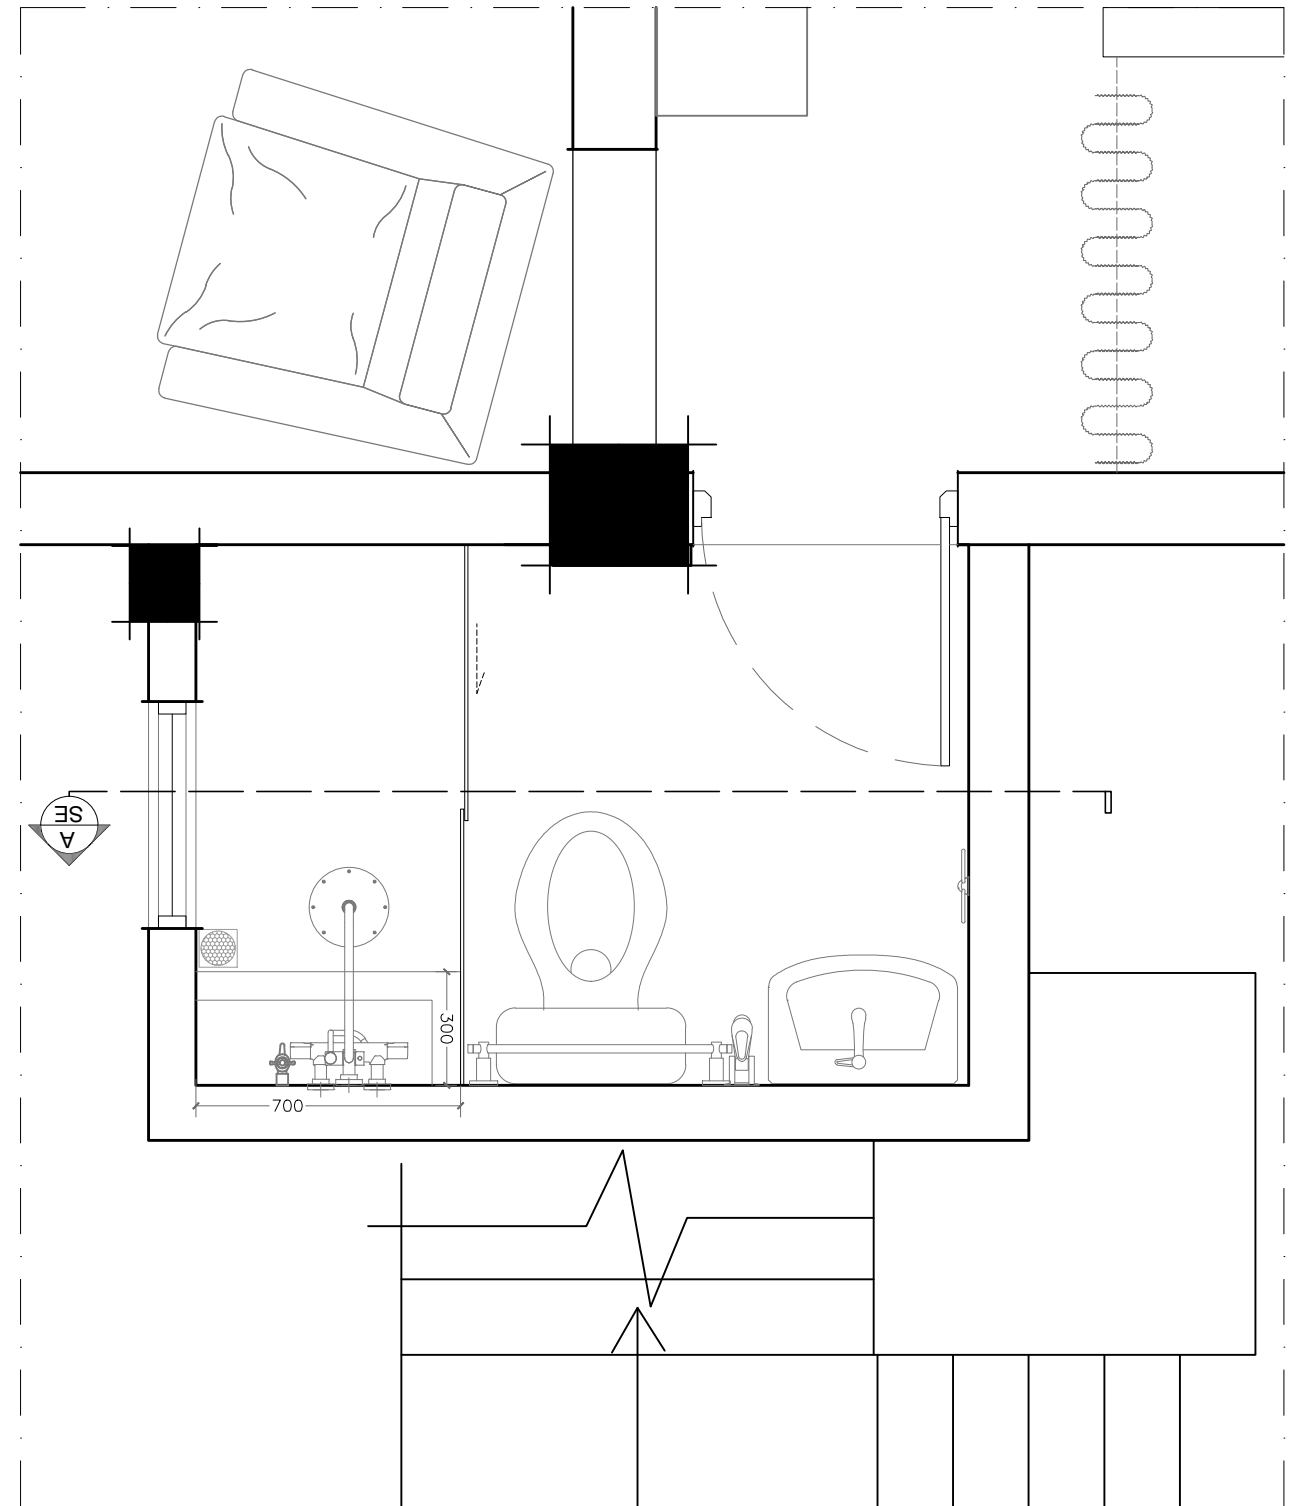


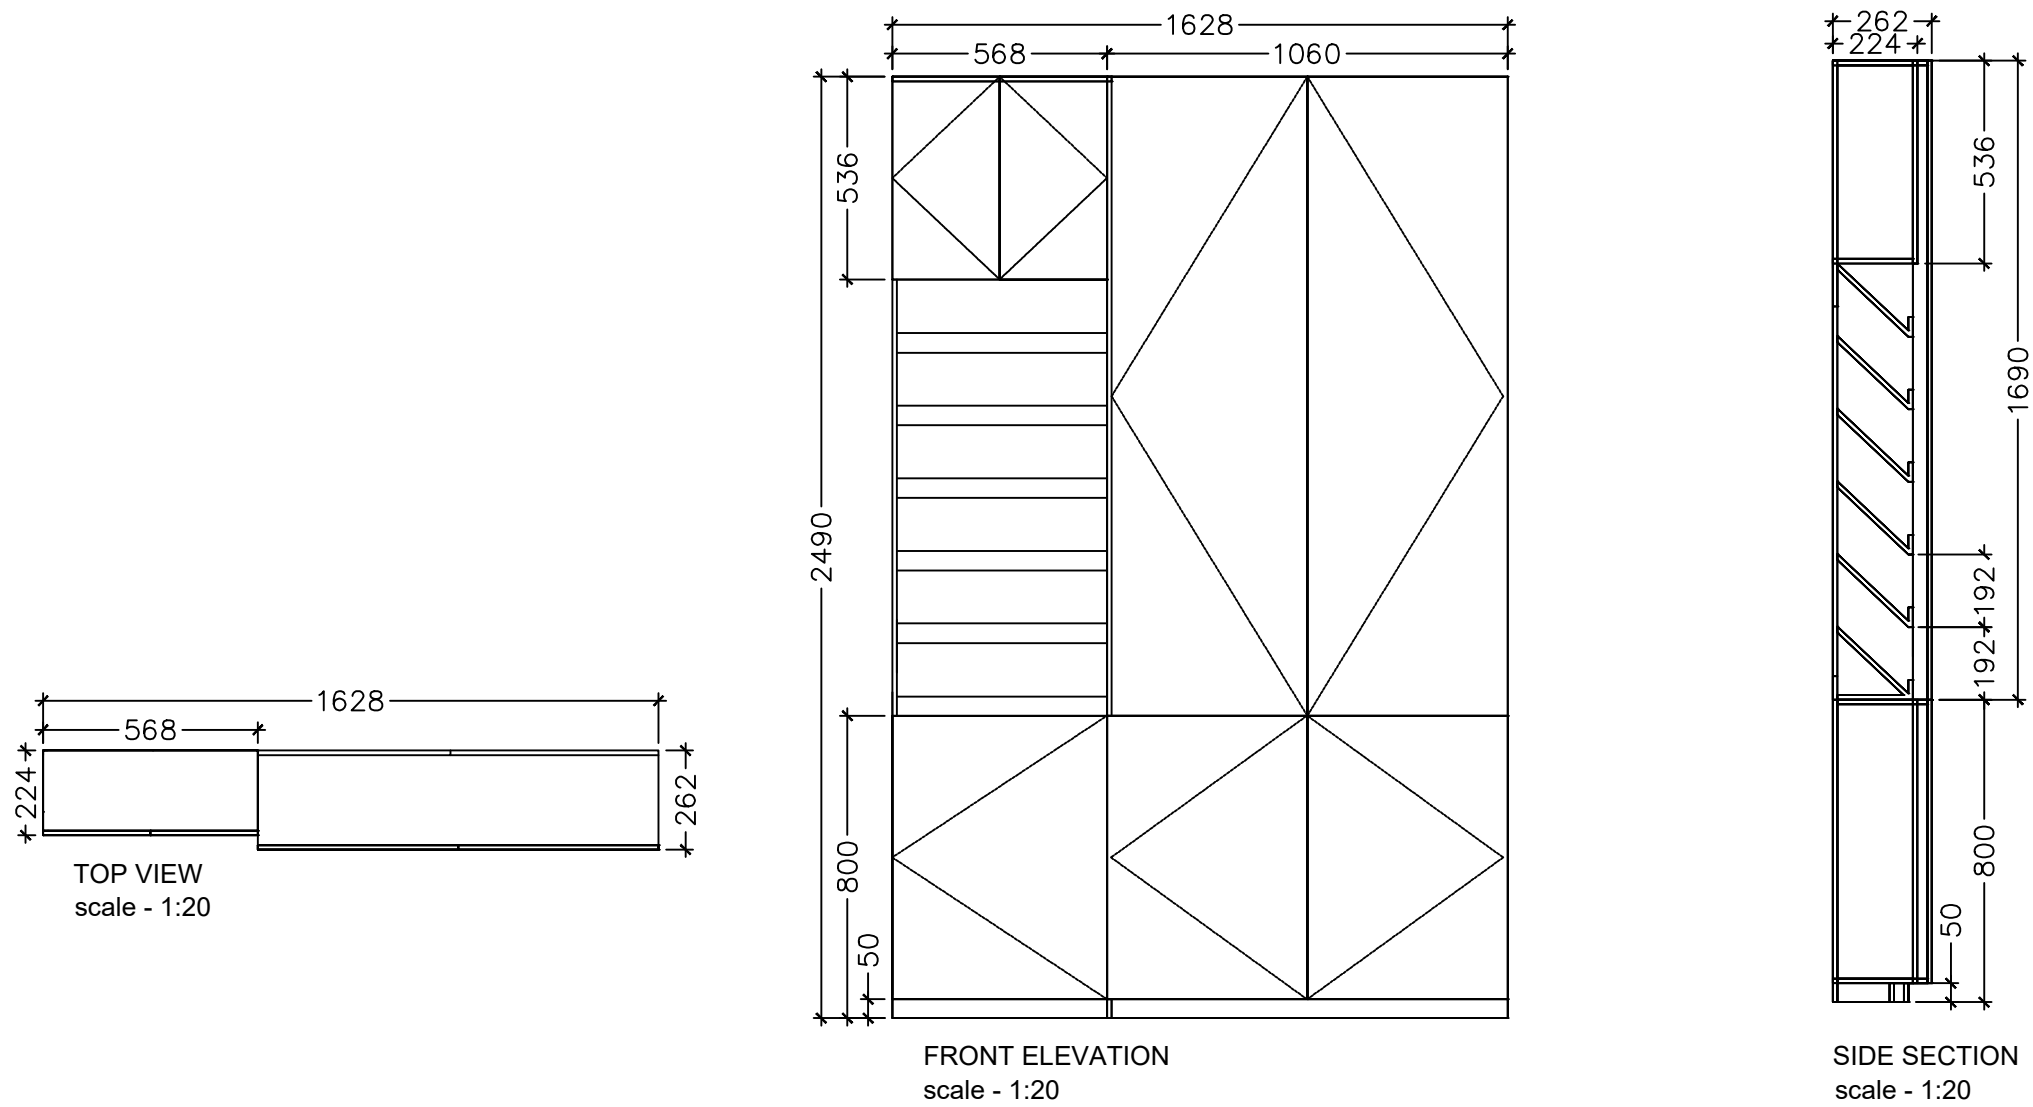

**PROPOSED TOILET**  
 SCALE 1:20


PROJECT :  PROPOSED CENTRE FOR MENTAL HEALTH (PHASE -2)	Drawn : <i>Nausbad</i>	REVISIONS		REMARKS :	APPROVED :	Projects Management Unit IGM Hospital / Kañbaa Aisarani Hingun Malé 20402 / Republic of Maldives	
	Checked :	Revised	15-02-2021				
	SCALE: AS GIVEN	DATE : 07.01.2021					
TITLE: AS MENTIONED	Location: IGMH / GROUND FLOOR (MENTAL HEALTH)					The contractors must check all dimensions on site prior to the commencement of any work.	









PROJECT : PROPOSED CENTRE FOR MENTAL HEALTH (PHASE -2)	Drawn : <i>Nausbad</i> Checked : SCALE: AS GIVEN	REVISIONS		REMARKS :	APPROVED :	Projects Management Unit IGM Hospital / Kañbaa Aisarani Hingun Malé 20402 / Republic of Maldives The contractors must check all dimensions on site prior to the commencement of any work.	
		Revised	15-02-2021				
TITLE: AS MENTIONED	Location: IGMH / GROUND FLOOR (MENTAL HEALTH)		DATE : 07.01.2021				



PROJECT : PROPOSED CENTRE FOR MENTAL HEALTH (PHASE -2)		Drawn : <i>Nausbad</i>		REVISIONS		REMARKS :	APPROVED :	Projects Management Unit IGM Hospital / Kañbaa Aisarani Hingun Malé 20402 / Republic of Maldives		
		Checked :		Revised	15-02-2021					
		SCALE: AS GIVEN		DATE : 07.01.2021						
TITLE: AS MENTIONED		Location: IGMH / GROUND FLOOR (MENTAL HEALTH)								The contractors must check all dimensions on site prior to the commencement of any work.



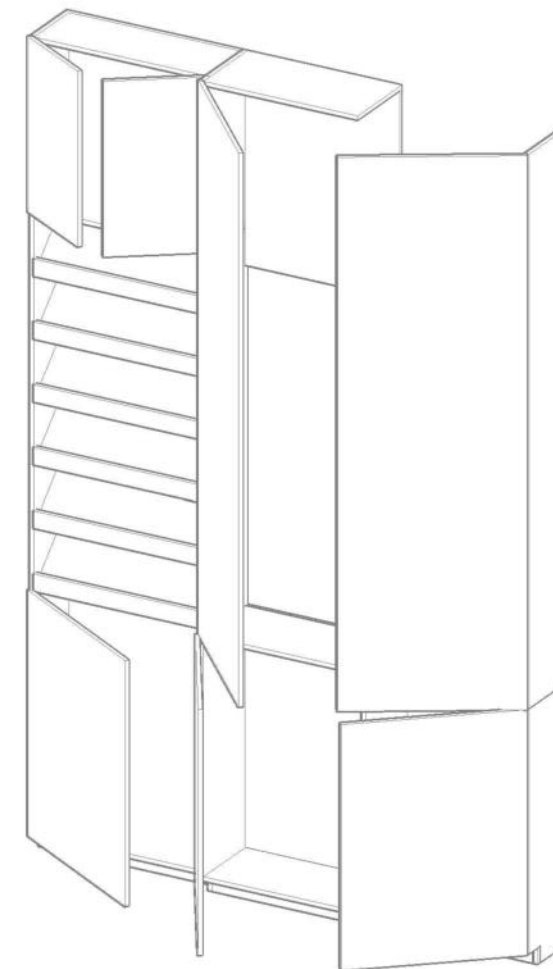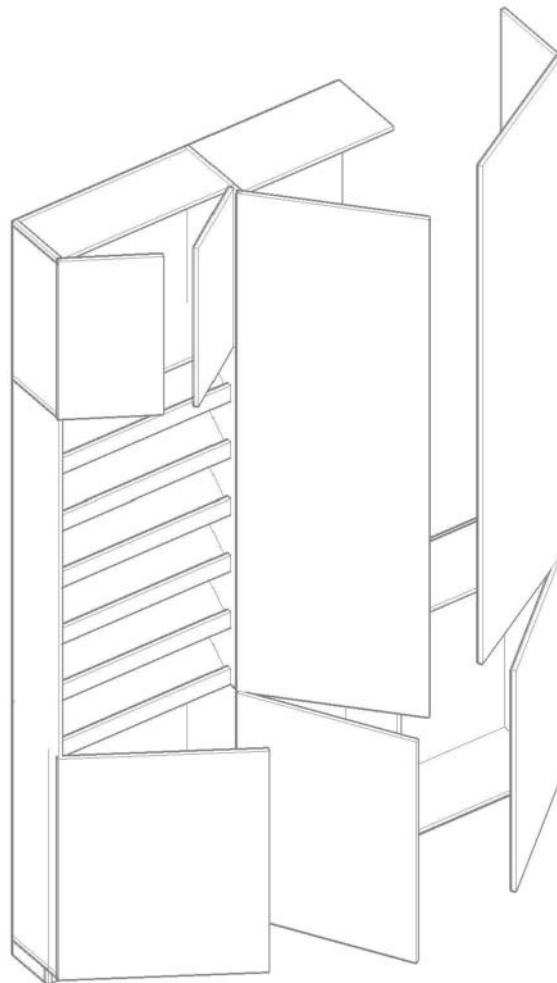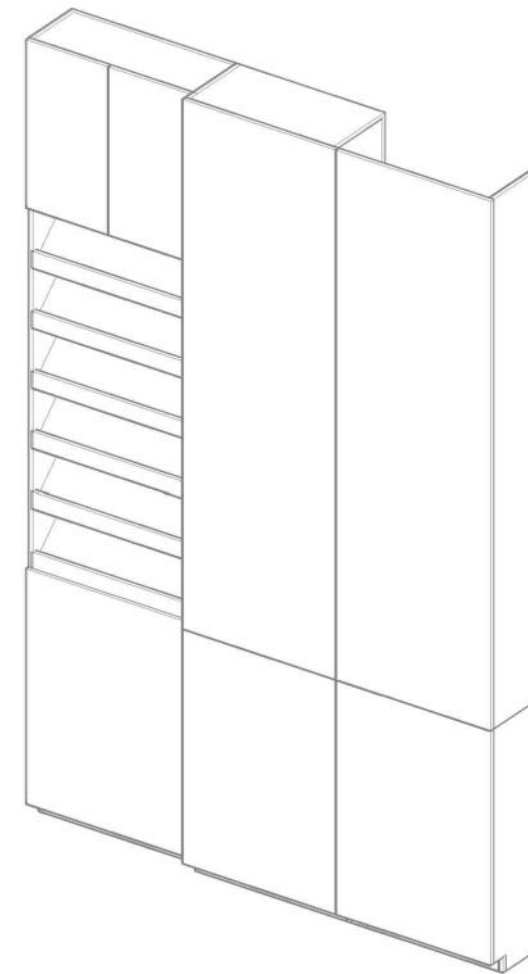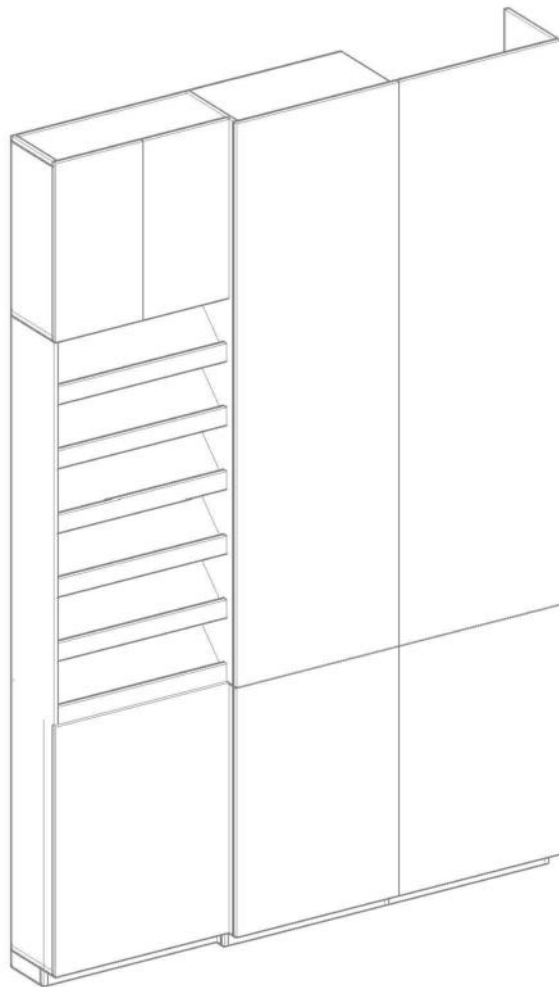

PROJECT :  
PROPOSED CENTRE FOR MENTAL HEALTH (PHASE -2)

TITLE: AS MENTIONED

Drawn : *Nanshad*  
Checked :

SCALE: AS GIVEN

Location: IGMH / GROUND FLOOR (MENTAL HEALTH)

REVISIONS

Revised 15-02-2021

DATE : 07.01.2021

REMARKS :

APPROVED :

Projects Management Unit  
IGM Hospital / Kaibaa Aisarani Hingun  
Malé 20402 / Republic of Maldives

The contractors must check all dimensions on  
site prior to the commencement of any work.

